


EQUIPMENT SCHEDULE	
NO.	DESCRIPTION
1	CAN WASH AREA
2	DRY STORAGE SHELVING RACKS
3	WALL MOUNTED HAND SINKS
4	DRY STORAGE SHELVING RACKS (WALK INS)
5	WALK IN FREEZER
6	(4) COMP. SINK
7	(2) DRAWER SANDWICH PREP UNIT
8	CHAR. GRILL W/ STAND (ON CASTERS)
9	GRIDDLE W/ STAND (ON CASTERS)
10	35 LB. FRYERS (ON CASTERS)
11	HOOD W/ EXHAUST SYSTEM AND ANSUL SYSTEM
12	WALK IN COOLER
13	CARBONATED BEVERAGE MACHINE W/ ICE BIN
14	STAINLESS STEEL WORK TABLE
15	ICE MAKER W/ BIN
16	STAINLESS STEEL SPLASH GUARDS
17	(2) DOOR SANDWICH/ SALAD PREP. UNIT (ON CASTERS)
18	MILK SHAKE MACHINE (ON CASTERS)
19	STAINLESS STEEL WORK TABLE
20	STAINLESS STEEL WORK TABLE
21	TEA DISPENSERS
22	STAINLESS STEEL WORK TABLE
23	BUN WARMER
24	STEAM TABLE (ON CASTERS)
25	(2) DOOR SANDWICH/ SALAD PREP. UNIT (ON CASTERS)
26	PREP. SINK
28	(4) DRAWER UNDER COUNTER REFRIGERATOR
29	STAINLESS STEEL WORK TABLE
30	STAINLESS STEEL WORK TABLE
31	DRINK MIXERS
32	UPRIGHT REFRIGERATOR

PIPING LEGEND	
SYMBOL	DESCRIPTION
	SEWER PIPING
	GREASE PIPING
	VENT PIPING

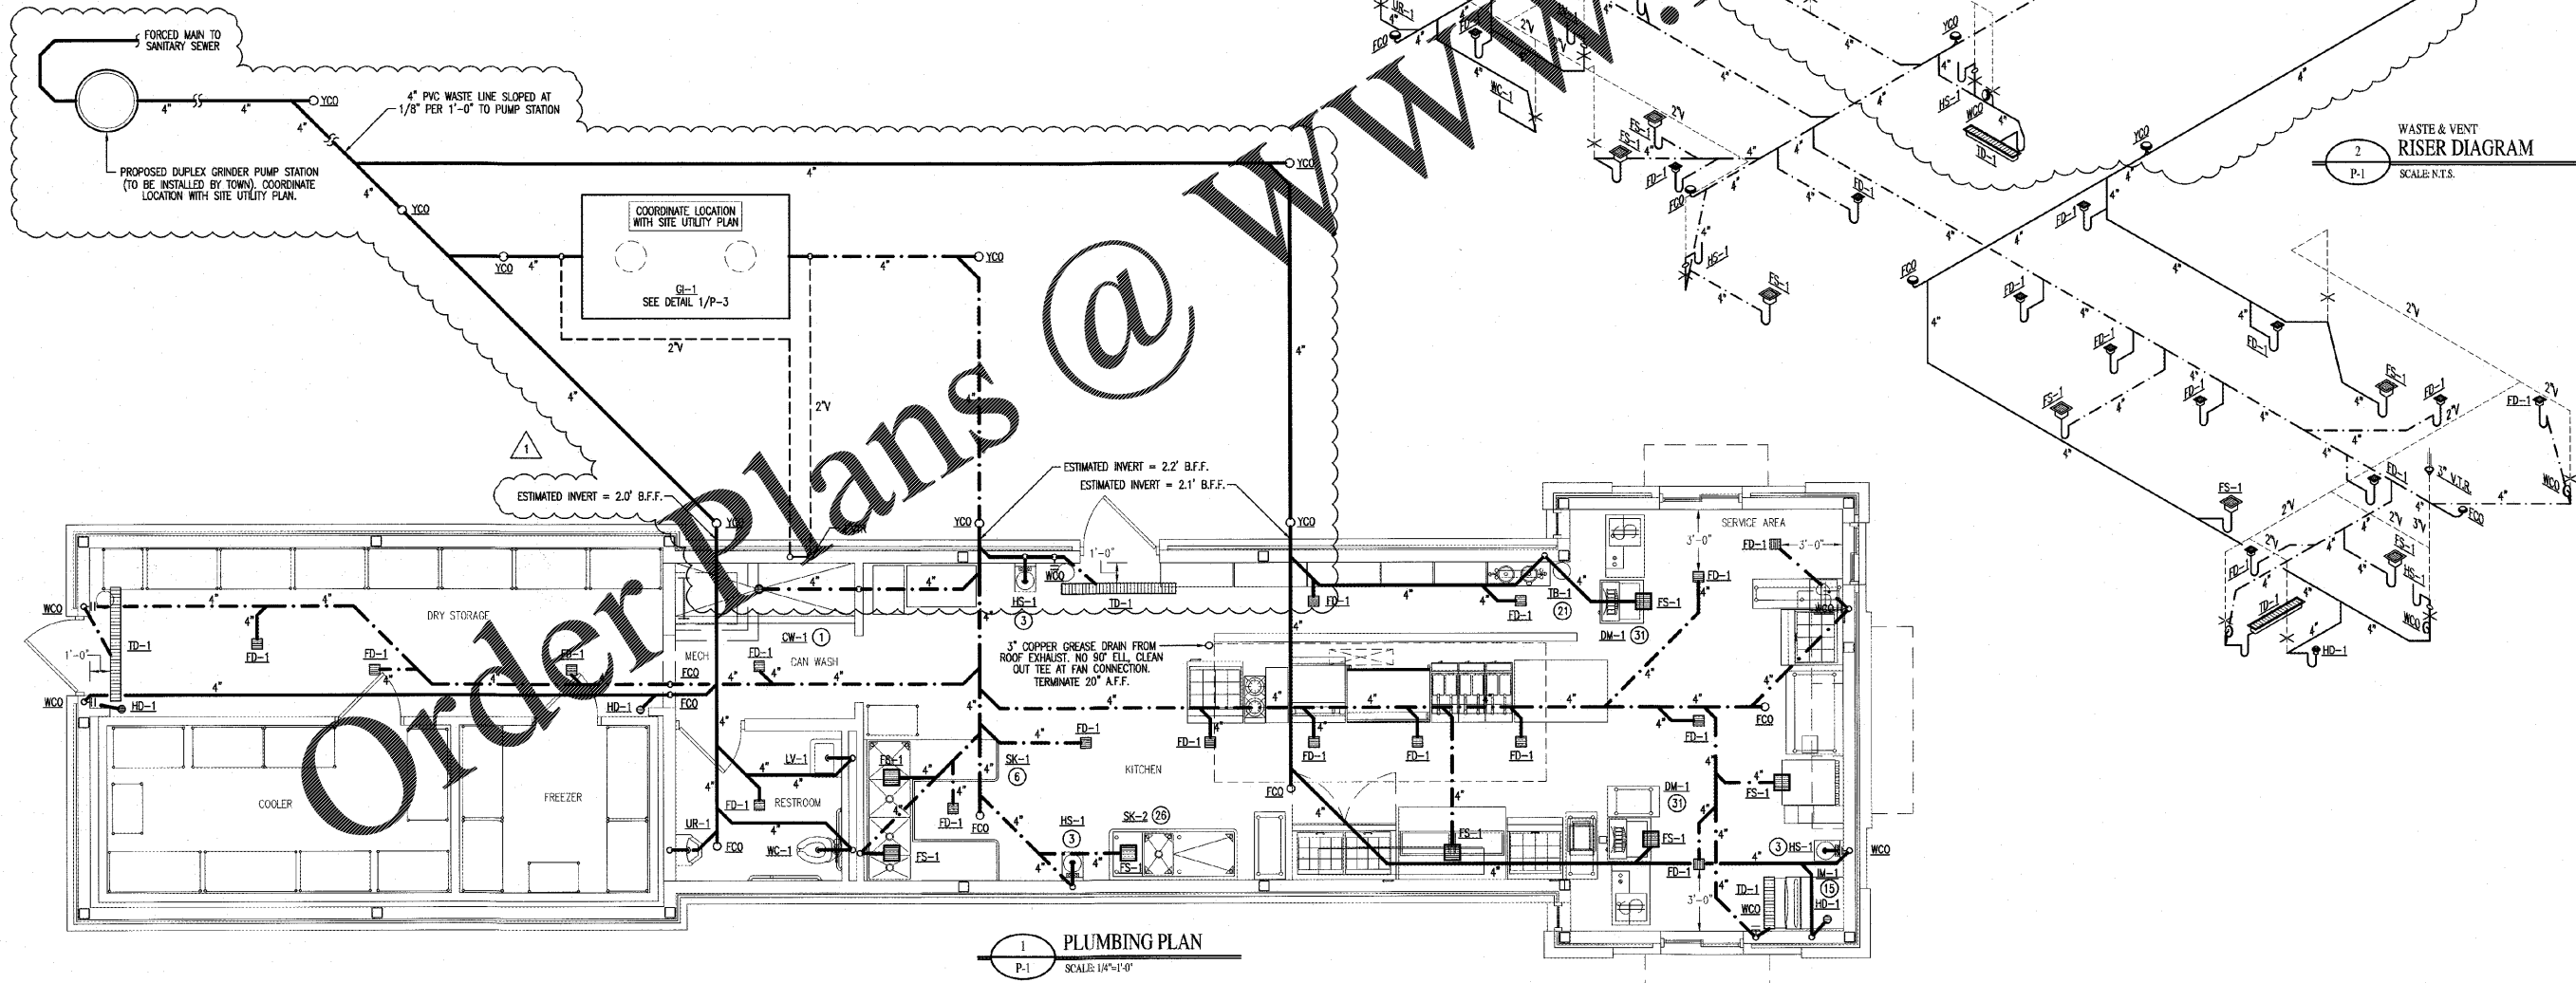


Order Plans @ www.lindseyarchitecture.com

Copyright © 2019 Alamance Consulting Engineers, P.A. All Rights Reserved. No part of these plans may be copied, reproduced or reissued in any way without the express written permission of Alamance Consulting Engineers, P.A.




Alamance Consulting Engineers

961-F Burlington Ave.
Gibsonville, N.C. 27249
Phone: (336) 449-4558
www.ace-nc.net
N.C. Firm License Number C-2071

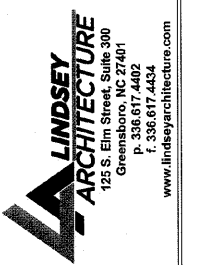

LINDSEY ARCHITECTURE
125 S. Elm Street, Suite 300
Greensboro, NC 27401
P. 336.617.4402
F. 336.617.4434
www.lindseyarchitecture.com

DRAWING NAME:
PLUMBING PLAN

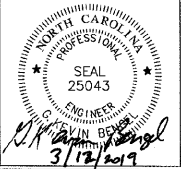

DRAWN: TGW
CHECKED: JNK
DATE: 2/27/19
SCALE: AS NOTED
JOB NO: 19021
SHEET:

P-1

REV #	DATE	BY	CHECKED	DESCRIPTION
1	3/11/19	TGW	JNK	RELOCATED GRINDER PUMP STATION AT THE REQUEST OF SHALLOTTE PUBLIC WORKS DIRECTOR BILL HALL. REFER TO EMAIL DATED 3/6/19 FROM DEBRA HORN OF THE TOWN OF SHALLOTTE.