


INTERIOR ELEVATIONS BELOW MAY NOT SHOW ACTUAL FINAL INTERIOR FINISH. CONTRACTOR SHALL VERIFY WITH OWNER PRIOR TO INSTALLATION OF FINISH. STANDARD FINISH SCHEDULES ARE PROVIDED ON SHEET A-10.


1 EQUIPMENT FLOOR PLAN
A-5 SCALE: 1/4" = 1'-0"

2 OFFICE CAGE ELEVATION
A-5 SCALE: NOT TO SCALE


KITCHEN EQUIPMENT SCHEDULE											
NO.	DESCRIPTION	MANUFACTURER OR EQUAL	MODEL NO. OR EQUAL	NO.	DESCRIPTION	MANUFACTURER OR EQUAL	MODEL NO. OR EQUAL	NO.	DESCRIPTION	MANUFACTURER OR EQUAL	MODEL NO. OR EQUAL
1	DRY STORAGE SHELVING RACK	METRO		15	1'-1" X 2'-8" STAINLESS STEEL CHAR GRILL WORK TABLE	TITAN STAINLESS	CUSTOM BUILT	29	TWO (2) DRAWER REFRIG. SANDWICH / SALAD PREP. UNIT (ON CASTERS)	DELFIELD	D4427N-12M
2	WALL MOUNTED HAND SINK (WITH SPLASH GUARDS)	TITAN STAINLESS	CUSTOM BUILT	16	CHAR GRILL	SOUTHBEND	332N-CC	30	PRO-MAX SMOOTH TWO-SIDED GRILL	STAR	GR10B
3	STORAGE SHELVING RACK (WALK-INS)	METRO		17	CHAR GRILL STAND	TITAN STAINLESS	CUSTOM BUILT	31	1'-6" X 3'-3" STAINLESS STEEL WORK TABLE FOR QUESADILLA GRILL	TITAN STAINLESS	CUSTOM BUILT
4	WALK-IN COOLER	THERMALRITE		18	GRIDDLE	SOUTHBEND	HD-100	32	1'-6" X 2'-6" STAINLESS STEEL PICK-UP WORK TABLE	TITAN STAINLESS	CUSTOM BUILT
5	WALK-IN FREEZER	THERMALRITE		19	GRIDDLE STAND	TITAN STAINLESS	CUSTOM BUILT	33	CARBONATED BEVERAGE MACHINE (WITH ICE BIN)	COKE DISTRIBUTOR	
6	TANKLESS WATER HEATER	RINNAI	RUR98i	20	40-50 LB. FRYER (ON CASTERS)	PCO	SG14	34	STAINLESS STEEL WORK TABLE (REGISTER TABLE)	TITAN STAINLESS	CUSTOM BUILT
7	CAN WASH AREA			21	STAINLESS STEEL WHEEL STOP GUARDRAIL	CUSTOM BUILT	CUSTOM BUILT	35	RAZZLE DRINK MIXER	RAZZLE	
8	FOUR (4) COMPARTMENT SINK (WITH SPLASH GUARDS)	TITAN STAINLESS	CUSTOM BUILT	22	3'-0" X 4'-6" STAINLESS STEEL FRY WORK TABLE	TITAN STAINLESS	CUSTOM BUILT	36	10-1/4" X 2'-10" STAINLESS STEEL MIXER WORK TABLE	TITAN STAINLESS	CUSTOM BUILT
9	WALL-MOUNTED HAND SINK (WITH SPLASH GUARDS)	TITAN STAINLESS	SHS-1012-CUSTOM	23	FOUR (4) DRAWER UNDER COUNTER REFRIG. (ON CASTERS)	DELFIELD	UCD448N	37	SOFT SERVER FREEZER (ON CASTERS)	TAYLOR	772
10	ICE MAKER	HOSHIZAKI	F-1501MRJ-C	24	1'-6" X 3'-3" STAINLESS STEEL WORK TABLE	TITAN STAINLESS	CUSTOM BUILT	38	4'-0" X 2'-9" STAINLESS STEEL SHAKE WORK TABLE	TITAN STAINLESS	CUSTOM BUILT
11	UPRIGHT ICE BIN	KLOPPENBERG	905-SBB	25	TWO (2) DOOR REFRIG. SANDWICH / SALAD PREP. UNIT (ON CASTERS)	BEVERAGE-AIR	SPE60-24M	39	STAINLESS STEEL WORK TABLE (REGISTER TABLE)	TITAN STAINLESS	CUSTOM BUILT
12	VEGETABLE PREP SINK (WITH SPLASH GUARDS)	TITAN STAINLESS	CUSTOM BUILT	26	STEAM TABLE HOT FOOD WELLS	APW WYOTT	HFV-23	40	TEA DISPENSERS (WITH BUNN 41400.0000 TEA BREWER)	BUNN	
13	TWO (2) DRAWER REFRIG. SANDWICH / SALAD PREP. UNIT (ON CASTERS)	DELFIELD	D4432N-12M	27	STAINLESS STEEL STEAM TABLE (ON CASTERS)	TITAN STAINLESS	CUSTOM BUILT	41	1'-2" X 3'-0" STAINLESS STEEL TEA WORK TABLE	TITAN STAINLESS	CUSTOM BUILT
14	HOOD WITH EXHAUST AND ANSUL SYSTEM (16 FT)	CAPTIVE AIRE	5424ND-2-ACPS-F	28	BUN WARMER	HENNY PENNY	BW-8				

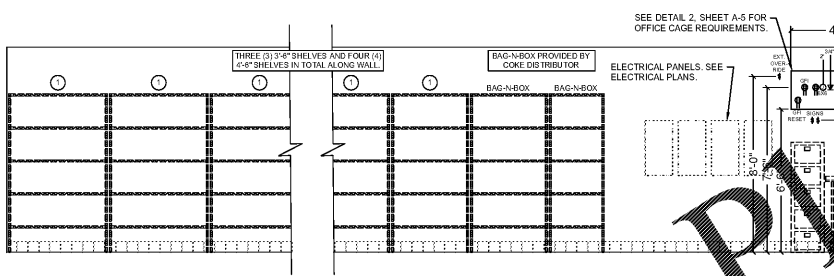


3 KITCHEN ELEVATION
A-5 SCALE: 1/4" = 1'-0"

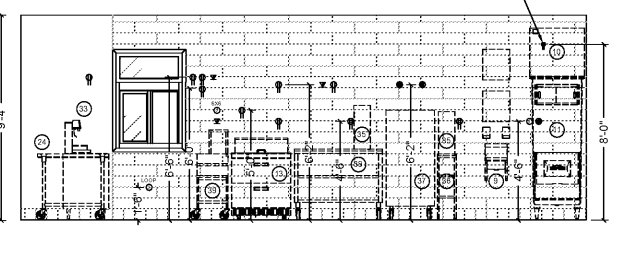


4 KITCHEN SERVICE AREA
A-5 SCALE: 1/4" = 1'-0"

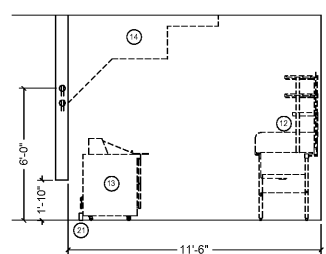


5 KITCHEN HOOD
A-5 SCALE: 1/4" = 1'-0"

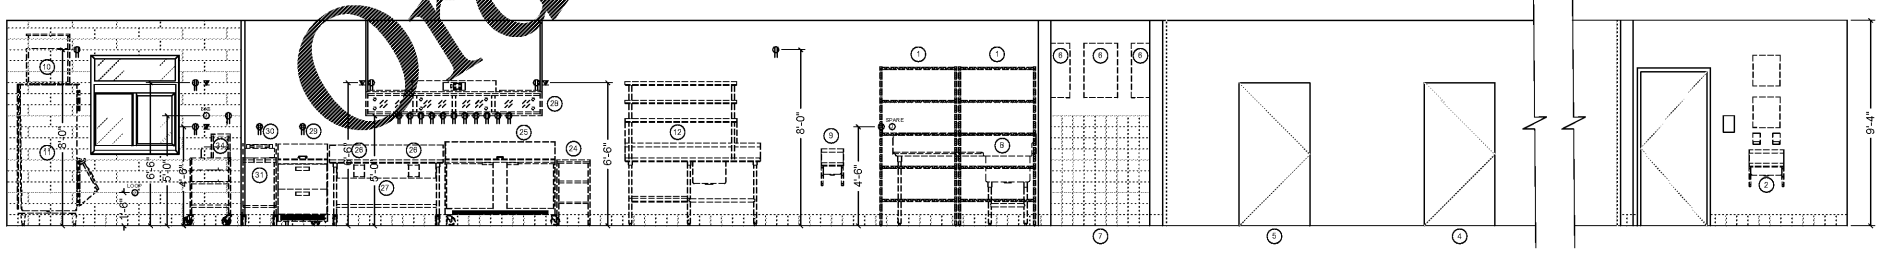

6 KITCHEN ELEVATION
A-5 SCALE: 1/4" = 1'-0"

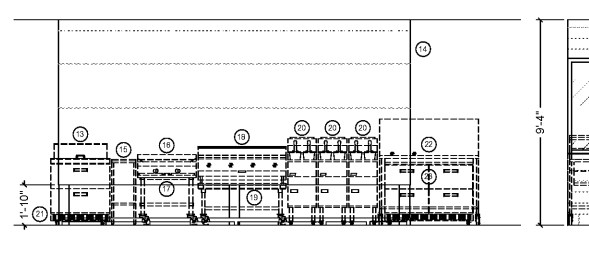

7 KITCHEN HOOD
A-5 SCALE: 1/4" = 1'-0"

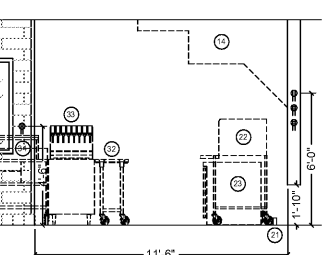

8 SERVICE AREA
A-5 SCALE: 1/4" = 1'-0"

BRIAN LATHROP, ARCHITECT
Healthcare Architecture Planning Project Analysis Interiors
6270 Black Rock Court Cumming, GA 30041 (770)983-7300
This drawing and all parts of it are the property of Brian Lathrop, Architect. Prints are to be returned upon completion. Brian Lathrop, Architect reserves the right to make any changes to this drawing without notice.

REV. DATE DESCRIPTION
NO. NO. NO.

STAMP
BRIAN LATHROP
ARCHITECT
CUMMING, GA
4/5/19

COMMERCIAL SITE DESIGN, PLLC
6372 Creechwood Road
Raleigh, NC 27615 (919) 948-9121

SUNMEY ENGINEERING ASSOC., PLLC
P.O. Box 988
Asheboro, NC 27204 (336) 328-0902

MECHANICAL ELECTRICAL PLUMBING ENGINEERING
SUNMEY ENGINEERING ASSOC., PLLC
P.O. Box 988
Asheboro, NC 27204 (336) 328-0902

COOK-OUT RESTAURANTS
4145 S. MEMORIAL DRIVE
PITT COUNTY - WINTERVILLE TOWNSHIP - NORTH CAROLINA

KEY PLAN

JOB NO. E-5450
DRAWN VBA
CHECKED BR
DATE 02.15.2019
TITLE
EQUIPMENT FLOOR PLAN
AND INTERIOR
ELEVATIONS
SHEET NO. **A-5**