


(OPTIONAL)  
CANOPY

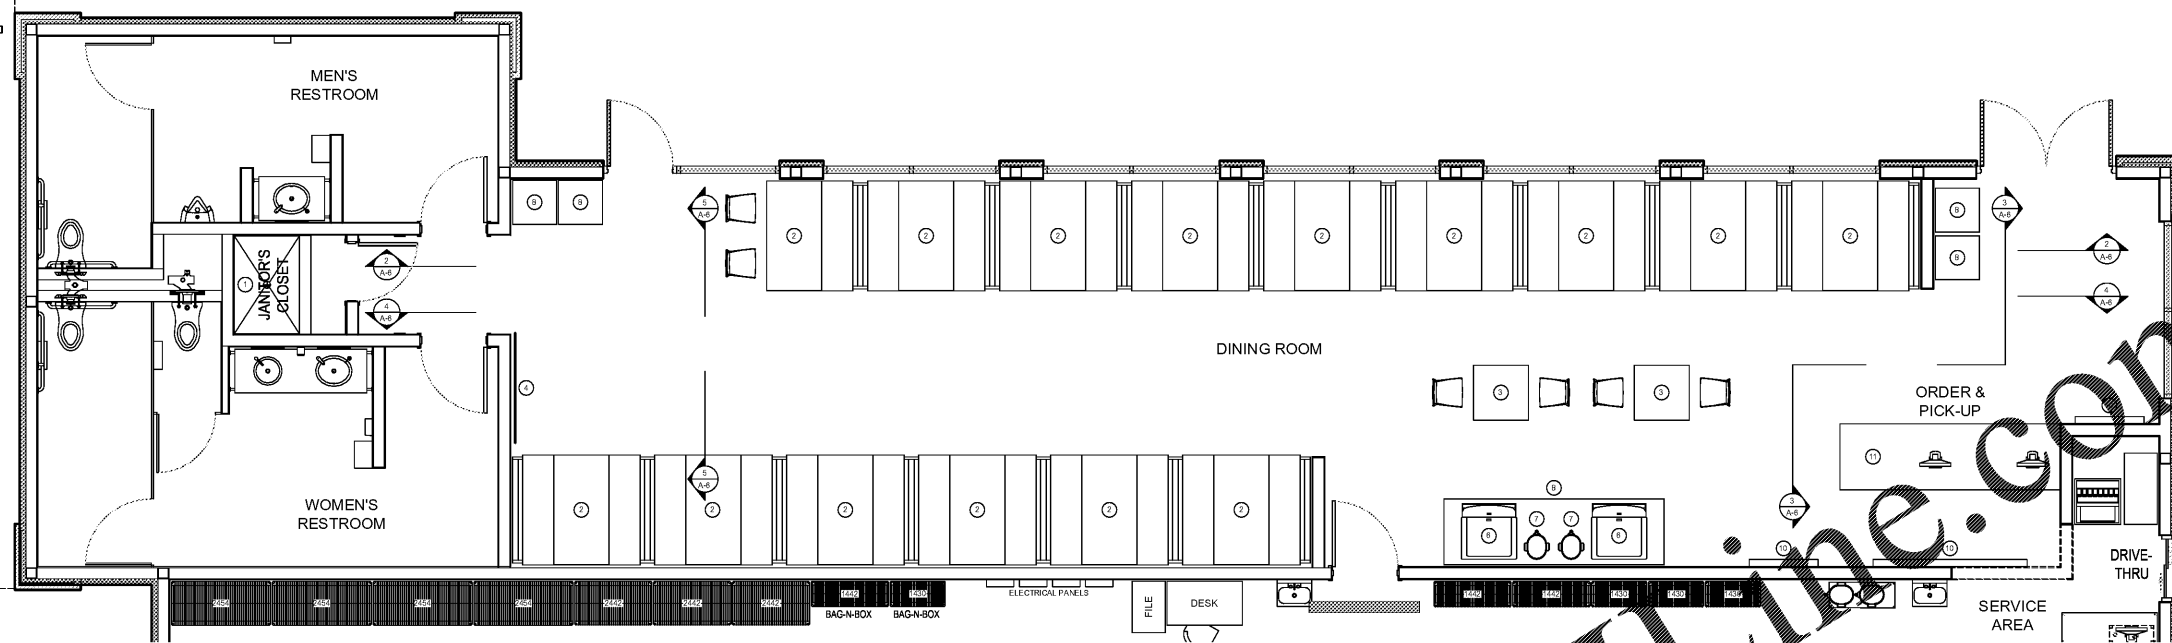

**LEGEND**


- DUPLEX RECEPTACLE
- QUAD RECEPTACLE
- 208V/3Ø
- 208V/1Ø
- TELE/DATA OUTLET
- JUNCTION BOX
- ⬮ SWITCH

INTERIOR ELEVATIONS BELOW MAY NOT SHOW ACTUAL FINAL INTERIOR FINISH. CONTRACTOR SHALL VERIFY WITH OWNER PRIOR TO INSTALLATION OF FINISH. STANDARD FINISH SCHEDULES ARE PROVIDED ON SHEET A-10.


**1 FURNITURE FLOOR PLAN**  
A-6 SCALE: 1/4" = 1'-0"

**DINING ROOM FURNITURE SCHEDULE**


NO.	DESCRIPTION	MANUFACTURER OR EQUAL	MODEL NO. OR EQUAL	NO.	DESCRIPTION	MANUFACTURER OR EQUAL	MODEL NO. OR EQUAL	NO.	DESCRIPTION	MANUFACTURER OR EQUAL	MODEL NO. OR EQUAL
1	JANITOR CLOSET (SITE BUILT MOP SINK)	CUSTOM BUILT	CUSTOM BUILT	5	TRASH CAN	TITAN STAINLESS		9	3'-0" SEMI-CIRCULAR WASHFOUNTAIN	BRADLEY	WF2703
2	2'-6" X 5'-0" TABLE (BOOTH SEATING EACH SIDE)			6	CARBONATED BEVERAGE MACHINE (WITH ICE MAKER)	COKE DISTRIBUTOR	WF2703	10	MENU SIGNAGE	CUSTOM BUILT	CUSTOM BUILT
3	2'-6" X 2'-6" ADA ACCESSIBLE TABLE			7	TEA DISPENSER	BUCK		11	3'-0" X 10'-0" REGISTER TABLE	TITAN STAINLESS	CUSTOM BUILT
4	60" WIDE MIRROR			8	3'-0" X 10'-0" SELF-SERVE TABLE	TITAN STAINLESS	CUSTOM BUILT	12	(OPTIONAL) CARBONATED BEVERAGE MACHINE (WITH ICE BIN)	COKE DISTRIBUTOR	

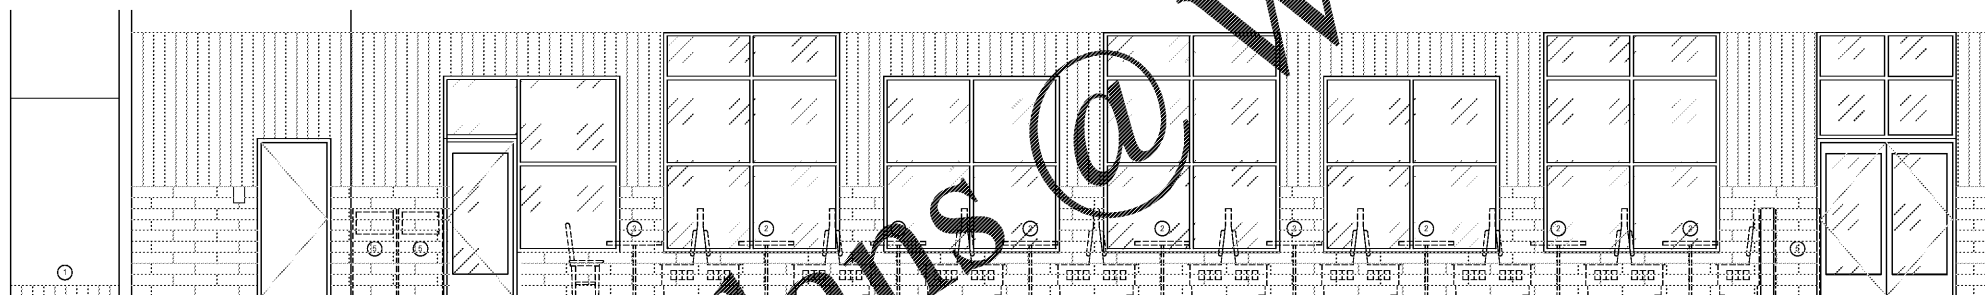


**2 DINING ROOM**  
A-6 SCALE: 1/4" = 1'-0"

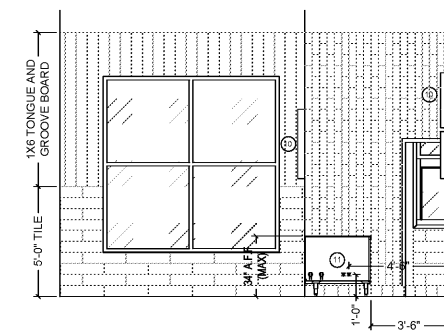

**3 DINING ROOM**  
A-6 SCALE: 1/4" = 1'-0"

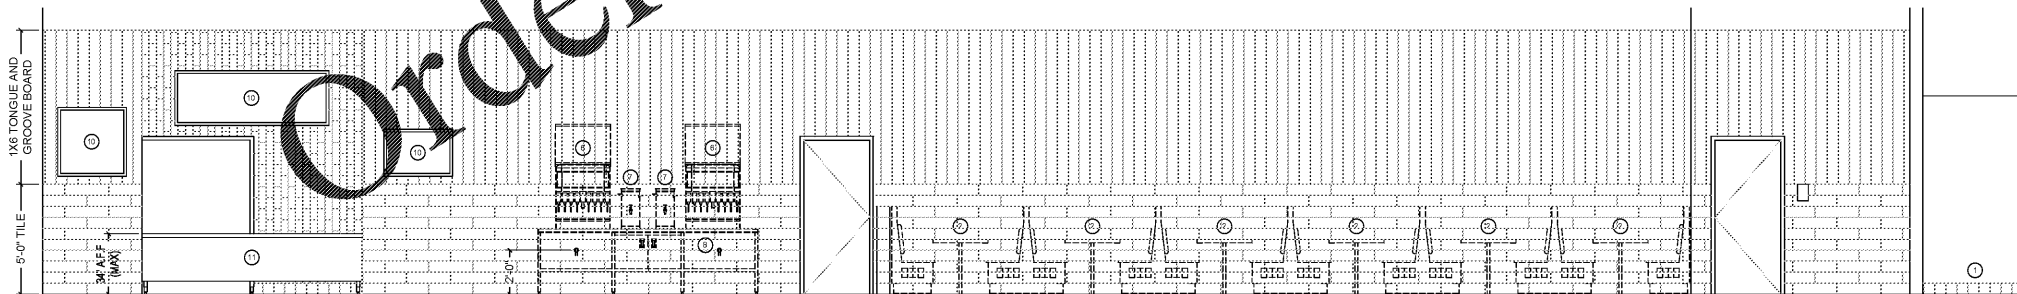

**4 DINING ROOM**  
A-6 SCALE: 1/4" = 1'-0"

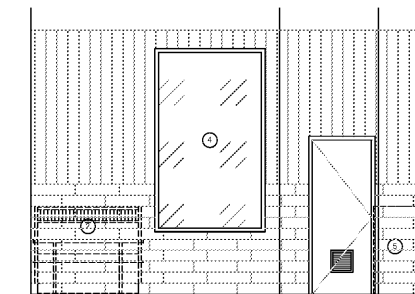

**5 DINING ROOM**  
A-6 SCALE: 1/4" = 1'-0"

**BRIAN LATHROP, ARCHITECT**  
Healthcare Architecture Planning Project Analysis Interiors  
6270 Black Rock Court Cumming, GA 30041 (770)993-7300  
This drawing and all parts of it are the property of Brian Lathrop, Architect. Prints are to be returned upon completion. Brian Lathrop, Architect reserves the right to alter the drawings without notice.

REV. DATE DESCRIPTION




COMMERCIAL SITE DESIGN, PLLC  
637 Crendmore Road  
Raleigh, NC 27610 (919) 948-9121  
SUMMEY ENGINEERING ASSOC., PLLC  
P.O. Box 968  
Asheboro, NC 27204 (336) 328-0902  
MECHANICAL, ELECTRICAL, PLUMBING ENGINEERING  
SUMMEY ENGINEERING ASSOC., PLLC  
P.O. Box 968  
Asheboro, NC 27204 (336) 328-0902

BUILDING PLANS FOR  
**COOK-OUT RESTAURANTS**  
4145 S. MEMORIAL DRIVE  
PITT COUNTY - WINTERVILLE TOWNSHIP - NORTH CAROLINA

KEY PLAN

JOB NO. E-5450  
DRAWN WBA  
CHECKED BRJ  
DATE 02.15.2019  
TITLE  
FURNITURE FLOOR PLAN  
AND INTERIOR  
ELEVATIONS  
SHEET NO. **A-6**