



Summey Engineering Associates, PLLC
 Engineering - Land Planning - Consulting
 PO Box 968
 Ashboro, NC 27204
 Phone: 336-328-0922 Fax: 336-328-0922
 E-mail: mack@shabaro.com
 NC Professional Engineering Firm License No. P-0336

WINTERVILLE, NORTH CAROLINA

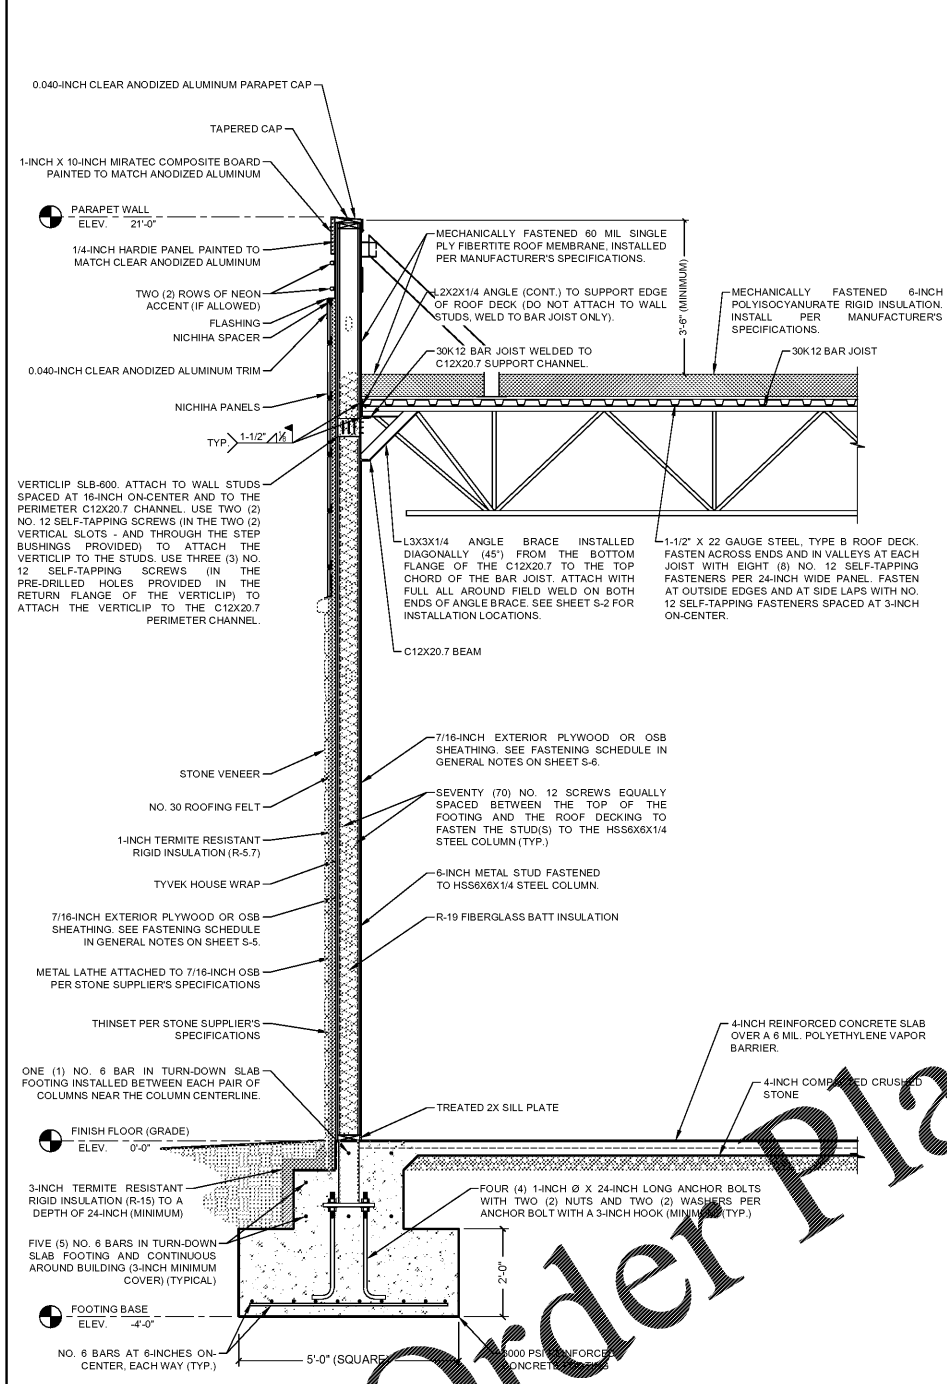

1
 S-5
 LOW PARAPET
 TYPICAL WALL SECTION
 SCALE: NOT TO SCALE

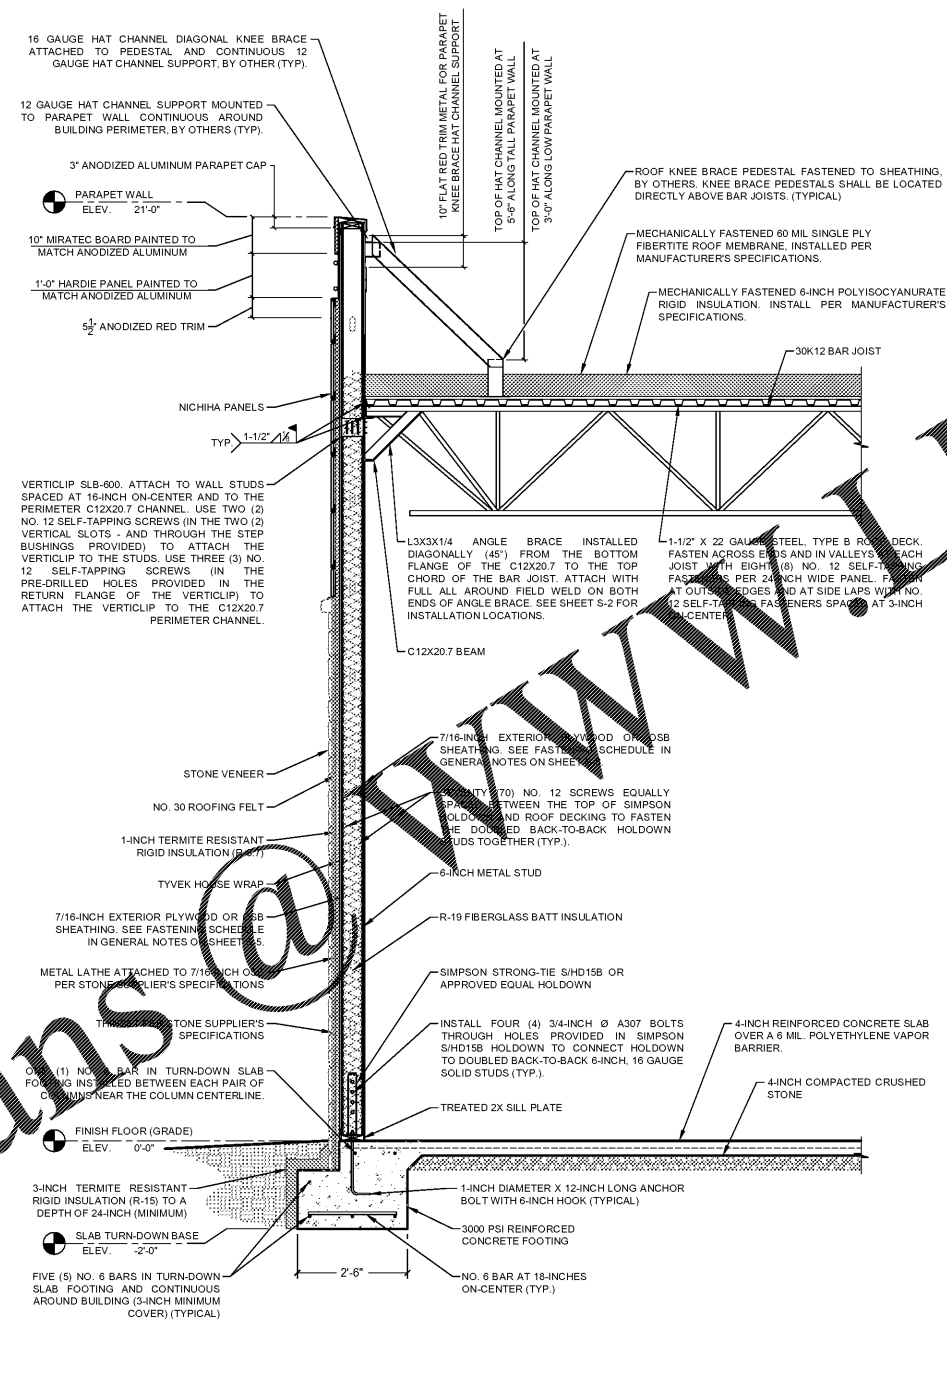

2
 S-5
 LOW PARAPET
 TYPICAL WALL SECTION
 SCALE: NOT TO SCALE

Order Plans @ WWW.LDILine.com

No.	Date	Description	By

TYPICAL WALL SECTIONS
COOK-OUT RESTAURANTS
 4145 S. MEMORIAL DRIVE
 PITT COUNTY - WINTERVILLE TOWNSHIP - NORTH CAROLINA

Scale:	AS NOTED
Date:	FEBRUARY 2019
Drawn By:	WBAV/PBC
Checked By:	WBA
Job No.:	E-54150

Sheet No.
S-5
 5 of 6