


Summey Engineering Associates, PLLC
 Engineering - Land Planning - Consulting
 PO Box 568
 Asheville, NC 27204
 Phone: 336-528-0922 Fax: 336-528-0922
 E-mail: mack@summey.com
 NC Professional Engineering Firm License No. P-9336

No.	Date	Description	By

PLUMBING PLAN
COOK-OUT RESTAURANTS
 4145 S. MEMORIAL DRIVE
 PITT COUNTY - WINTERVILLE TOWNSHIP - NORTH CAROLINA

Scale	Date	Drawn By	Checked By	Job No.
AS NOTED	APRIL 2019	ECB	HW5J	E-5450

Sheet No. **P-4**
 4 of 6

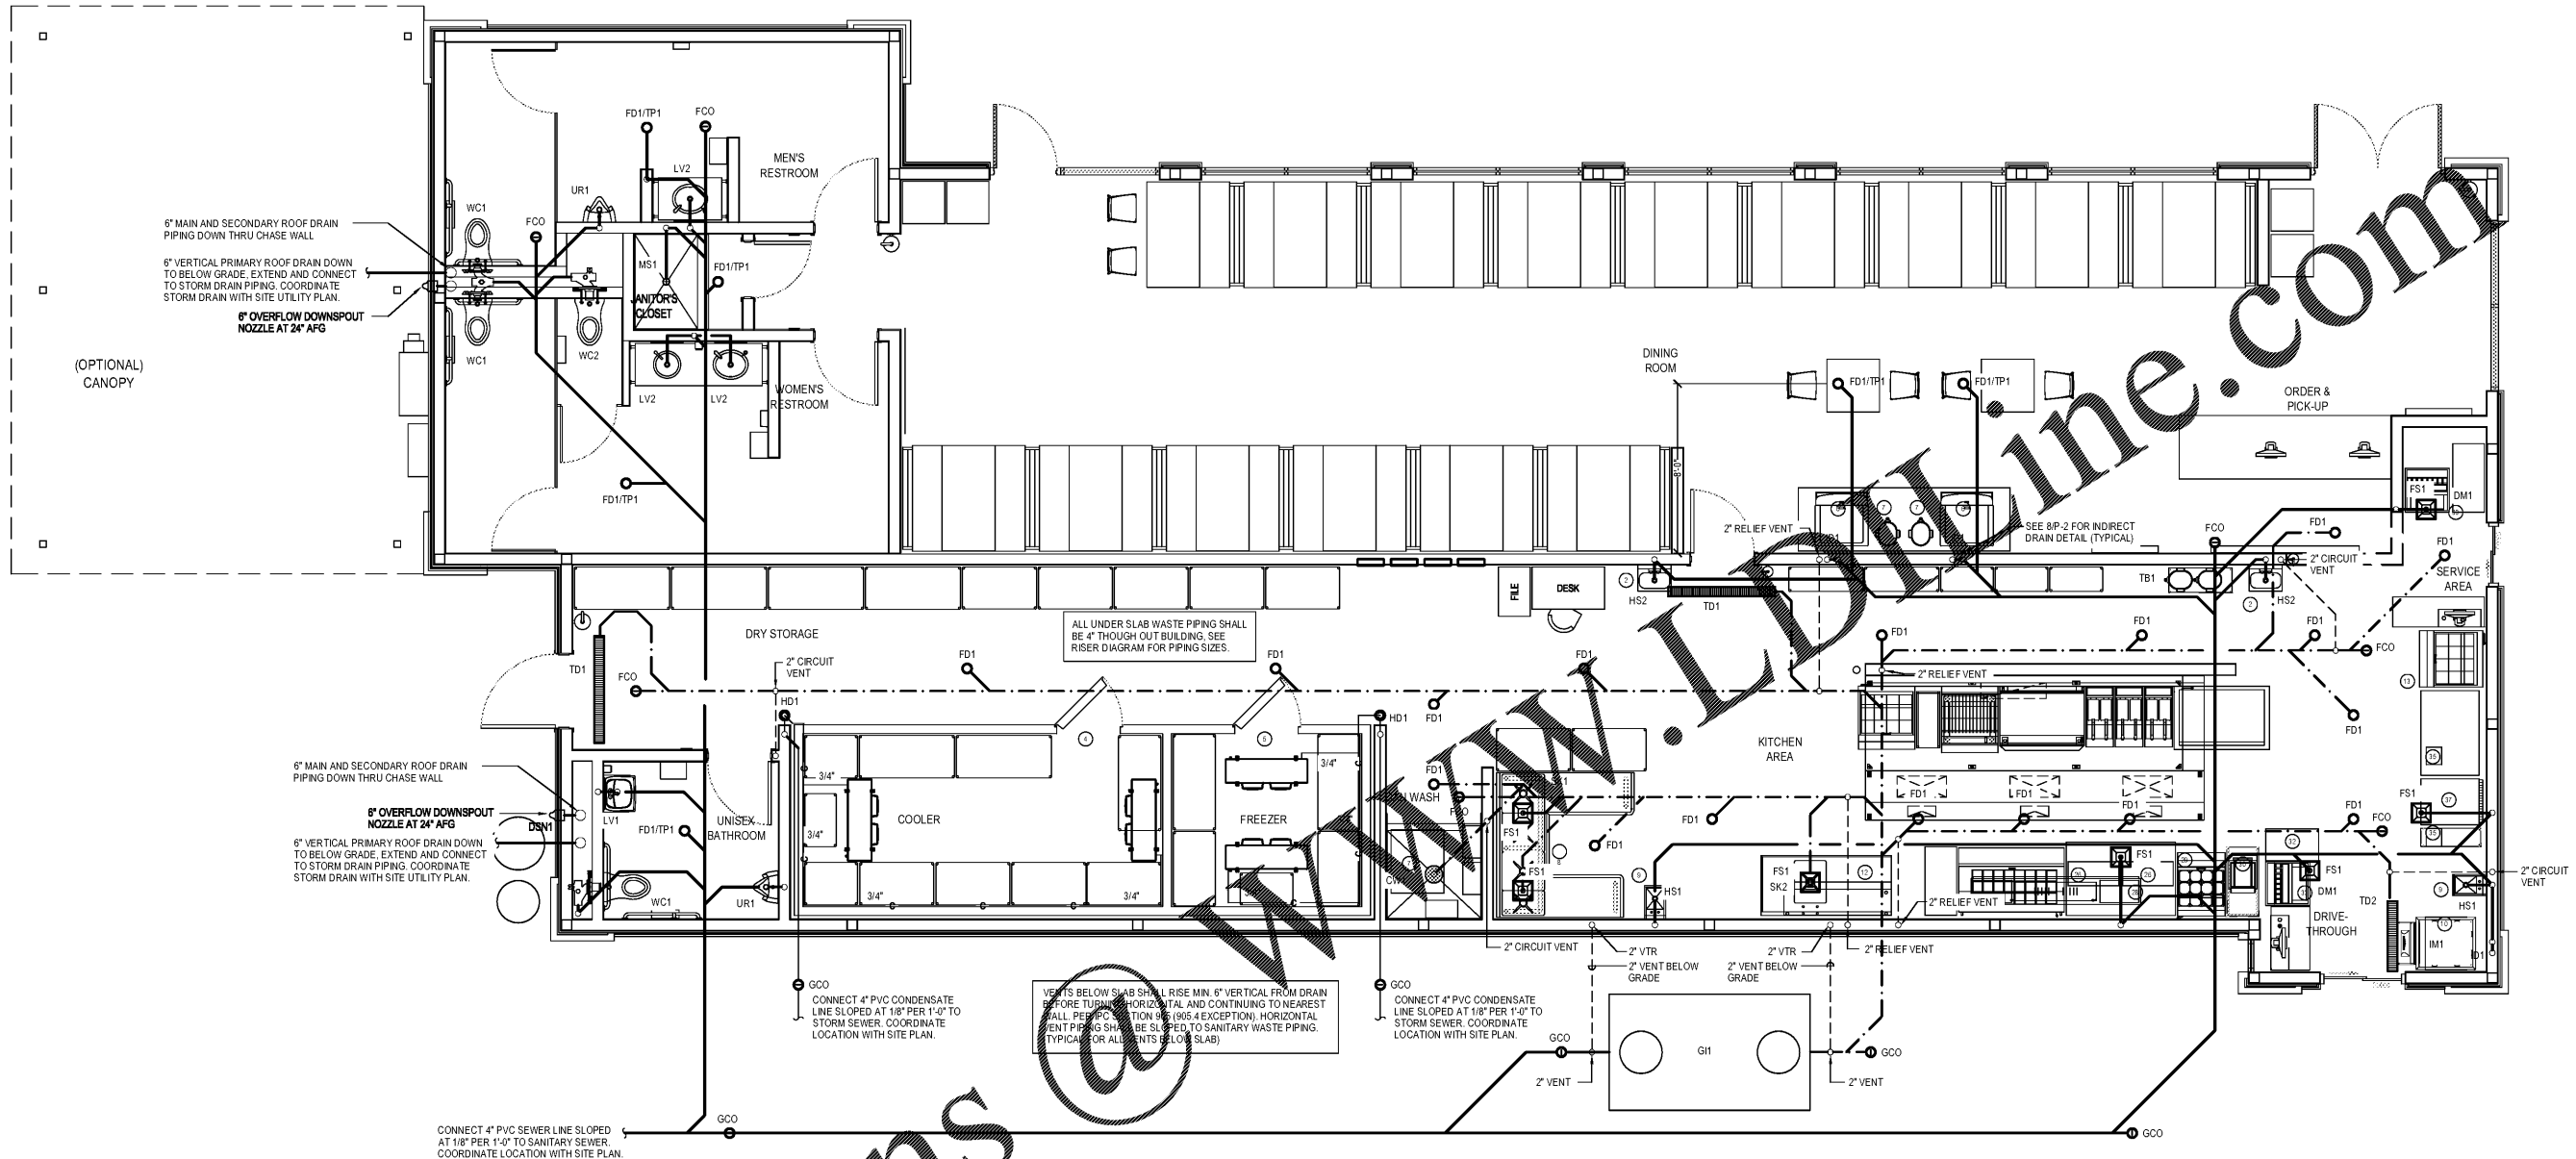

1 PLUMBING PLAN
 P-4 SCALE: 1/4" = 1'-0"

KITCHEN EQUIPMENT SCHEDULE											
NO.	DESCRIPTION	MANUFACTURER OR EQUAL	MODEL NO. OR EQUAL	NO.	DESCRIPTION	MANUFACTURER OR EQUAL	MODEL NO. OR EQUAL	NO.	DESCRIPTION	MANUFACTURER OR EQUAL	MODEL NO. OR EQUAL
1	DRY STORAGE (10' X 10')	METRO		15	1'-1" X 2'-0" STAINLESS STEEL CHAR GRILL WORK TABLE	TITAN STAINLESS	CUSTOM BUILT	29	TWO (2) DRAWER REFRIG. SANDWICH / SALAD PREP. UNIT (ON CASTERS)	DELFIELD	D4427N-12M
2	WALL MOUNTED HAND SINK	TITAN STAINLESS	CUSTOM BUILT	16	CHAR GRILL	SOUTHBEND	P32N-CC	30	QUESADILLA GRILL	WELLS	
3	SHRIMP COOKING RACK (WALL MOUNT)	METRO		17	CHAR GRILL STAND	TITAN STAINLESS	CUSTOM BUILT	31	1'-0" X 3'-3" STAINLESS STEEL WORK TABLE FOR QUESADILLA GRILL	TITAN STAINLESS	CUSTOM BUILT
4	WALK-IN COOLER	THERMALRITE		18	GRIDDLE	SOUTHBEND	HDG-48	32	1'-0" X 2'-0" STAINLESS STEEL PICK-UP WORK TABLE	TITAN STAINLESS	CUSTOM BUILT
5	WALK-IN FREEZER	THERMALRITE		19	GRIDDLE STAND	TITAN STAINLESS	CUSTOM BUILT	33	CARBONATED BEVERAGE MACHINE (WITH ICE BIN)	COKE DISTRIBUTOR	
6	TANKLESS WATER HEATER	RINNAI	RUR98i	20	40-50 LB. FRYER (ON CASTERS)	PITCO	SG14	34	STAINLESS STEEL WORK TABLE (REGISTER TABLE)	TITAN STAINLESS	CUSTOM BUILT
7	COFFEE WASH AREA			21	STAINLESS STEEL WHEEL STOP GUARDRAIL	CUSTOM BUILT	CUSTOM BUILT	35	RAZZLE DRINK MIXER	RAZZLE	
8	FOUR (4) COMPARTMENT SINK	TITAN STAINLESS	CUSTOM BUILT	22	3'-0" X 4'-0" STAINLESS STEEL FRY WORK TABLE	TITAN STAINLESS	CUSTOM BUILT	36	10-1/4" X 2'-0" STAINLESS STEEL MIXER WORK TABLE	TITAN STAINLESS	CUSTOM BUILT
9	WALL-MOUNTED HAND SINK	TITAN STAINLESS	SHS-1012-CUSTOM	23	FOUR (4) DRAWER UNDER COUNTER REFRIG. (ON CASTERS)	DELFIELD	UCD48N	37	SOFT SERVER FREEZER (ON CASTERS)	TAYLOR	772
10	ICE MAKER	MANITOWOC	RFS-2378C	24	1'-0" X 3'-3" STAINLESS STEEL WORK TABLE	TITAN STAINLESS	CUSTOM BUILT	38	4'-0" X 2'-0" STAINLESS STEEL SHAKE WORK TABLE	TITAN STAINLESS	CUSTOM BUILT
11	UPRIGHT ICE BIN	KLOPPENBERG	905-SBB	25	TWO (2) DOOR REFRIG. SANDWICH / SALAD PREP. UNIT (ON CASTERS)	BEVERAGE-AIR	SPE60-24M	39	STAINLESS STEEL WORK TABLE (REGISTER TABLE)	TITAN STAINLESS	CUSTOM BUILT
12	VEGETABLE PREP SINK	TITAN STAINLESS	CUSTOM BUILT	26	STEAM TABLE HOT FOOD WELLS	APW WYOTT	HPW-23	40	TEA DISPENSERS	BUNN	
13	TWO (2) DRAWER REFRIG. SANDWICH / SALAD PREP. UNIT (ON CASTERS)	DELFIELD	D4427N-12M	27	STAINLESS STEEL STEAM TABLE (ON CASTERS)	TITAN STAINLESS	CUSTOM BUILT	41	1'-2" X 3'-0" STAINLESS STEEL TEA WORK TABLE	TITAN STAINLESS	CUSTOM BUILT
14	HOOD WITH EXHAUST AND ANSUL SYSTEM (10 FT)	CAPTIVE AIRE	542ND-BR	28	BUN WARMER	HENRY PENNY	BW-8				

DINING ROOM FURNITURE SCHEDULE											
NO.	DESCRIPTION	MANUFACTURER OR EQUAL	MODEL NO. OR EQUAL	NO.	DESCRIPTION	MANUFACTURER OR EQUAL	MODEL NO. OR EQUAL	NO.	DESCRIPTION	MANUFACTURER OR EQUAL	MODEL NO. OR EQUAL
1	JANITOR CLOSET (SITE BUILT MOP SINK)	CUSTOM BUILT	CUSTOM BUILT	5	TRASH CAN	TITAN STAINLESS		9	3'-0" SEMI-CIRCULAR WASHFOUNTAIN	BRADLEY	WF2703
2	2'-0" X 5'-0" TABLE (BOOTH SEATING EACH SIDE)			6	CARBONATED BEVERAGE MACHINE (WITH ICE MAKER)	COKE DISTRIBUTOR	WF2703	10	MENU SIGNAGE	CUSTOM BUILT	CUSTOM BUILT
3	2'-0" X 2'-0" ADA ACCESSIBLE TABLE			7	TEA DISPENSER	BUNN		11	3'-0" X 9'-0" REGISTER TABLE	TITAN STAINLESS	CUSTOM BUILT
4	60" WIDE MIRROR			8	(OPTIONAL) 3'-0" X 10'-0" SELF-SERVE TABLE	TITAN STAINLESS	CUSTOM BUILT	12	(OPTIONAL) CARBONATED BEVERAGE MACHINE (WITH ICE BIN)	COKE DISTRIBUTOR	

Plot File: C:\Users\mcb\OneDrive\Documents\Projects\2019\19-0000\19-0000-0000\19-0000-0000-0000.dwg, 4/10/2019 10:54:24 AM, Plot Scale: 1/4" = 1'-0"