

Summey Engineering Associates, PLLC
 Engineering - Land Planning - Consulting


PO Box 568
 Asheville, NC 27204
 Phone: 336-528-0922 Fax: 336-528-0922
 E-mail: mack@summey.com
 NC Professional Engineering Firm License No. P-9336

No.	Date	Description

WATER PIPING PLAN
COOK-OUT RESTAURANTS
 4145 S. MEMORIAL DRIVE
 PITT COUNTY - WINTERVILLE TOWNSHIP - NORTH CAROLINA

Scale	AS NOTED
Date	APRIL 2019
Drawn By	ECB
Checked By	HWSJ
Job No.	E-5450

Sheet No.
P-5
 5 of 6

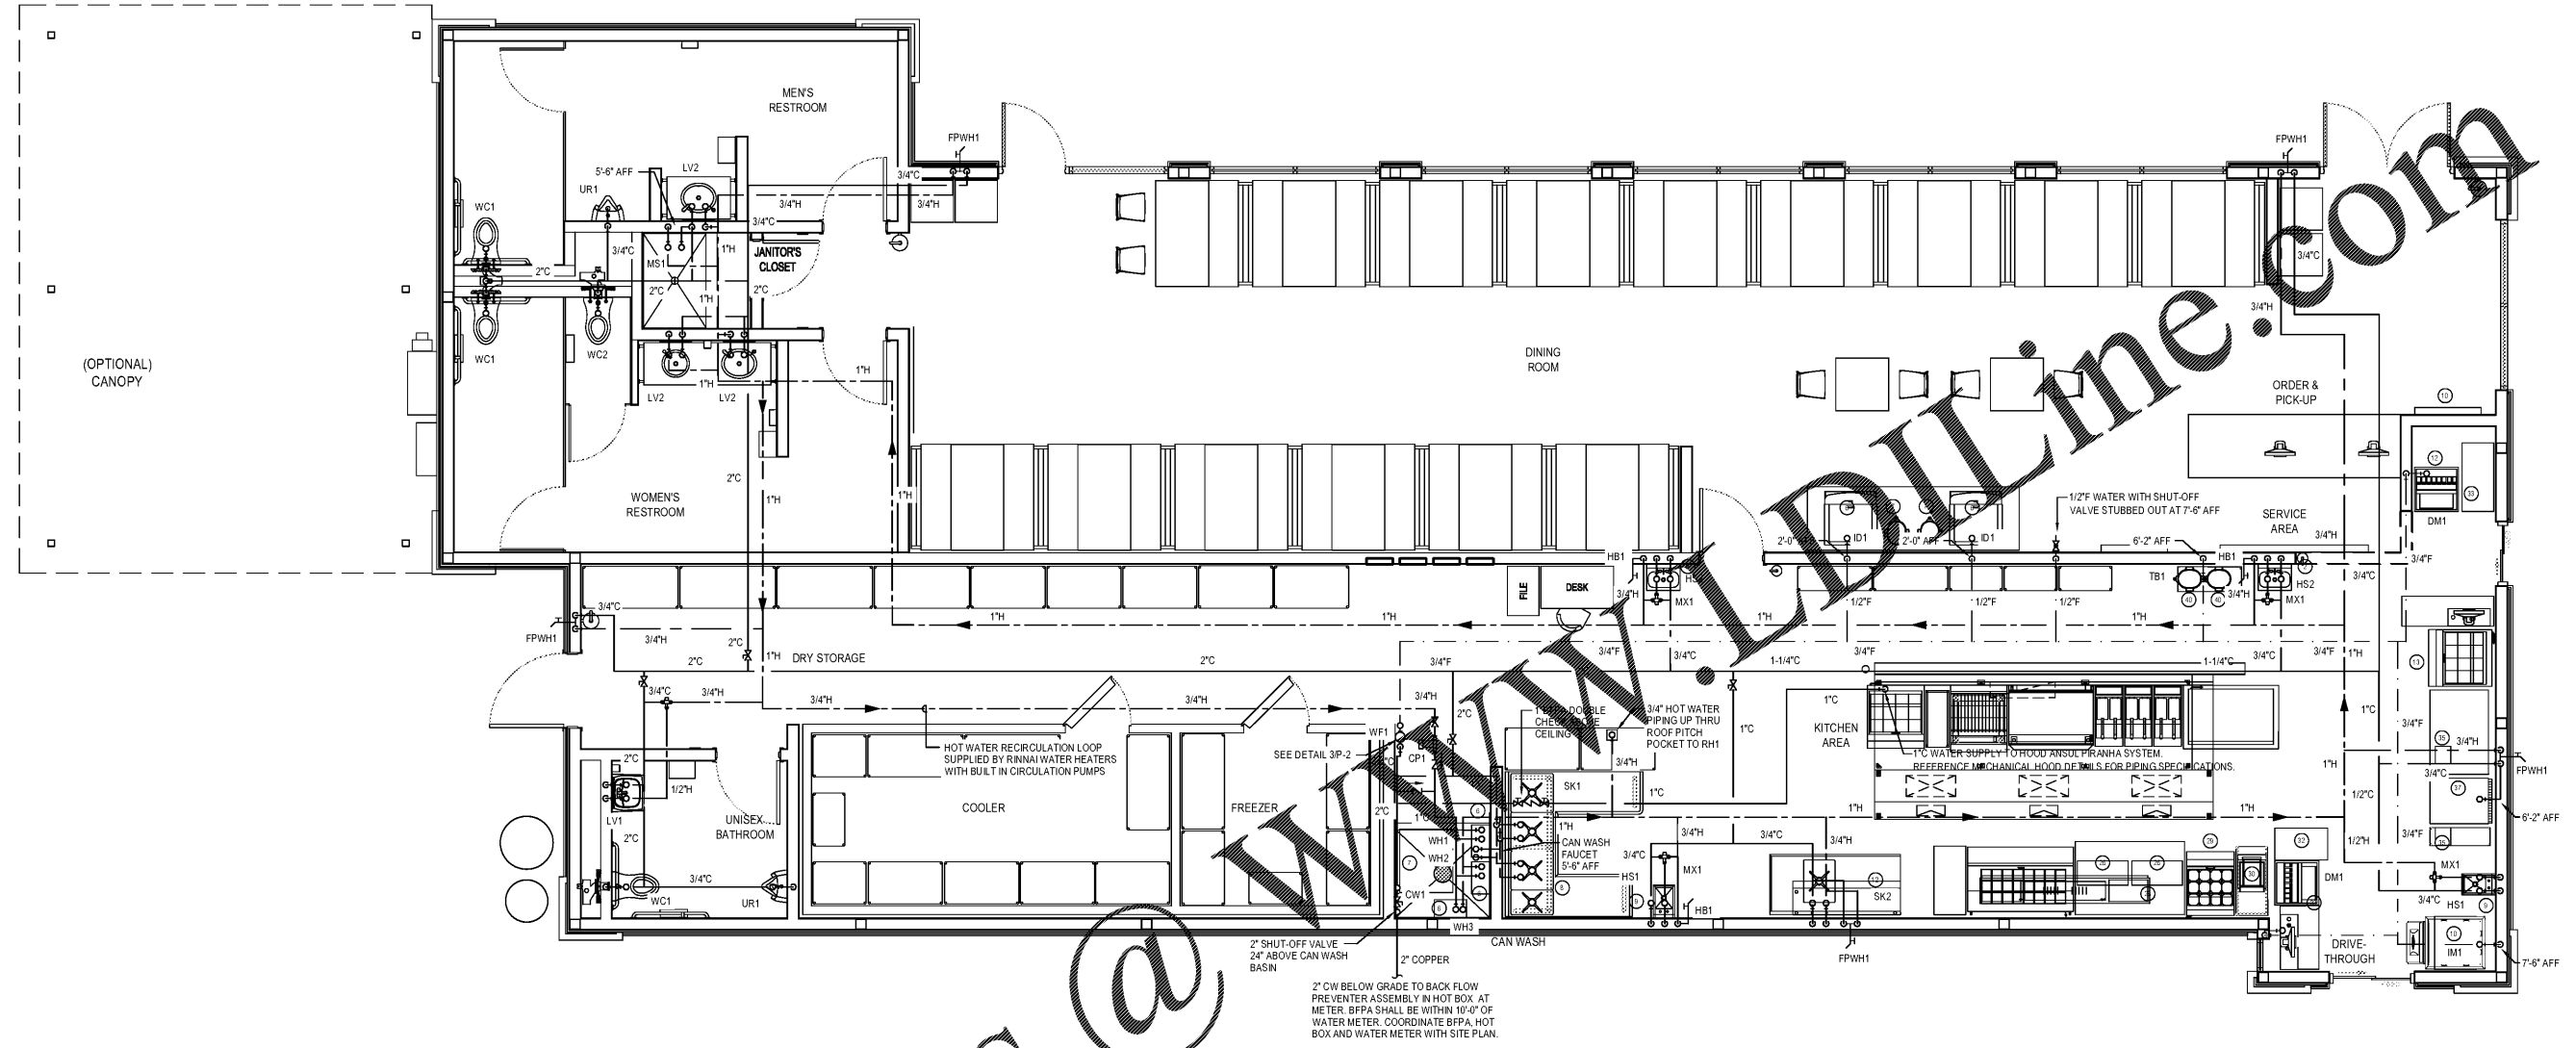

1 WATER PIPING PLAN
 P-5 SCALE: 1/4" = 1'-0"

Order Plans @

WATERVILLE ONLINE.COM