


Summey Engineering Associates, PLLC
 Engineering - Land Planning - Consulting
 PO Box 568
 Asheville, NC 27204
 Phone: 336-528-0902 Fax: 336-528-0922
 Email: mack@summey.com
 NC Professional Engineering Firm License No. P-0336

No.	Date	Description	By

MECHANICAL ROOF PLAN
COOK-OUT RESTAURANTS
 4145 S. MEMORIAL DRIVE
 PITT COUNTY - WINTERVILLE TOWNSHIP - NORTH CAROLINA

Scale	AS NOTED
Date	APRIL 2019
Drawn By	ECB
Checked By	HWSJ
Job No.	E-54150

Sheet No.
M-6
 6 of 9

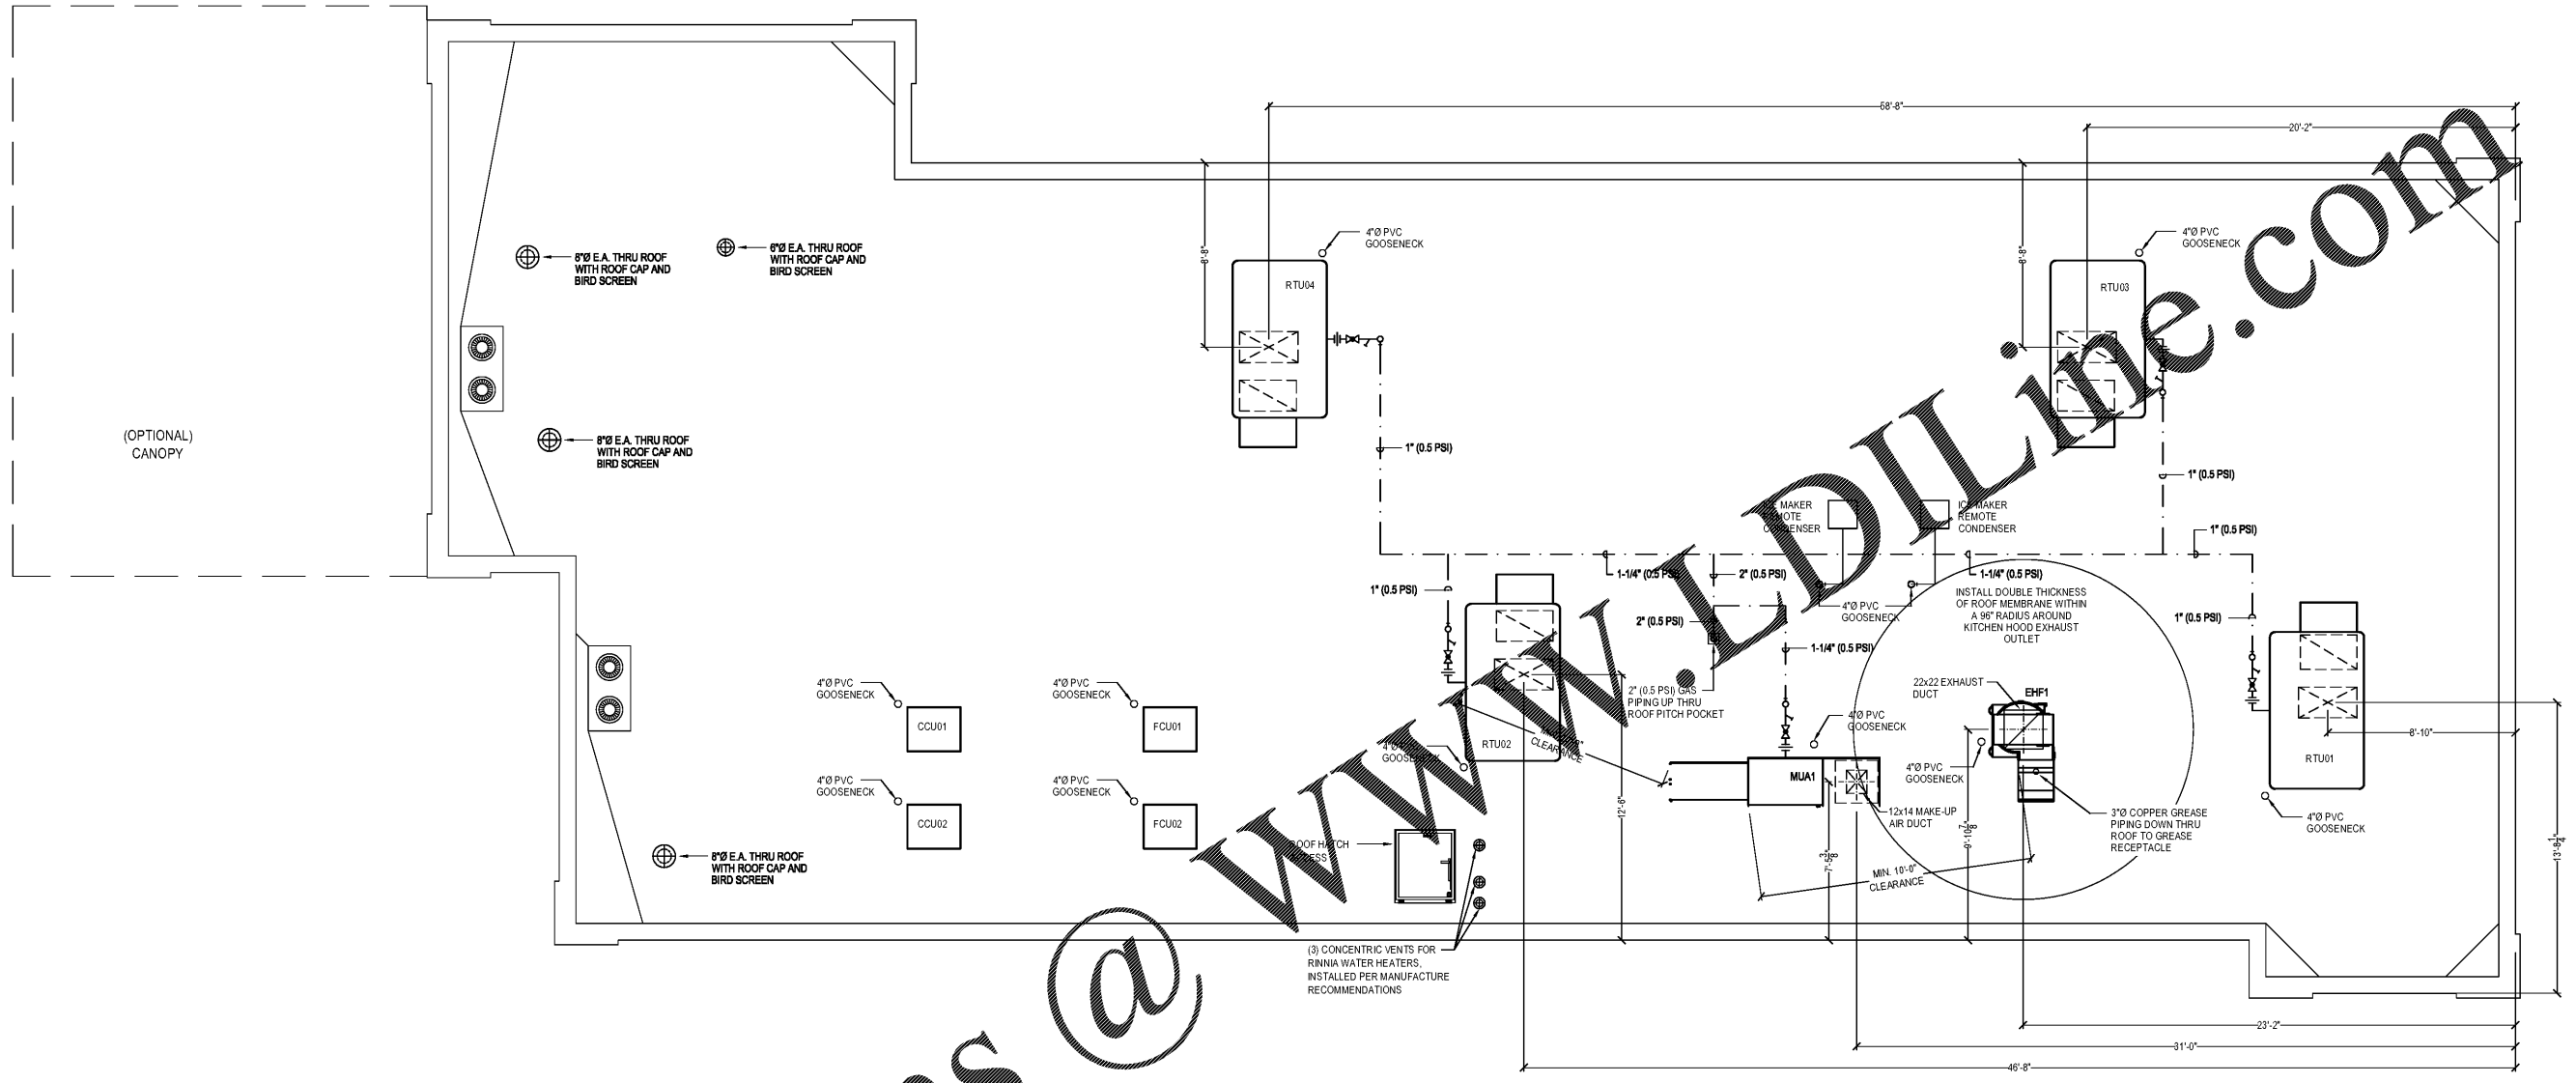

1 MECHANICAL ROOF PLAN
 M-6 SCALE: 1/4" = 1'-0"

Order Plans @

WWW.DIILINE.COM