




Summary Engineering Associates, PLLC
 Engineering - Land Planning - Consulting
 PO Box 568
 Asheville, NC 27204
 Phone: 336-328-0902 Fax: 336-328-0922
 E-mail: mack@summary.com
 NC Professional Engineering Firm License No. P-0336

No.	Date	Description

ELECTRICAL PLAN
COOK-OUT RESTAURANTS
 4145 S. MEMORIAL DRIVE
 PITT COUNTY - WINTERVILLE TOWNSHIP - NORTH CAROLINA

Scale	Date	Drawn By	Checked By	Job No.
AS NOTED	APRIL 2019	ECB	HWSJ	E-5450

Sheet No. **E-4**
 4 of 6

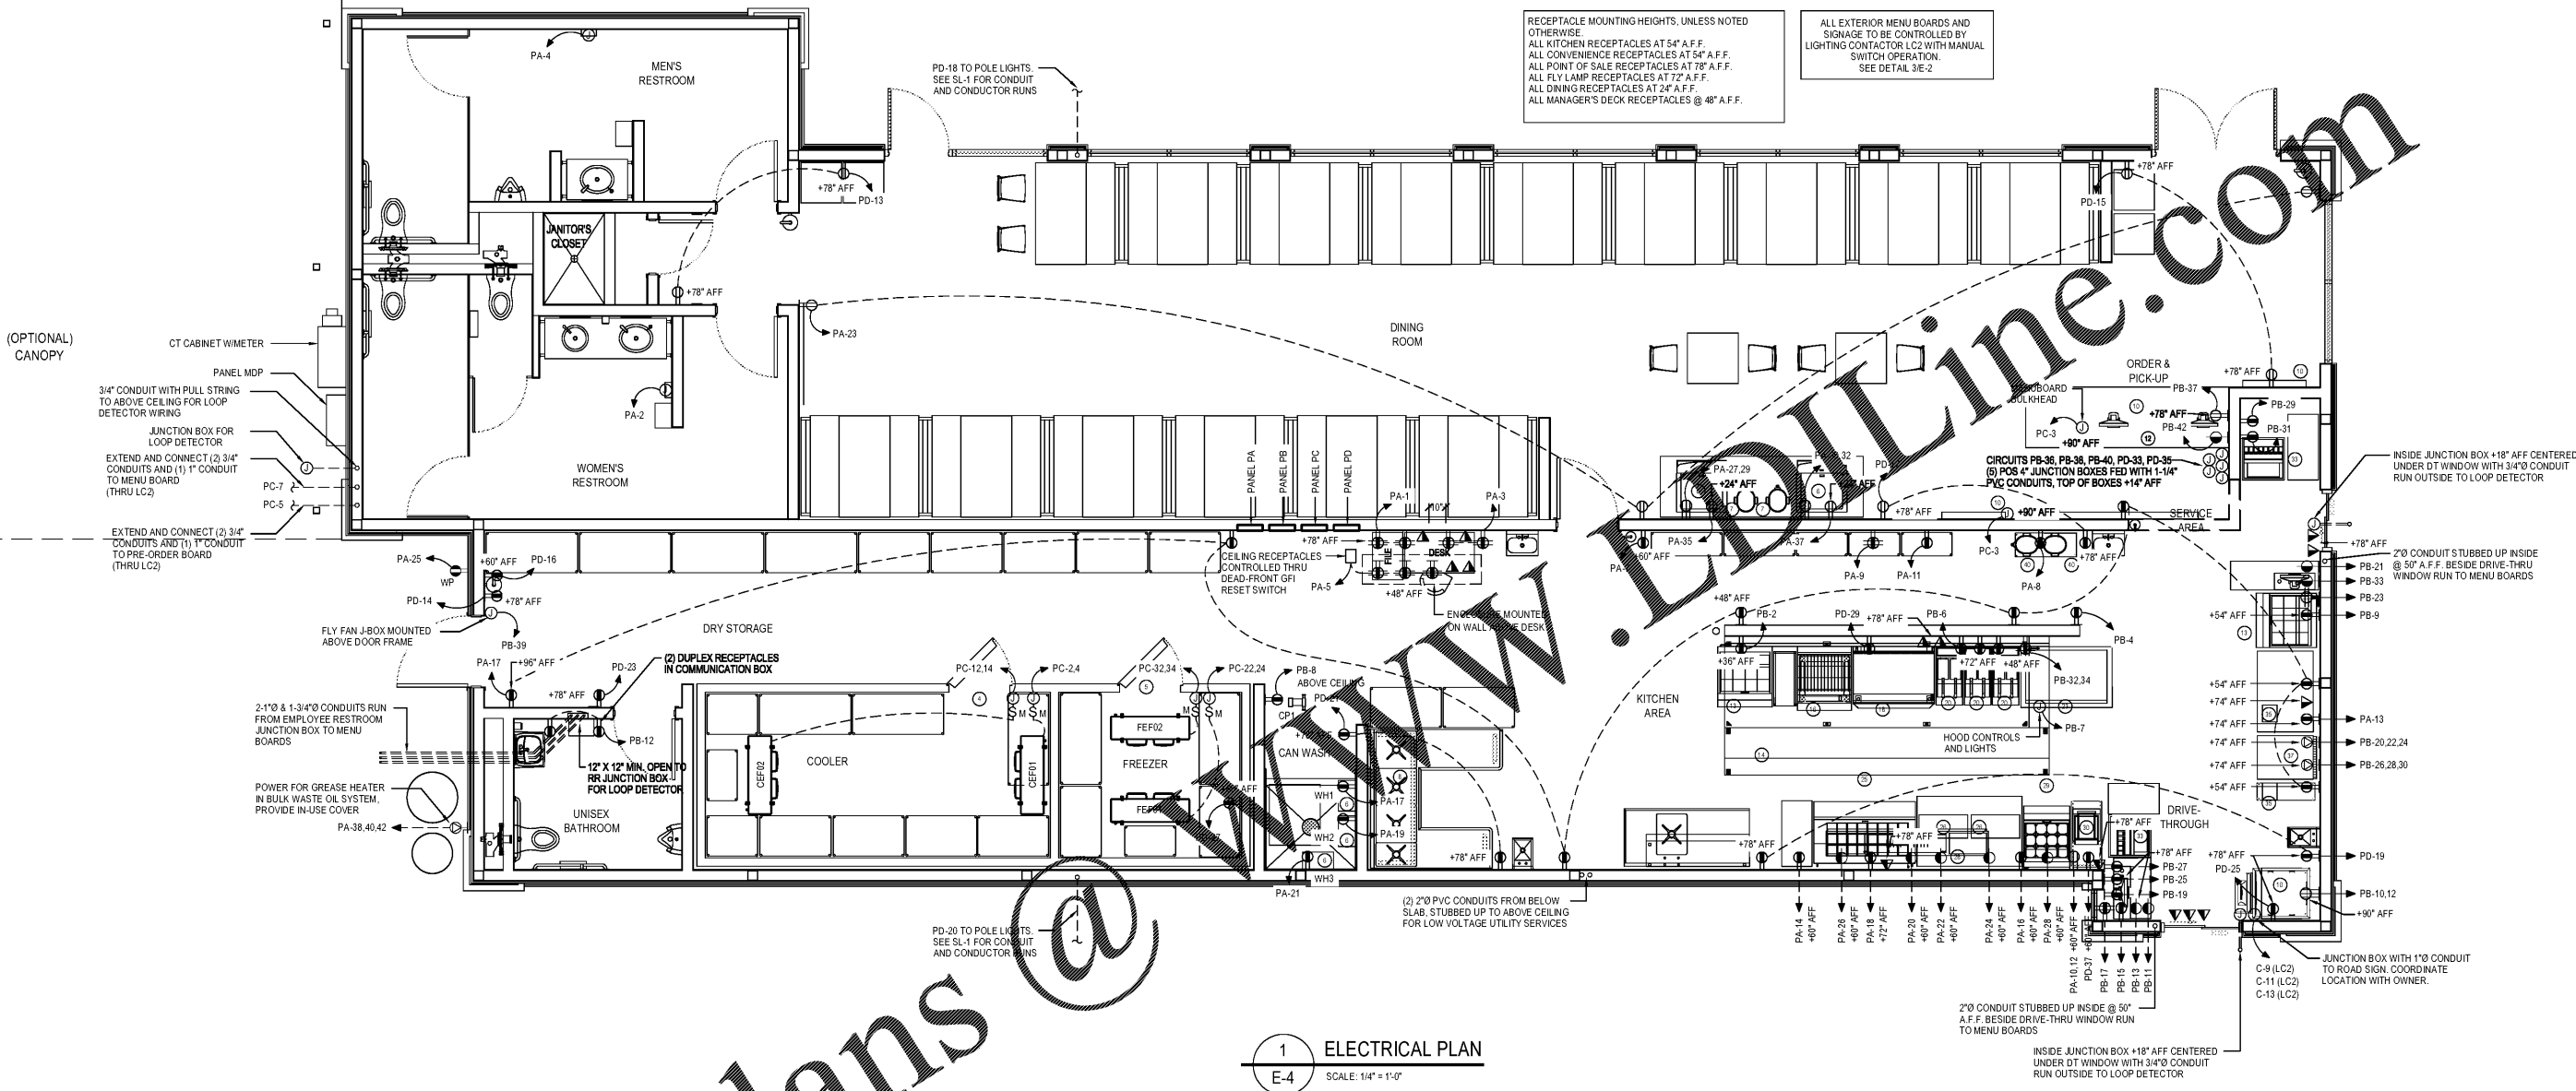

1 ELECTRICAL PLAN
 E-4 SCALE: 1/4" = 1'-0"

KITCHEN EQUIPMENT SCHEDULE											
NO.	DESCRIPTION	MANUFACTURER OR EQUAL	MODEL NO. OR EQUAL	NO.	DESCRIPTION	MANUFACTURER OR EQUAL	MODEL NO. OR EQUAL	NO.	DESCRIPTION	MANUFACTURER OR EQUAL	MODEL NO. OR EQUAL
1	DRY STORAGE	METRO		15	1'-1" X 2'-0" STAINLESS STEEL CHAR GRILL WORK TABLE	TITAN STAINLESS	CUSTOM BUILT	29	TWO (2) DRAWER REFRIG. SANDWICH / SALAD PREP. UNIT (ON CASTERS)	DELFIELD	D4427N-12M
2	WALL MOUNTED HAND SINK	TITAN STAINLESS		16	CHAR GRILL	SOUTHBEND	P32N-CC	30	QUESADILLA GRILL	WELLS	
3	WALK-IN COOLER (W/ RACKS/WALLS)	METRO		17	CHAR GRILL STAND	TITAN STAINLESS	CUSTOM BUILT	31	1'-0" X 3'-3" STAINLESS STEEL WORK TABLE FOR QUESADILLA GRILL	TITAN STAINLESS	CUSTOM BUILT
4	WALK-IN FREEZER	THERMALRITE		18	GRIDDLE	SOUTHBEND	HDG-48	32	1'-0" X 2'-0" STAINLESS STEEL PICK-UP WORK TABLE	TITAN STAINLESS	CUSTOM BUILT
5	TANKLESS WATER HEATER	RINNAI	RUR98i	19	GRIDDLE STAND	TITAN STAINLESS	CUSTOM BUILT	33	CARBONATED BEVERAGE MACHINE (WITH ICE BIN)	COKE DISTRIBUTOR	
6	COFFIN WASH AREA			20	40-50 LB. FRYER (ON CASTERS)	PITCO	SG14	34	STAINLESS STEEL WORK TABLE (REGISTER TABLE)	TITAN STAINLESS	CUSTOM BUILT
7	FOUR (4) COMPARTMENT SINK	TITAN STAINLESS		21	STAINLESS STEEL WHEEL STOP GUARDRAIL	CUSTOM BUILT		35	RAZZLE DRINK MIXER	RAZZLE	
8	WALL-MOUNTED HAND SINK	TITAN STAINLESS	SIS-1012-CUSTOM	22	3'-0" X 4'-0" STAINLESS STEEL FRY WORK TABLE	TITAN STAINLESS	CUSTOM BUILT	36	10-1/4" X 2'-0" STAINLESS STEEL MIXER WORK TABLE	TITAN STAINLESS	CUSTOM BUILT
9	ICE MAKER	MANITOWOC	RFS-2378C	23	FOUR (4) DRAWER UNDER COUNTER REFRIG. (ON CASTERS)	DELFIELD	UCD48N	37	SOFT SERVER FREEZER (ON CASTERS)	TAYLOR	772
10	UPRIGHT ICE BIN	KLOPPENBERG	905-SBB	24	1'-0" X 3'-3" STAINLESS STEEL WORK TABLE	TITAN STAINLESS	CUSTOM BUILT	38	4'-0" X 2'-0" STAINLESS STEEL SHAKE WORK TABLE	TITAN STAINLESS	CUSTOM BUILT
11	VEGETABLE PREP SINK	TITAN STAINLESS		25	TWO (2) DOOR REFRIG. SANDWICH / SALAD PREP. UNIT (ON CASTERS)	BEVERAGE-AIR	SP60-24M	39	STAINLESS STEEL WORK TABLE (REGISTER TABLE)	TITAN STAINLESS	CUSTOM BUILT
12	TWO (2) DRAWER REFRIG. SANDWICH / SALAD PREP. UNIT (ON CASTERS)	DELFIELD	D4427N-12M	26	STEAM TABLE HOT FOOD WELLS	APW WYOTT	HPW-23	40	TEA DISPENSERS	BUNN	
13	HOOD WITH EXHAUST AND ANSUL SYSTEM (16 FT)	CAPTIVE AIRE	5424ND-BR	27	STAINLESS STEEL STEAM TABLE (ON CASTERS)	TITAN STAINLESS	CUSTOM BUILT	41	1'-2" X 3'-0" STAINLESS STEEL TEA WORK TABLE	TITAN STAINLESS	CUSTOM BUILT
14				28	BUN WARMER	HENRY PENNY	BW-8				

DINING ROOM FURNITURE SCHEDULE											
NO.	DESCRIPTION	MANUFACTURER OR EQUAL	MODEL NO. OR EQUAL	NO.	DESCRIPTION	MANUFACTURER OR EQUAL	MODEL NO. OR EQUAL	NO.	DESCRIPTION	MANUFACTURER OR EQUAL	MODEL NO. OR EQUAL
1	JANITOR CLOSET (SITE BUILT MOP SINK)	CUSTOM BUILT		5	TRASH CAN	TITAN STAINLESS		9	3'-0" SEMI-CIRCULAR WASHFOUNTAIN	BRADLEY	WF2703
2	2'-0" X 5'-0" TABLE (BOOTH SEATING EACH SIDE)			6	CARBONATED BEVERAGE MACHINE (WITH ICE MAKER)	COKE DISTRIBUTOR	WF2703	10	MENU SIGNAGE	CUSTOM BUILT	CUSTOM BUILT
3	2'-0" X 2'-0" ADA ACCESSIBLE TABLE			7	TEA DISPENSER	BUNN		11	3'-0" X 9'-0" REGISTER TABLE	TITAN STAINLESS	CUSTOM BUILT
4	60" WIDE MIRROR			8	(OPTIONAL) 3'-0" X 10'-0" SELF-SERVE TABLE	TITAN STAINLESS	CUSTOM BUILT	12	(OPTIONAL) CARBONATED BEVERAGE MACHINE (WITH ICE BIN)	COKE DISTRIBUTOR	

Summary Engineering Associates, PLLC
 4145 S. Memorial Drive
 Asheville, NC 27204
 Phone: 336-328-0902
 Fax: 336-328-0922
 E-mail: mack@summary.com