



Order Plans @

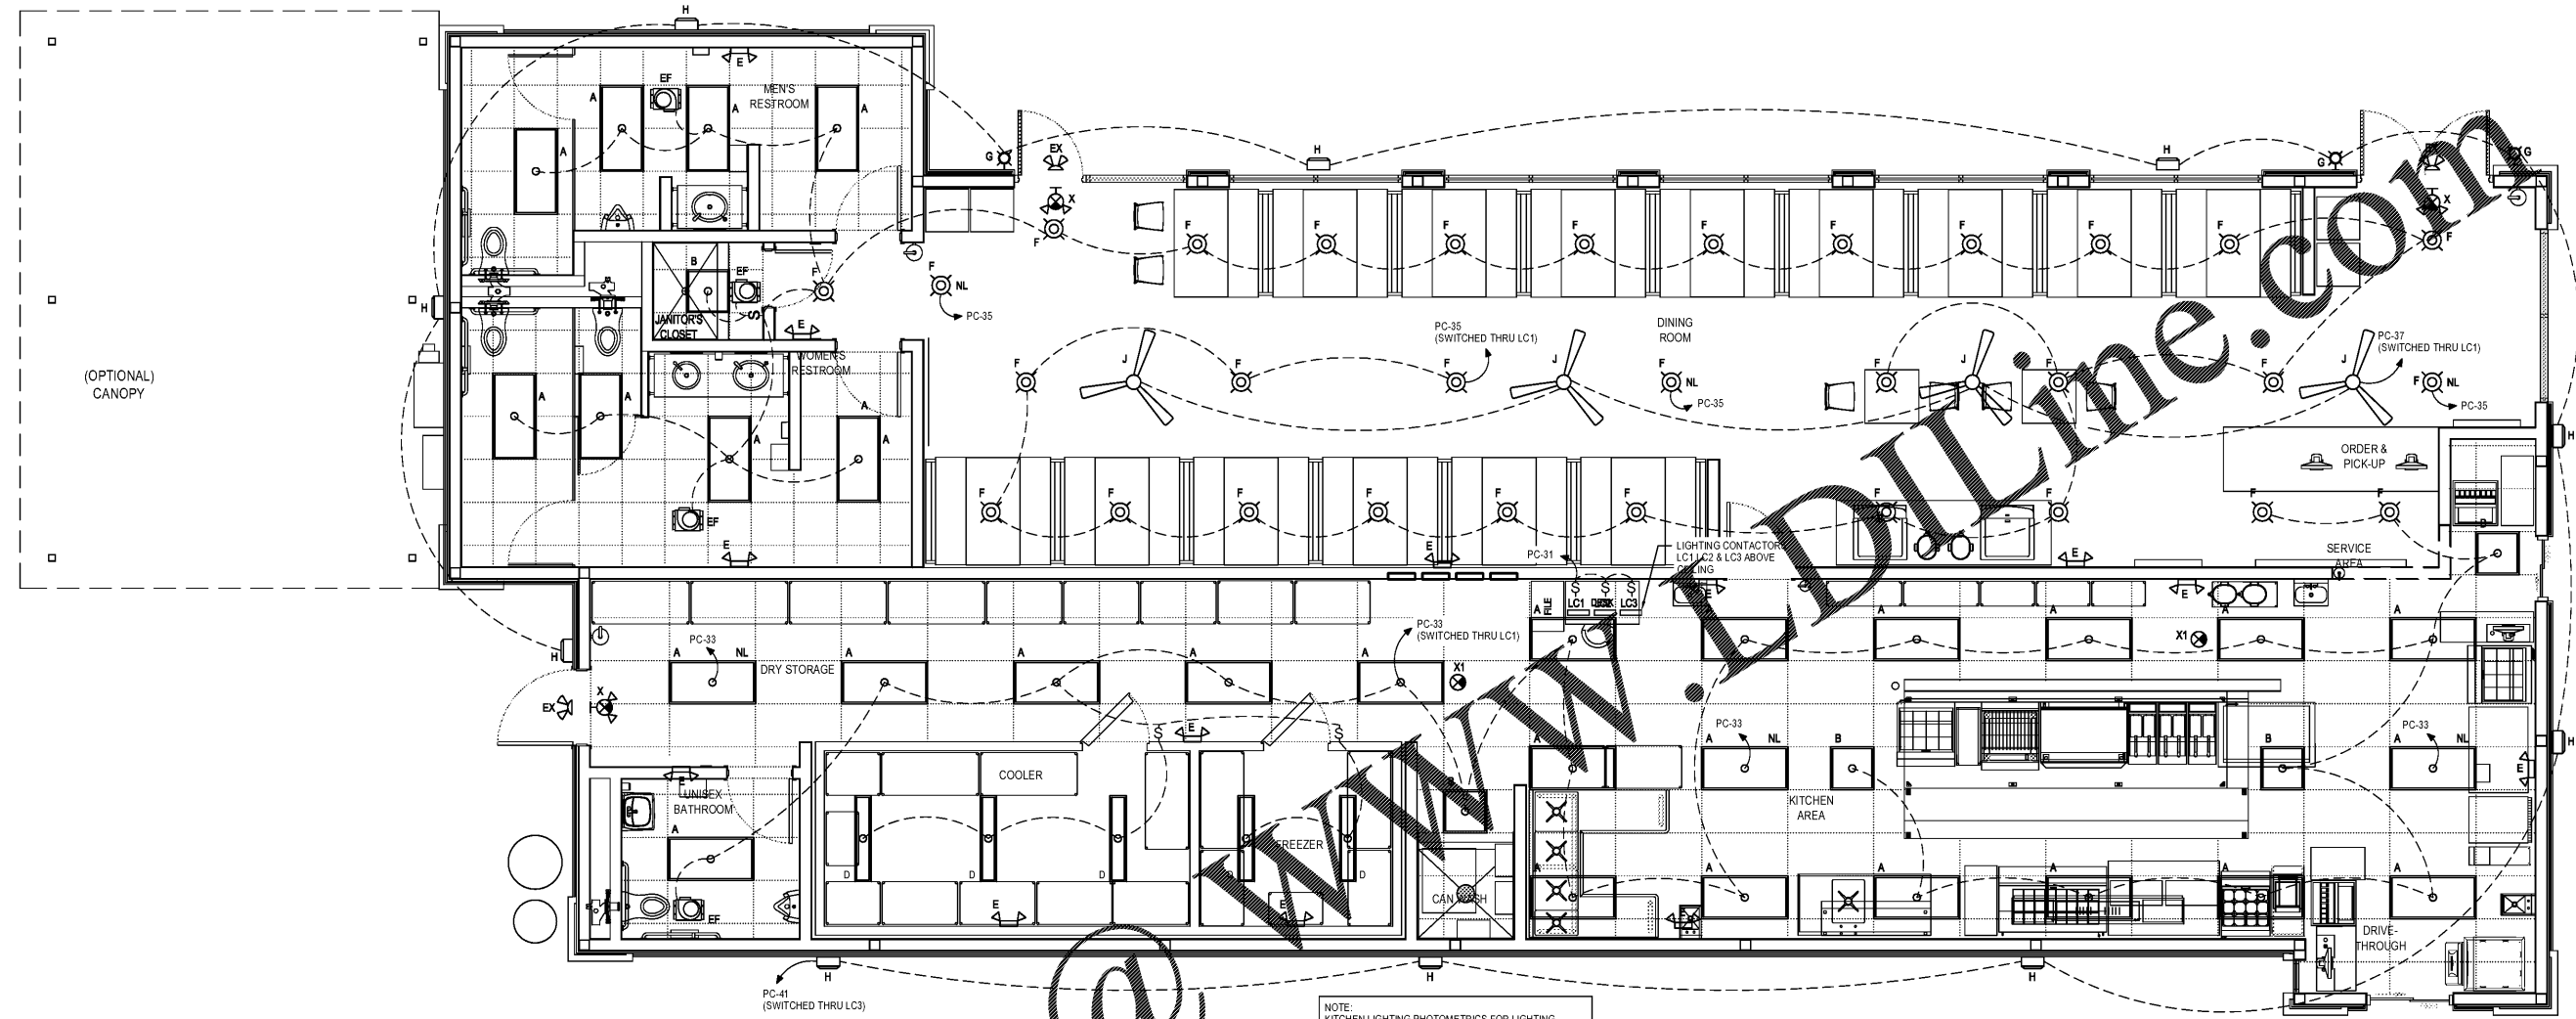

1 LIGHTING PLAN  
E-5 SCALE: 1/4" = 1'-0"

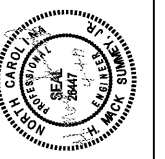

Summey Engineering Associates, PLLC  
Engineering - Land Planning - Consulting  
PO Box 568  
Asheboro, NC 27204  
Phone: 336-528-0922 Fax: 336-528-0922  
E-mail: mack@summey.com  
NC Professional Engineering Firm License No. P-0336

No.	Date	Description	By

LIGHTING PLAN  
**COOK-OUT RESTAURANTS**  
4145 S. MEMORIAL DRIVE  
PITT COUNTY - WINTERVILLE TOWNSHIP - NORTH CAROLINA

Scale:	AS NOTED
Date:	APRIL 2019
Drawn By:	ECB
Checked By:	HWSJ
Job No.:	E-5450

Sheet No.  
**E-5**  
5 of 6