

ISSUE	DATE	DESCRIPTION
-	04/01/19	PERMIT / BID SET

PROJECT INFORMATION	
PROJECT NO:	V2W.26122
DATE:	04/01/2019
SCALE:	AS NOTED
DRAWN BY:	A. KLINKE
CHECKED BY:	V. ALVAREZ

SHEET TITLE	
REFLECTED CEILING PLAN, CEILING & LIGHTING DETAILS	
SHEET NUMBER	


- CEILING PLAN NOTES** REFER TO T-001 FOR GENERAL NOTES.
- ALL CEILING HEIGHTS REFERENCED ARE ABOVE RELATIVE FINISHED FLOOR ELEVATION (A.F.F.)
 - ALL CEILING MOUNTED LIGHT FIXTURES TO BE CENTERED ON DRYWALL CEILING AND/OR ACOUSTICAL CEILING TILE AS SHOWN; CENTER ALL SUSPENDED LIGHT FIXTURES AS SHOWN ON PLAN.
 - LOCATE CEILING GRID IN EACH ROOM/ AREA AS SHOWN.
 - REFER ELECTRICAL DRAWINGS FOR LIGHT FIXTURE SCHEDULE.
 - GENERAL CONTRACTOR TO COORDINATE WITH ALL OTHER TRADES TO MINIMIZE UTILITY CONFLICTS AND TO ENSURE COMPLIANCE WITH ALL FIRE MARSHALL REQUIREMENTS.
 - LIGHT FIXTURES SHOWN ON CEILING TILE ONLY ARE TO BE MOUNTED ON THE CENTER OF THE TILE, U.N.O.
 - PATCH, REPAIR, OR REPLACE ALL CEILING IN HAND; PREP ALL CEILING FOR NEW FINISHES/ PAINT.
 - ALL DIMENSIONS ARE FINISH DIMENSIONS.
 - LOCATION AND QUALITY OF ALL EXISTING LIGHTING AND DIFFUSERS SHALL BE VERIFIED IN FIELD BY GENERAL CONTRACTOR.

- KEYNOTES**
- EX=EXISTING TO REMAIN
R=EXISTING TO BE RELOCATED
- NEW GRID AND TILE. SEE PLAN FOR HEIGHTS.
 - INFILLET PATCH GRID AND TILE AS REQUIRED IN THIS AREA TO MATCH EXISTING.
 - EXISTING GRID AND TILE TO REMAIN. REPLACE TILE AS REQUIRED.
 - NEW TRACK LIGHTING AND TRACK HEADS.
 - NEW PENDANT LIGHT FIXTURE CENTERED OVER TABLE.
 - NEW LIGHT FIXTURE.
 - RELOCATED LIGHT FIXTURE.
 - NEW DIFFUSER, G.C. TO MATCH EXISTING COLOR AND STYLE.
 - BOTTOM OF HEADER @ +8'-0" A.F.F.
 - NEW SECURITY SHUTTER BY OTHERS TO MATCH EXISTING. INSTALL PER MANUFACTURER INSTRUCTIONS.
 - EXISTING SECURITY SHUTTERS TO REMAIN.
 - EXISTING DIFFUSER TO BE RELOCATED AS REQUIRED.


- CEILING FINISH NOTE**
- REFER TO FINISH SCHEDULES AND DETAILS ON SHEET A-131 FOR CEILING FINISHES.
 - DIFFUSERS, GRILLES, SPRINKLERS AND SPEAKERS IN FRONT OF THE HOUSE CEILING SHALL BE PAINTED TO MATCH CEILING (WHITE)

RCP LEGEND NOT ALL SYMBOLS MAY BE USED.


	FURNITURE BELOW PENDANT LIGHT FIXTURE
	CEILING FINISH MATERIAL (SEE FINISH PLAN) HEIGHT ABOVE FINISHED FLOOR (A.F.F.)
	EXIT SIGN LOCATION OF EXIT TEXT
	EMERGENCY FLOOD LIGHT
	RECESSED DOWNLIGHT (CEILING MOUNT)
	16" PENDANT LIGHT FIXTURE: MOUNT BOTTOM OF FIXTURE @ 65" A.F.F. - F8
	2x2 TROFFER LIGHT FIXTURE - F6
	2x4 TROFFER LIGHT FIXTURE
	ADJUSTABLE TRACK HEAD MOUNTED TO BASIC TRACK - F4A
	SUPPLY DIFFUSER
	RETURN

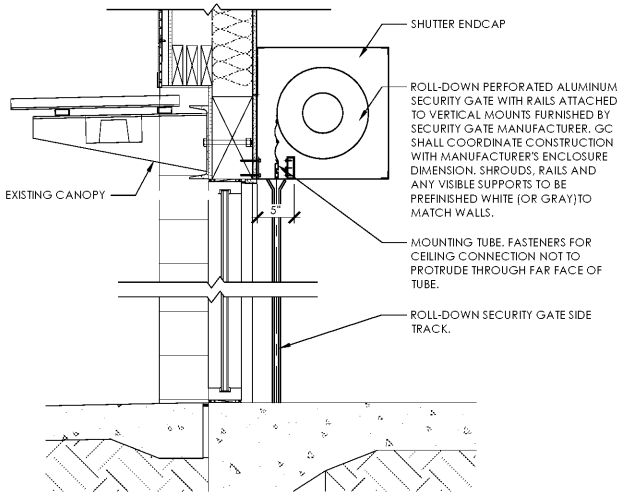


7 STOREFRONT SECTION - SECURITY GRILLE BY OTHERS
SCALE: 1" = 1'-0"

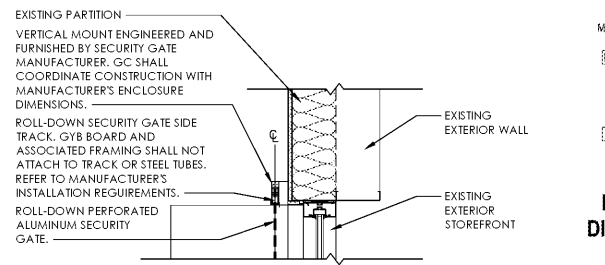


6 SECURITY GRILLE PLAN DETAIL @ JAMB BY OTHERS
SCALE: 1" = 1'-0"

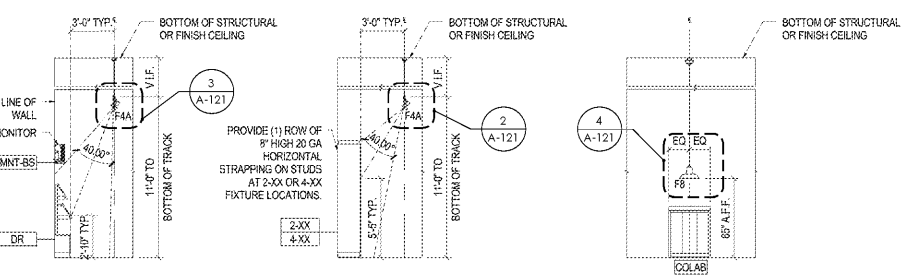


5 TYPICAL LIGHTING DETAILS - DIAGRAMS
SCALE: NTS

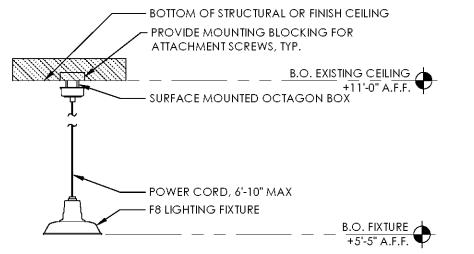


4 TYP. PENDANT LIGHT HANGING DETAIL
SCALE: 1/2" = 1'-0"

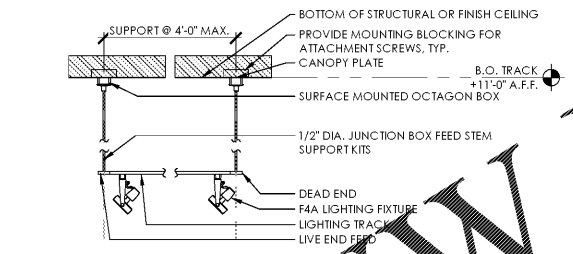

3 TYP. TRACK LIGHTING HANGING DETAIL
SCALE: 1/2" = 1'-0"

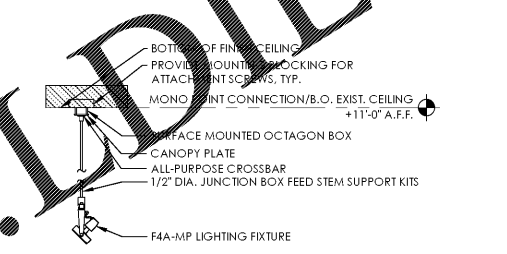

2 TYP. MONO-POINT HANGING DETAIL
SCALE: 1/2" = 1'-0"

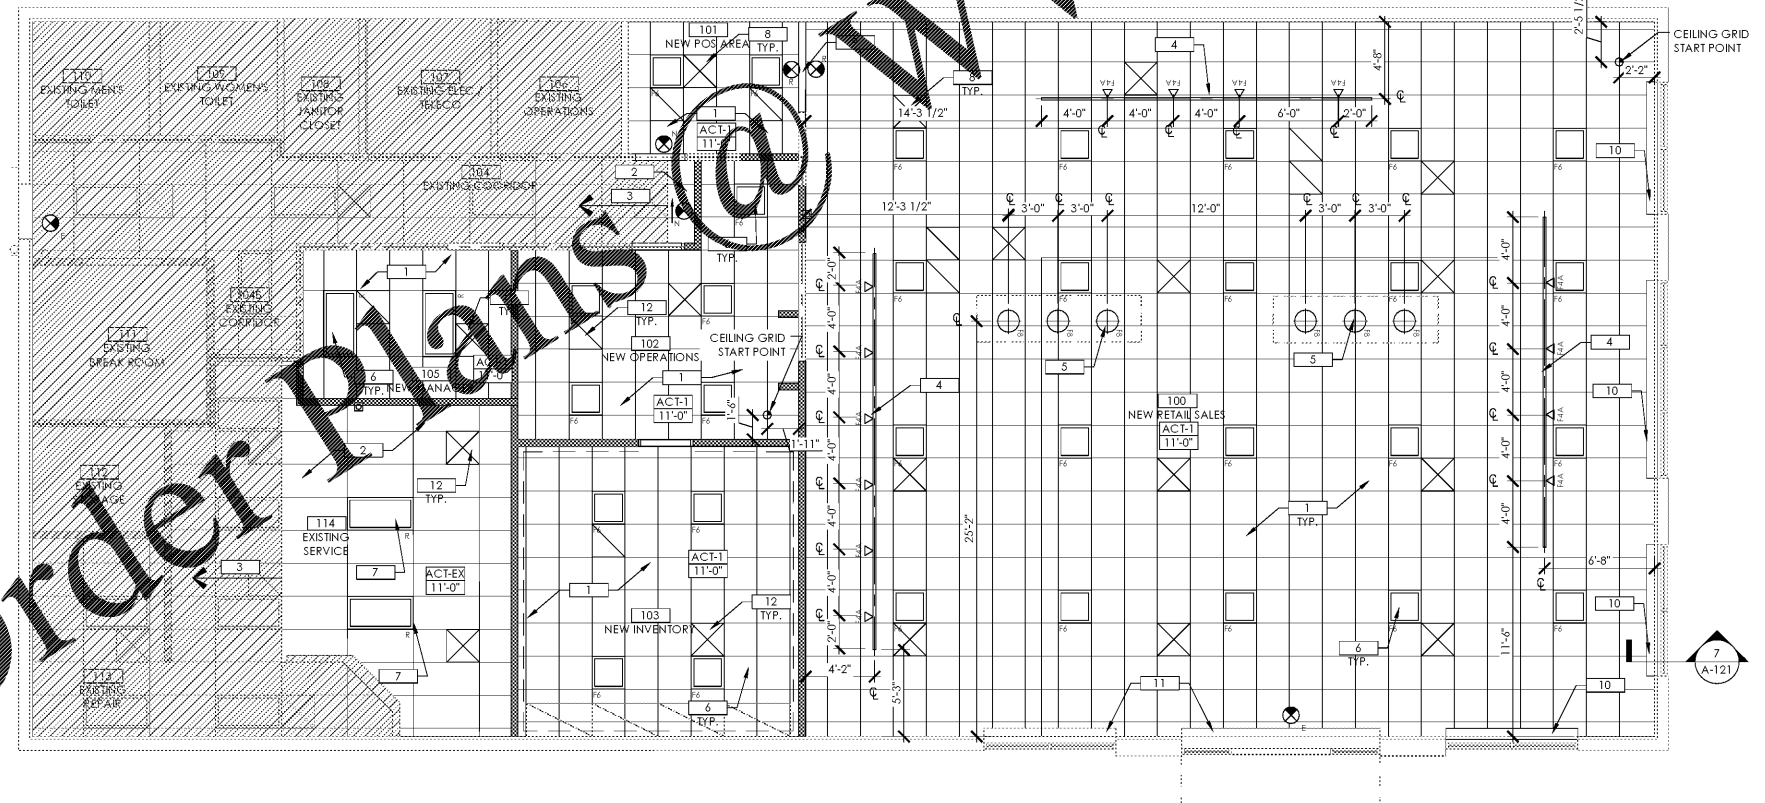

1 REFLECTED CEILING PLAN
SCALE: 3/16" = 1'-0"