



| REVISIONS | | |
|-----------|-------------|------|
| NUMBER | DESCRIPTION | DATE |
| | | |
| | | |
| | | |
| | | |
| | | |

| FIRE ALARM SYSTEM INPUT/OUTPUT MATRIX | SYSTEM OUTPUTS | | | | | | | | | | | | | | | | | | | | | | | |
|--|------------------------------------|--|--|--|--|--|--|--|--|--|--|--|--------------|--|--|--|--|--|--|--|------------------------------|--|--|--|
| | EACH INDICATION | | | | | | | | | | | | NOTIFICATION | | | | | | | | REQUIRED FIRE SAFETY CONTROL | | | |
| 1 | FIRE ALARM SYSTEM AC POWER FAILURE | | | | | | | | | | | | | | | | | | | | | | | |
| 2 | FIRE ALARM SYSTEM LOW BATTERY | | | | | | | | | | | | | | | | | | | | | | | |
| 3 | OPEN CIRCUIT | | | | | | | | | | | | | | | | | | | | | | | |
| 4 | GROUND FAULT | | | | | | | | | | | | | | | | | | | | | | | |
| 5 | NOFF GAS APPLIANCE CIRCUIT SHORT | | | | | | | | | | | | | | | | | | | | | | | |
| 6 | BUILDING MANUAL PULL STATIONS | | | | | | | | | | | | | | | | | | | | | | | |
| 7 | AREA SMOKE DETECTORS | | | | | | | | | | | | | | | | | | | | | | | |
| 8 | HVAC AIR DUCT SMOKE DETECTORS | | | | | | | | | | | | | | | | | | | | | | | |

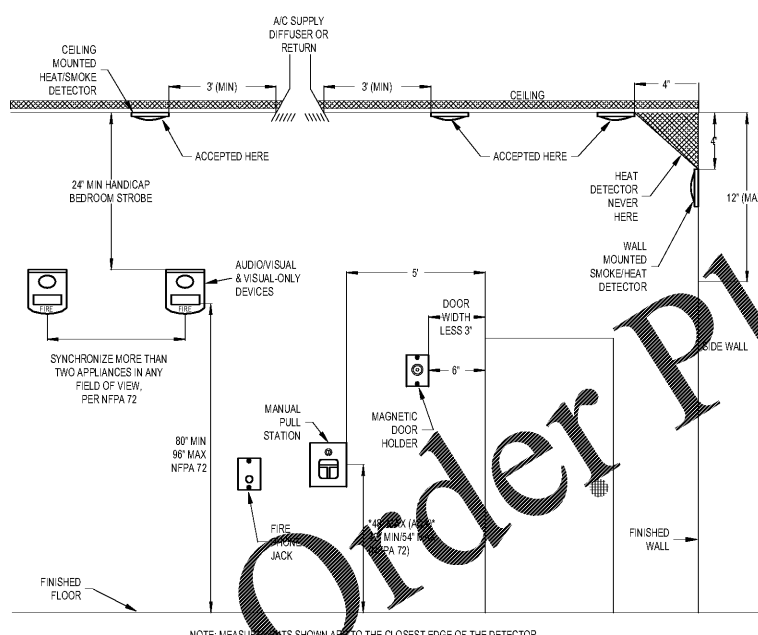

2 FIRE ALARM DEVICE MOUNTING HEIGHTS
SCALE: NONE

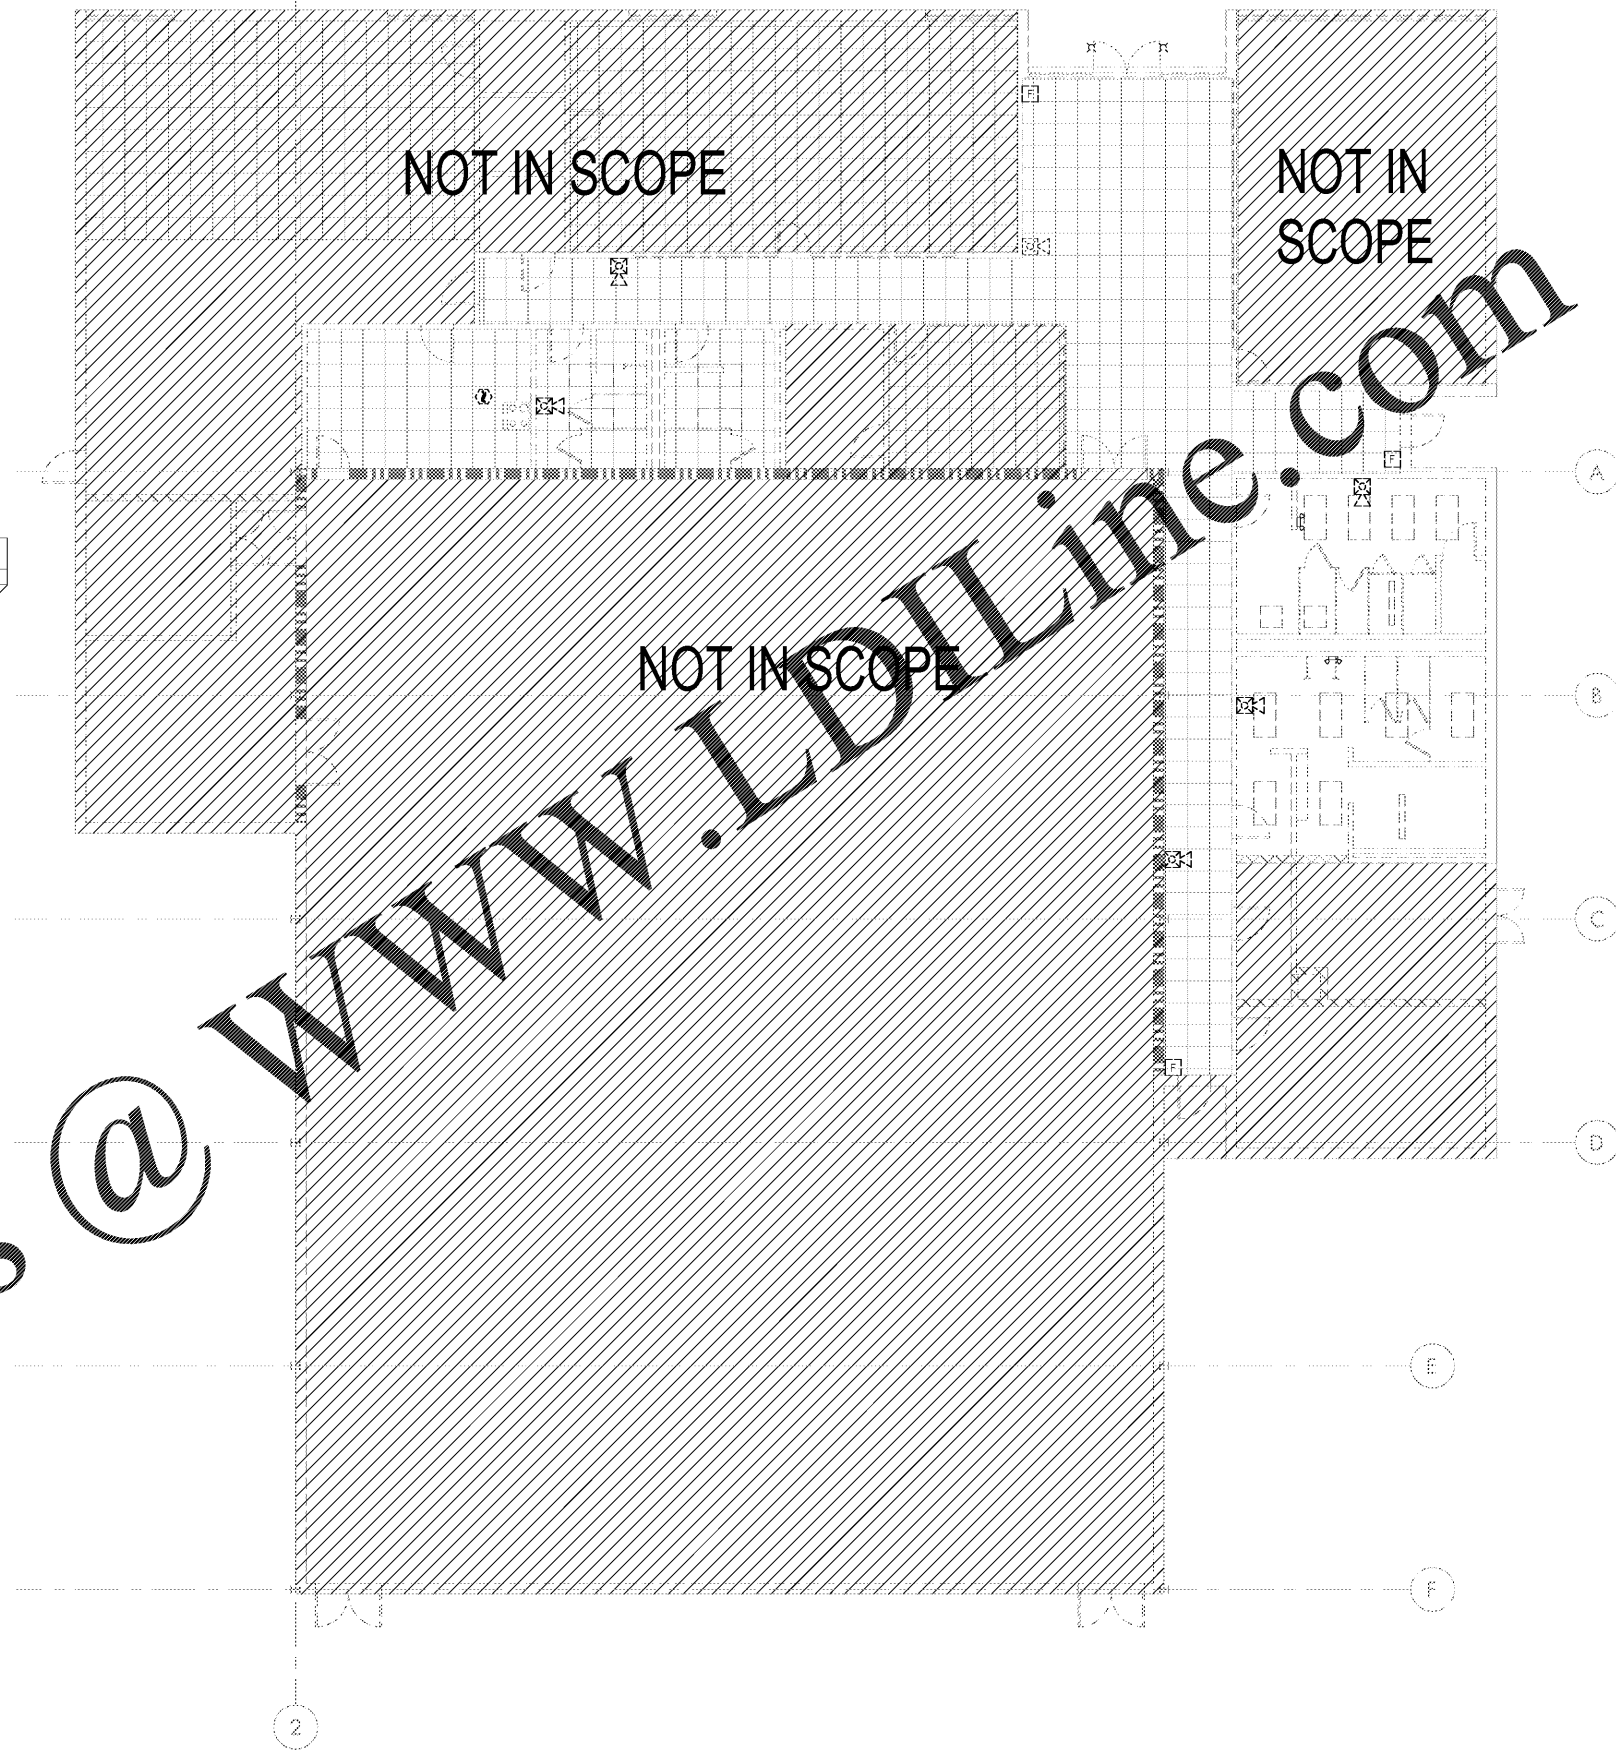

1 FINISHED FLOOR - DEMO FIRE ALARM
SCALE: 1/8" = 1'-0"