

 
 
 

 
 
 
 
 
 
 
 
 
 








REFLECTED CEILING PLAN SYMBOL LEGEND:

-  CEILING TYPE
CEILING HEIGHT-FROM FINISH FLOOR
-  2x4 LED LIGHT FIXTURE AS REQ'D. SEE ELEC. DWGS. FOR LENS TYPES.
-  CEILING MOUNTED PENDANT
-  CEILING STROBE
-  EXIT LIGHT-WALL MOUNTED. SEE ELEC. DWGS.
-  EXIT LIGHT-CEILING MOUNTED. SEE ELEC. DWGS.
-  SMOKE DETECTOR
VERIFY LOCATION W/ ELEC. DWGS.
-  HEAT DETECTOR
-  CARBON DIOXIDE DETECTOR
-  OCCUPANCY SENSOR
-  2x2 HVAC EXHAUST GRILLE-SEE MECH. DWGS.
-  2x2 HVAC RETURN GRILLE-SEE MECH. DWGS.
-  EXHAUST FAN-SEE MECH. DRAWINGS
-  LINEAR HVAC EXHAUST GRILLE-SEE MECH. DWGS.
-  LINEAR HVAC RETURN GRILLE-SEE MECH. DWGS.
-  CEILING MOUNTED FIRE ALARM DEVICE FOR REF. ONLY. SEE ELEC. DWGS. FOR LOCATIONS.
-  GYPSUM BOARD
-  SECURITY CAMERA - SEE ELECTRICAL FOR LOCATIONS

GENERAL NOTES:

- 1) ALL CEILING HEIGHTS ARE RELATIVE TO FINISH FLOOR ELEVATION UNLESS OTHERWISE NOTED.
- 2) SEE ELECTRICAL DRAWINGS FOR LOCATION OF ALL NEW EMERGENCY LIGHTS, EXIT SIGNS, HORNS, STROBES, & PULL STATIONS
- 3) ALL LIGHT FIXTURES, SPEAKERS, ETC. IN CEILING TYPES ARE TO HAVE WHITE TRIM OR COVERS U.N.O.
- 4) ALL CEILINGS ARE TO BE INSTALLED AS REQUIRED BY ASCE 7-05 CHAPTER 13 SEISMIC DESIGN FOR NONSTRUCTURAL COMPONENTS AND ANCHORED PER NCSBC SECTION 1621.

- CEILING TYPES:**
- TYPE #1: ACT-1: 24"x24"x5/8" REGULAR LAY-IN ACOUSTICAL CEILING - WHITE w/ WHITE ALUM. GRID
 - TYPE #2: ACT-2: 24"x24"x5/8" LAY-IN ACOUSTICAL CEILING (VINYL COATED) - WHITE w/ WHITE ALUM. GRID
 - TYPE #3: ACT-3: 48"x48"x1" REGULAR LAY-IN ACOUSTICAL CEILING - WHITE w/ WHITE ALUM. GRID
 - TYPE #4: GYPSUM BOARD CEILING-SOFFIT - PAINTED (PROVIDE MOIST. RESIST. GYP. BD & EPOXY PAINT AT ALL WET LOCATIONS U.N.O.)
 - TYPE #5: OPEN TO STRUCTURE - PAINTED

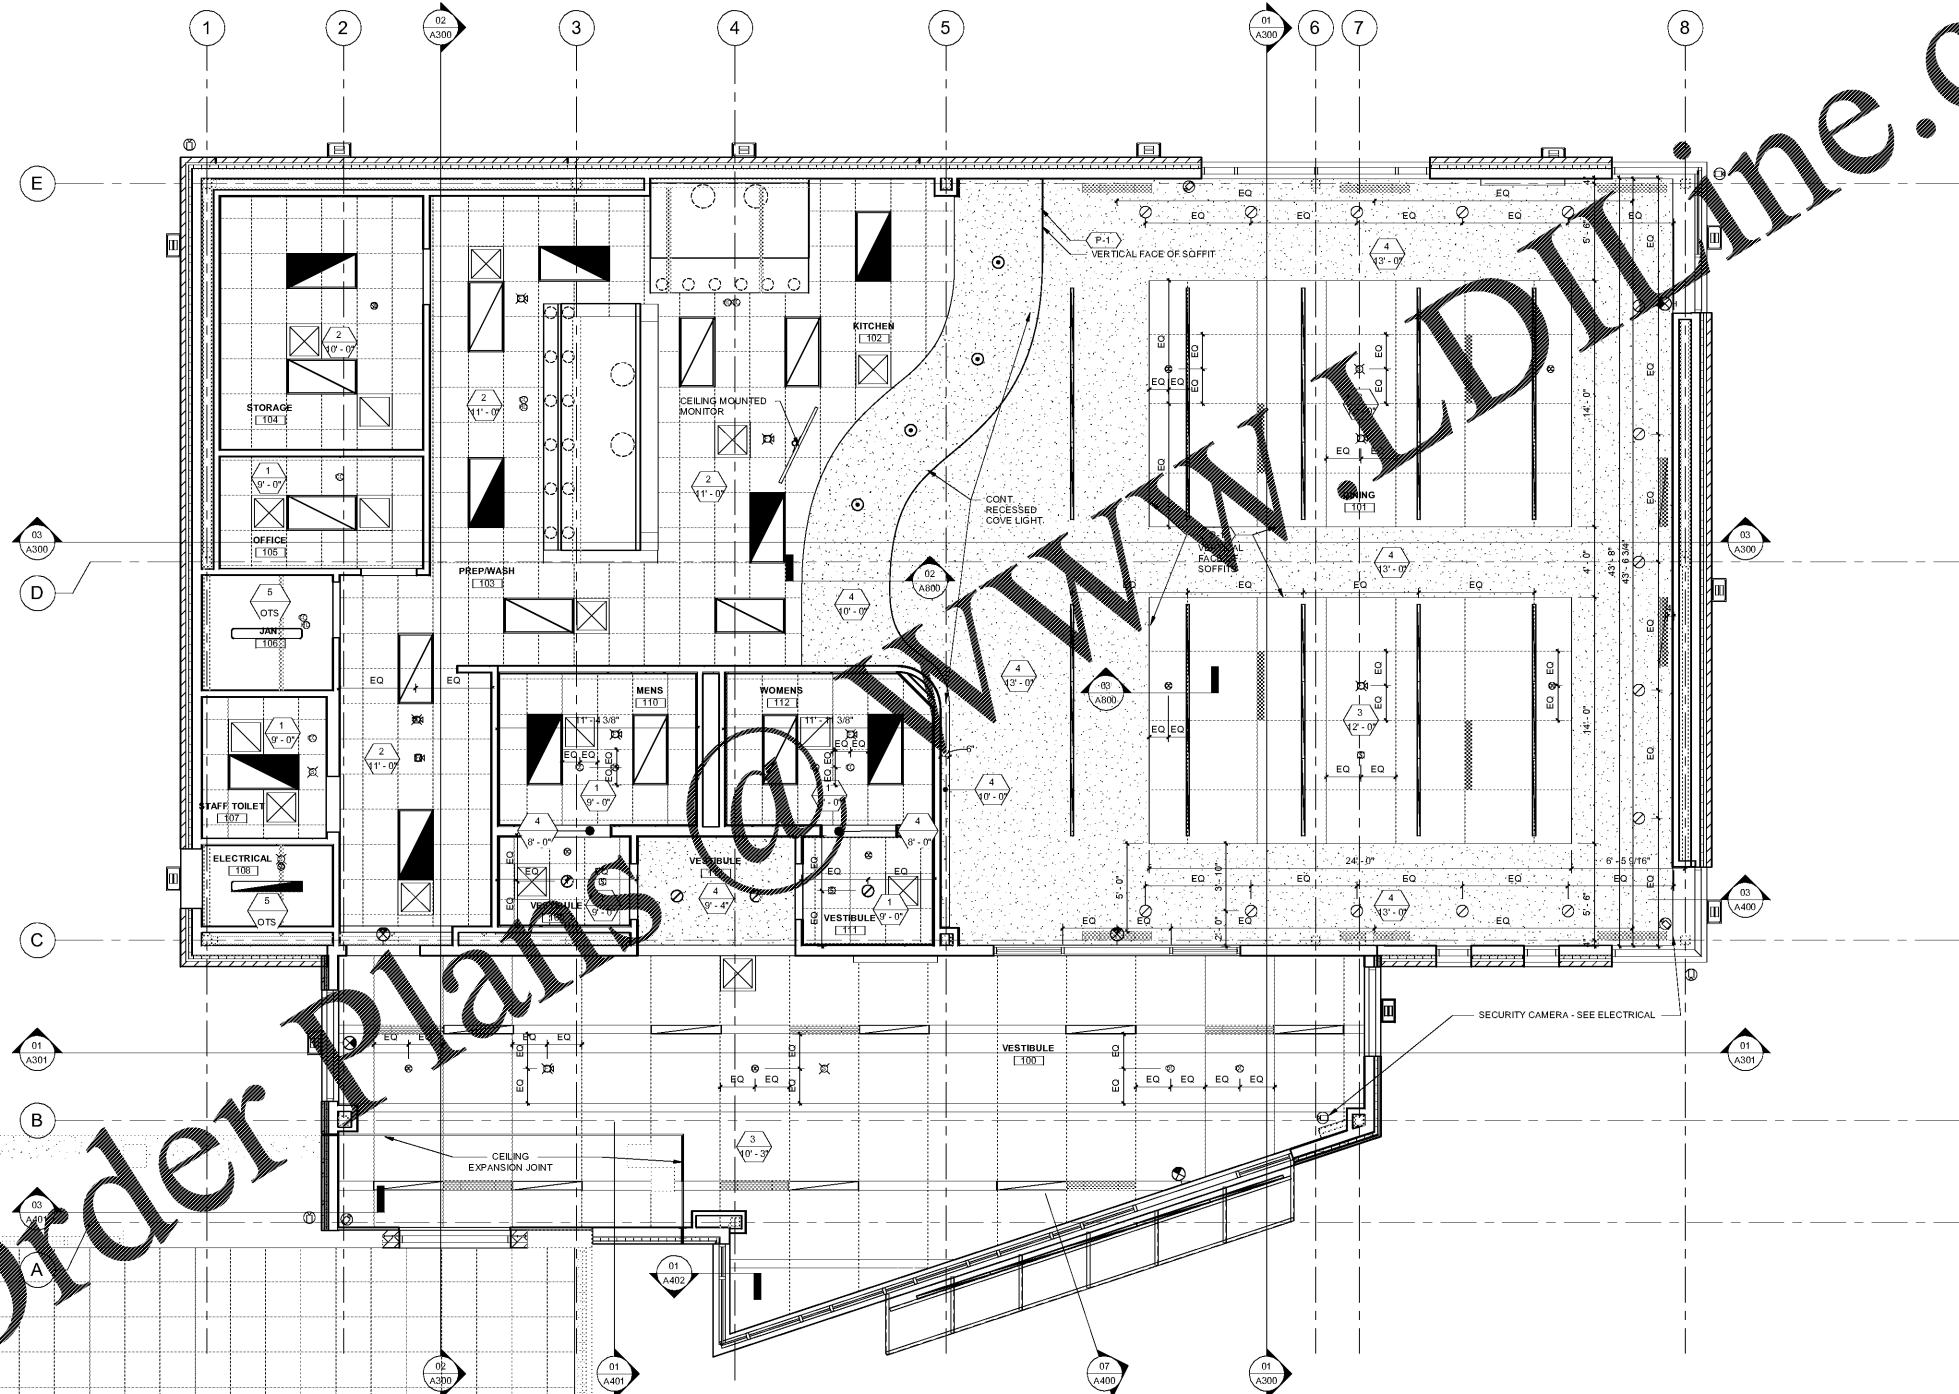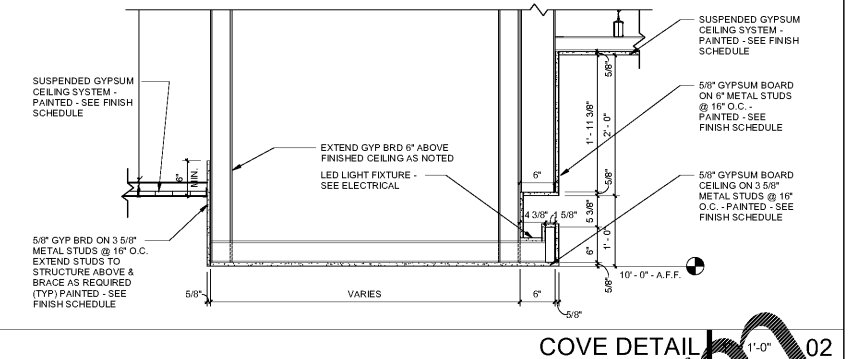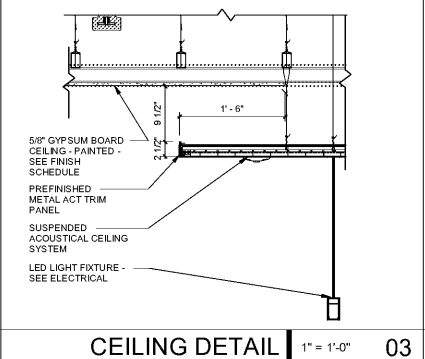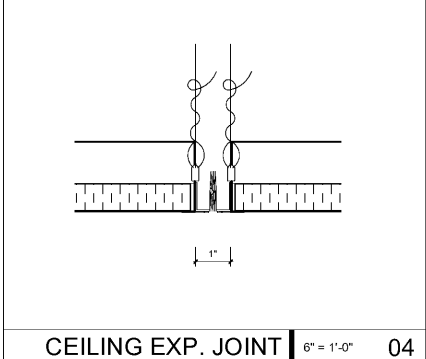

Order Plans @ info@dwgline.com

EXISTING BUILDING

adwarchitects
environments for life

architecture planning interiors

2815 COLISEUM CENTRE DRIVE
SUITE 500
CHARLOTTE, NORTH CAROLINA 28217
P 704.379.1919
F 704.379.1920
www.adwarchitects.com



SCO #16-15889-02A

RICHMOND
COMMUNITY
COLLEGE

LINDSEY-PETRIS
CAFETERIA/DINING
ADDITION VOL. 1


BID DOCUMENTS

REFLECTED CEILING PLAN AND DETAILS

DATE: 04.05.2019
PROJECT NO: 16063

REVISIONS
NO. DATE: DESCRIPTION:

THIS DRAWING IS THE PROPERTY OF ADW ARCHITECTS, P.A. AND SHALL NOT BE REPRODUCED OR COPIED IN WHOLE OR PART. IT SHALL NOT BE USED ON ANY OTHER PROJECT OR GIVEN TO ANY OTHER COMPANY OR AGENCY WITHOUT THE CONSENT OF ADW ARCHITECTS, P.A.

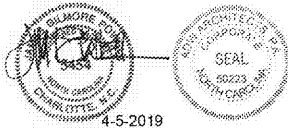

SHEET NUMBER

A800