



1927 South Tryon St., Suite 300, Charlotte, NC 28203  
150 Fayetteville St., Suite 520, Raleigh, NC 27601  
Phone: 704-359-1292 • www.optimaengineering.com



SCO #16-15889-02A

**RICHMOND  
COMMUNITY  
COLLEGE**

LINDSEY-PETRIS  
CAFETERIA / DINING  
ADDITION VOL. 1

BID DOCUMENTS

**FLOOR PLAN -  
WASTE & VENT**

DATE 4-5-2019  
PROJECT NO 16063

REVISIONS


NO	DATE	DESCRIPTION

THIS DRAWING IS THE PROPERTY OF ADW ARCHITECTS, P.A. AND SHALL NOT BE REPRODUCED OR COPIED IN WHOLE OR IN PART, IT SHALL NOT BE USED ON ANY OTHER PROJECT OR GIVEN TO ANY OTHER COMPANY OR AGENCY WITHOUT THE CONSENT OF ADW ARCHITECTS, P.A.



SEAL 04/05/19


SHEET NUMBER **P101**  
4 OF 7  
OPTIMA # 17-0017

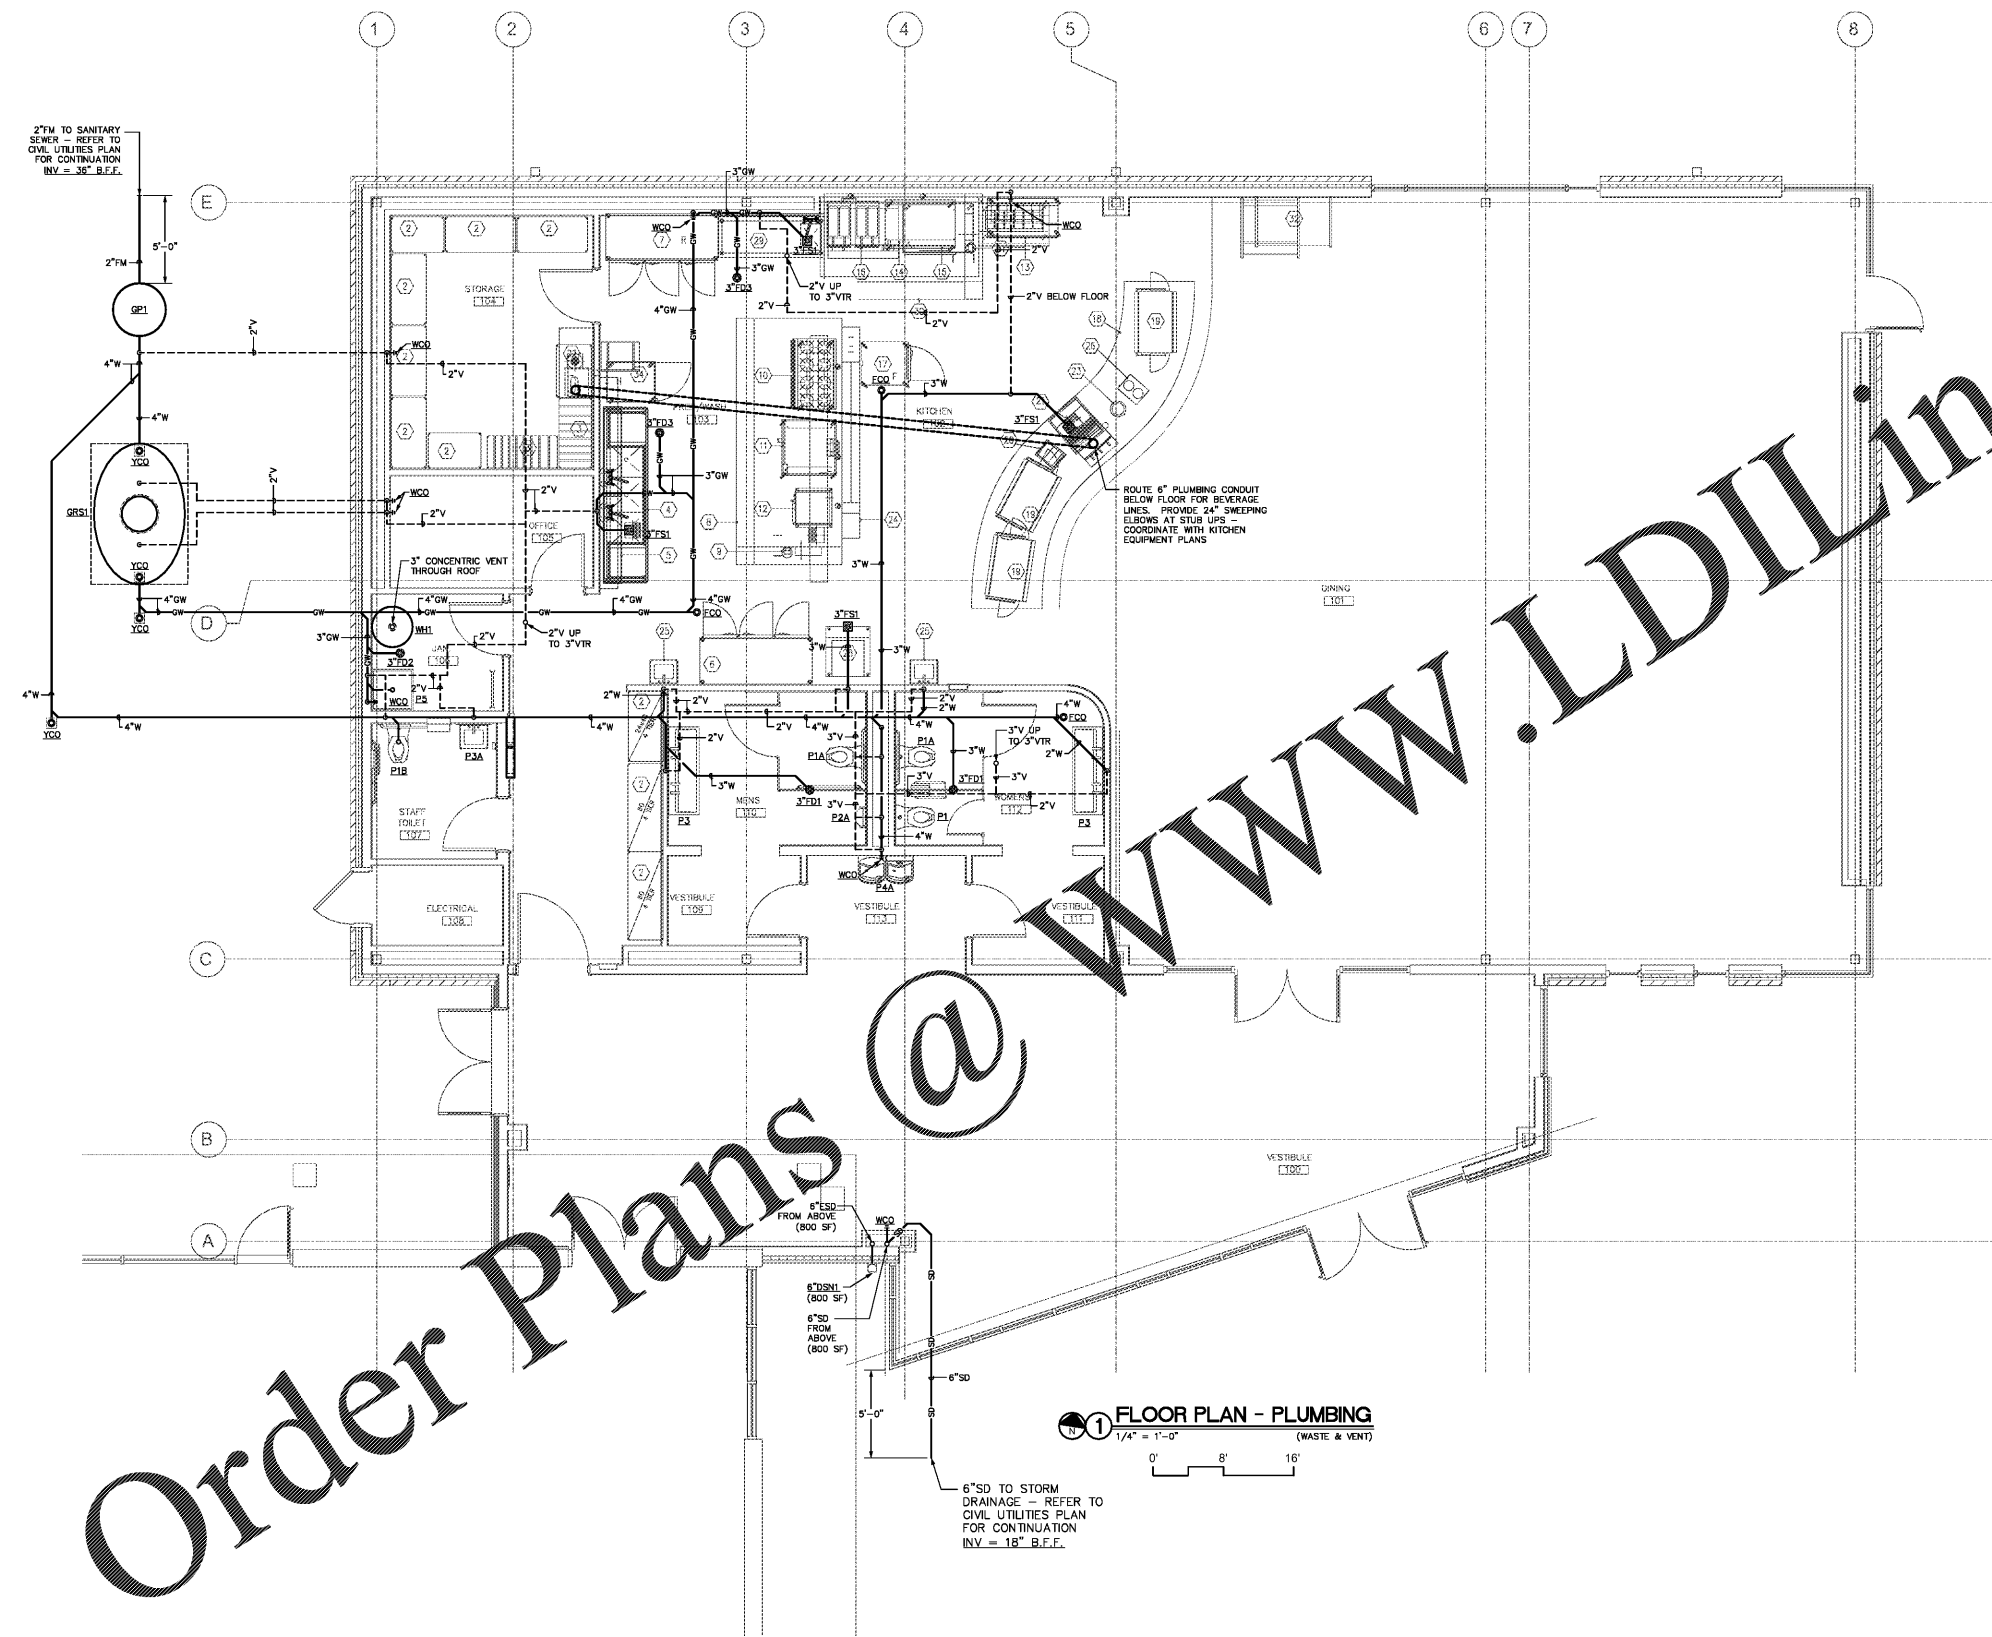

Order Plans @

WWW.LDILine.com

 **1 FLOOR PLAN - PLUMBING**  
1/4" = 1'-0"  
(WASTE & VENT)



6"SD TO STORM DRAINAGE - REFER TO CIVIL UTILITIES PLAN FOR CONTINUATION INV - 18" B.F.F.