



SCO #16-15889-02A

RICHMOND
COMMUNITY
COLLEGE

LINDSEY-PETRIS
CAFETERIA / DINING
ADDITION VOL.1

BID DOCUMENTS

MECHANICAL FLOOR PLAN

DATE 4-5-2019
PROJECT NO 16063


REVISIONS	
NO	DESCRIPTION:

THIS DRAWING IS THE PROPERTY OF ADW ARCHITECTS, P.A. AND SHALL NOT BE REPRODUCED OR COPIED IN WHOLE OR IN PART. IT SHALL NOT BE USED ON ANY OTHER PROJECT OR GIVEN TO ANY OTHER COMPANY OR AGENCY WITHOUT THE CONSENT OF ADW ARCHITECTS, P.A.



SEAL 04/20/19

SHEET NUMBER
5 OF 6
M101
OPTIMA # 17-0017

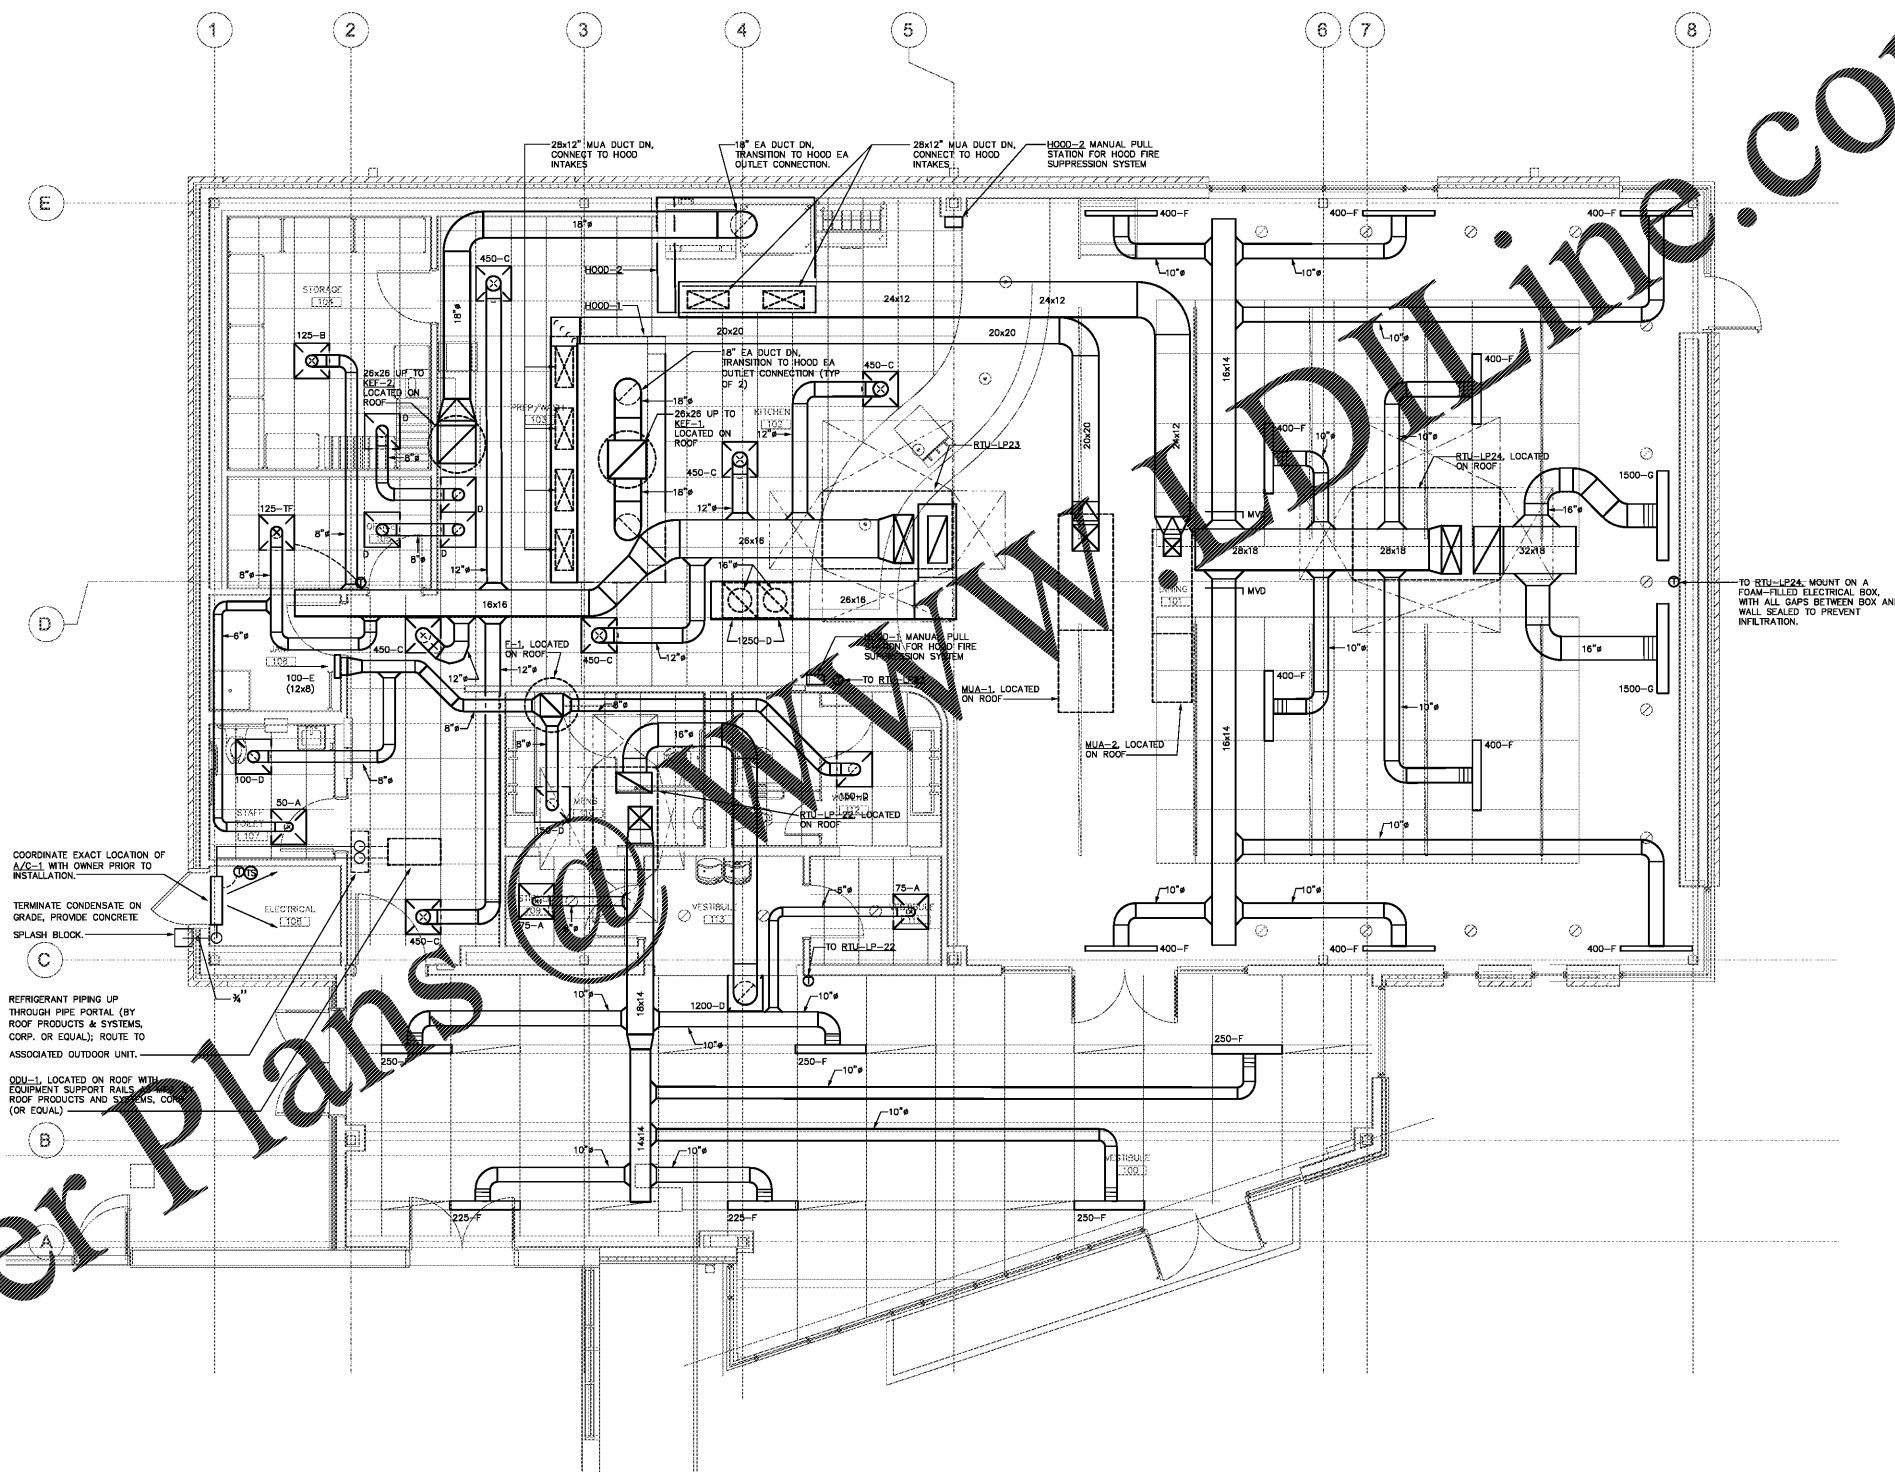

MECHANICAL FLOOR PLAN
1/4" = 1'-0"
0' 8' 16'

Order Plans