



**RICHMOND
COMMUNITY
COLLEGE**

**LEE BUILDING
STUDENT SERVICES &
CAREER CENTER
VOL.2**


BID DOCUMENTS

REFLECTED CEILING PLAN

DATE 04.05.2019
PROJECT NO 16063
REVISIONS
NO DATE DESCRIPTION

THIS DRAWING IS THE PROPERTY OF ADW ARCHITECTS, P.A. AND SHALL NOT BE REPRODUCED OR COPIED IN WHOLE OR IN PART. IT SHALL NOT BE USED ON ANY OTHER PROJECT OR GIVEN TO ANY OTHER COMPANY OR AGENCY WITHOUT THE CONSENT OF ADW ARCHITECTS, P.A.
4-5-2019
SEAL

SHEET NUMBER **A801**

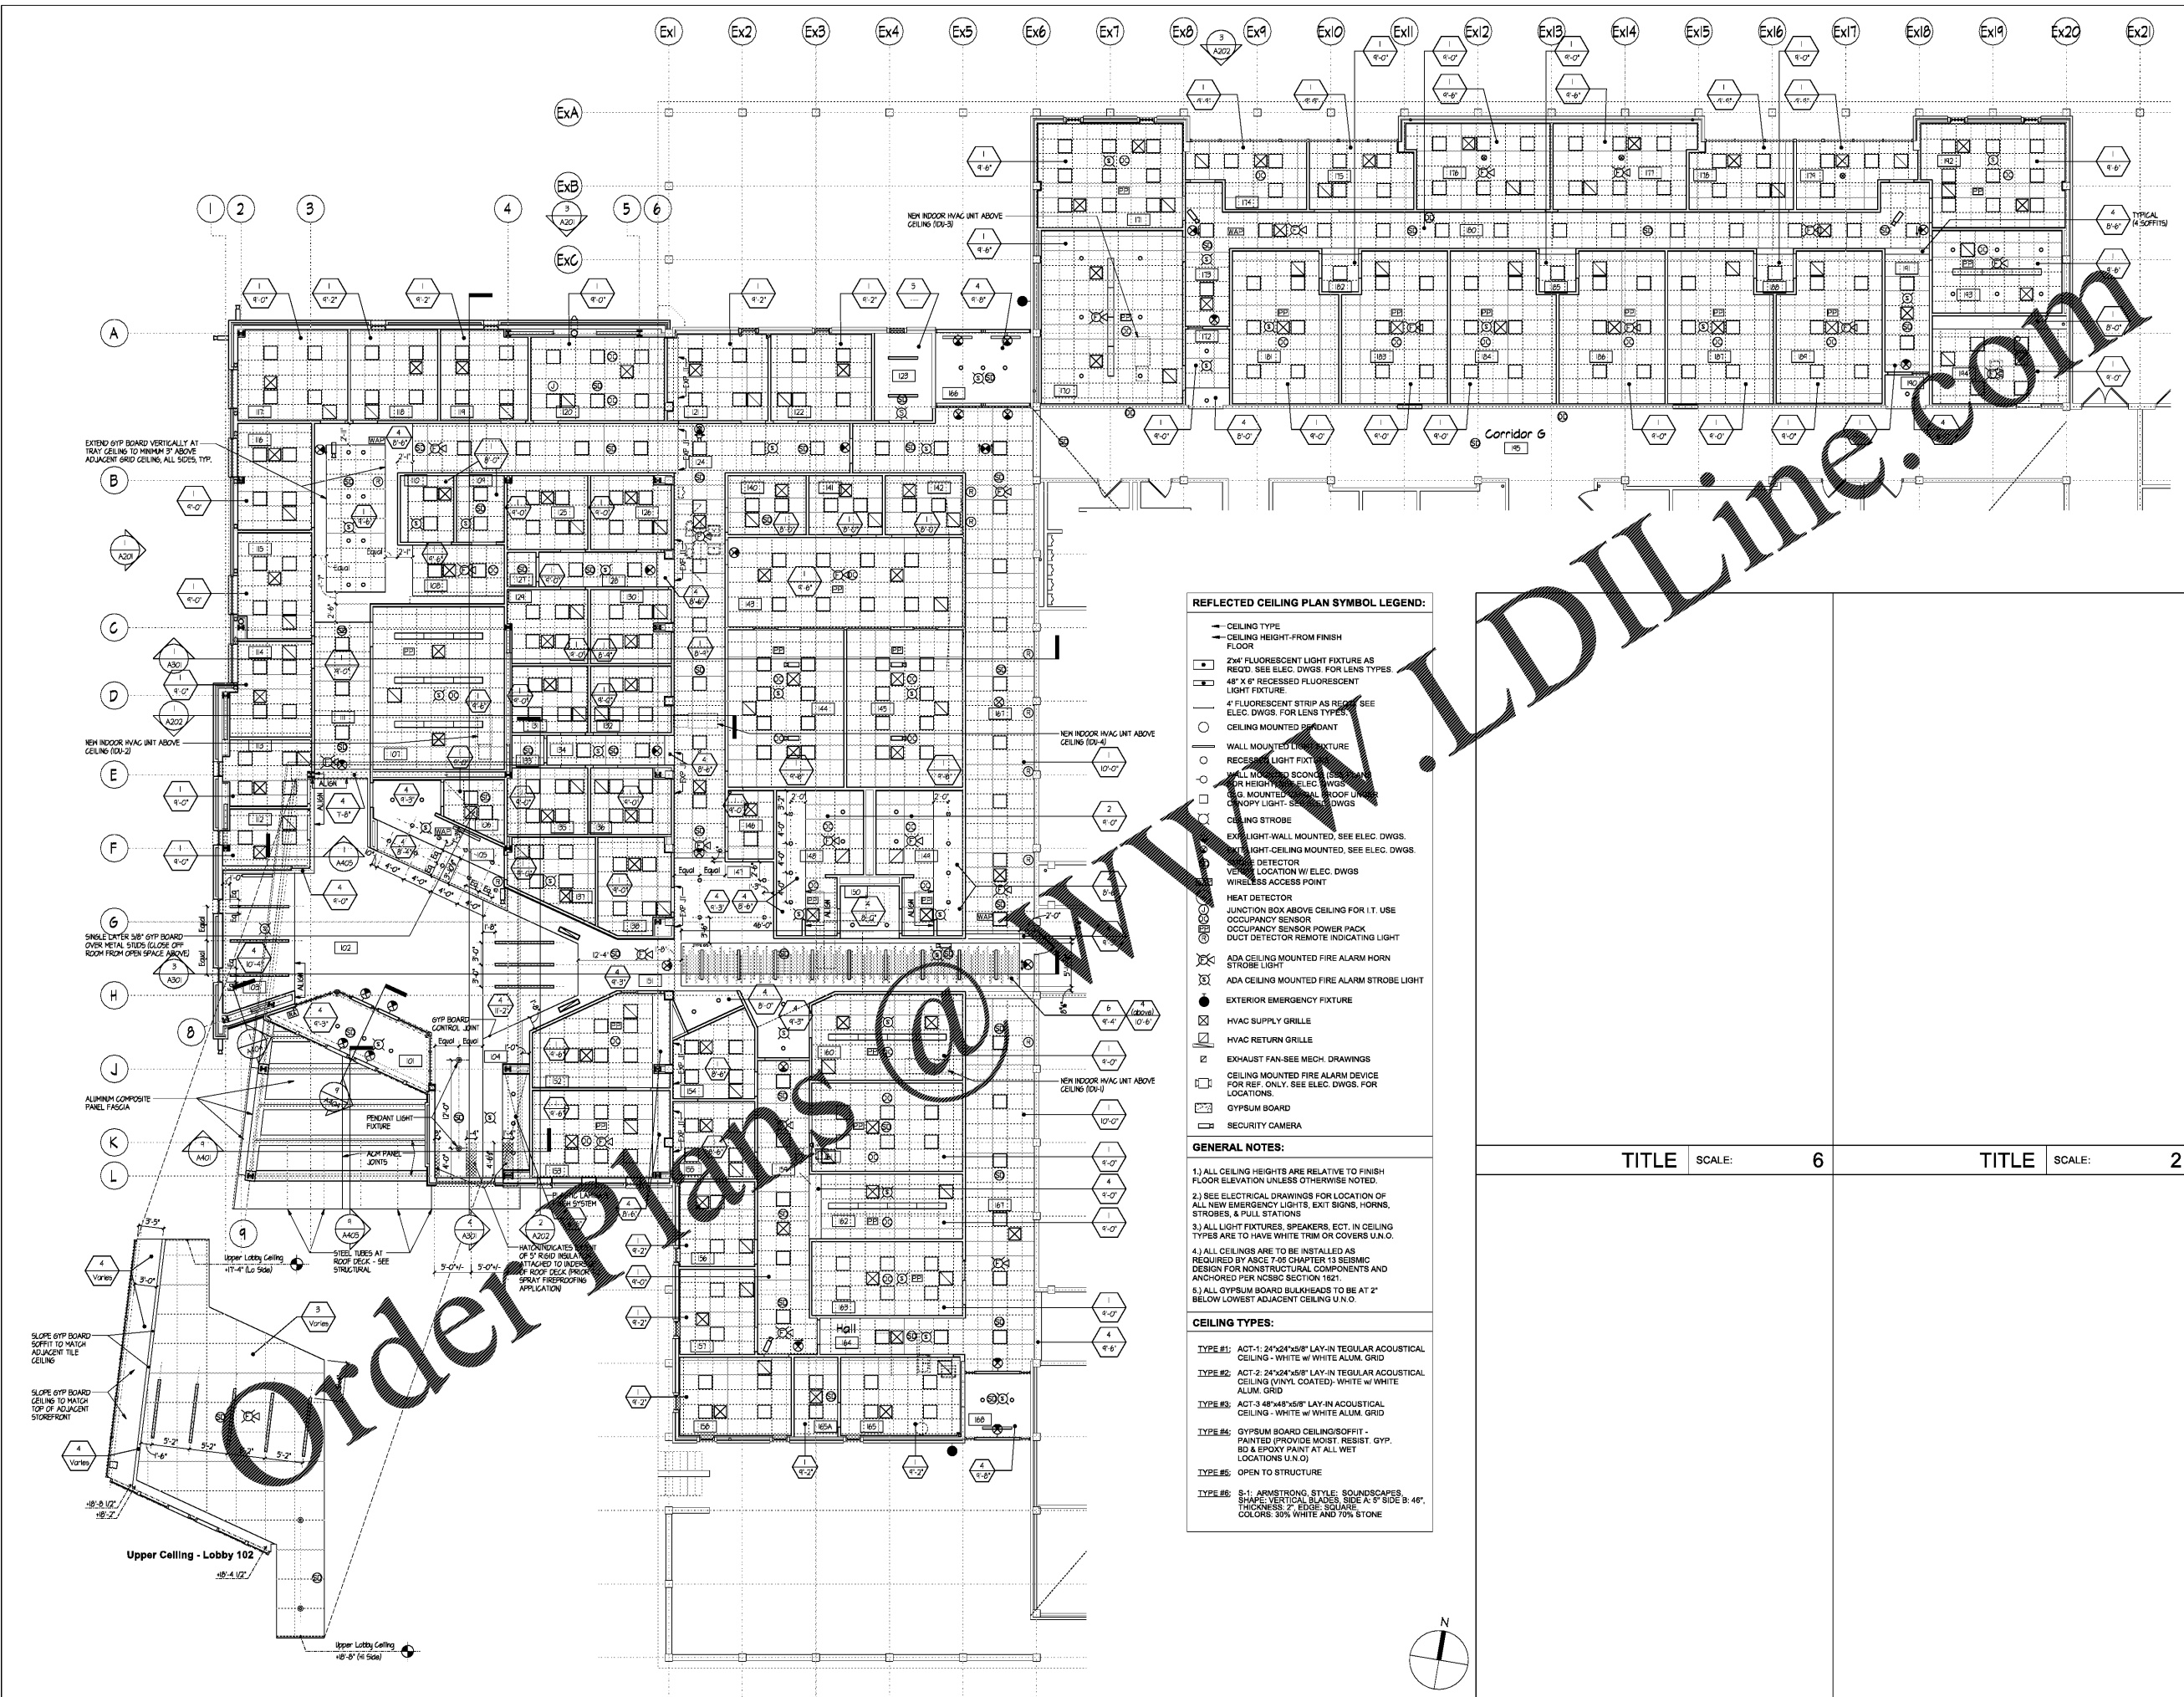

REFLECTED CEILING PLAN SYMBOL LEGEND:

- CEILING TYPE
- CEILING HEIGHT-FROM FINISH FLOOR
- 2'x4' FLUORESCENT LIGHT FIXTURE AS REQ'D. SEE ELEC. DWGS. FOR LENS TYPES
- 48" x 6" RECESSED FLUORESCENT LIGHT FIXTURE
- 4" FLUORESCENT STRIP AS REQ'D. SEE ELEC. DWGS. FOR LENS TYPES
- CEILING MOUNTED PENDANT
- WALL MOUNTED LIGHT FIXTURE
- RECESSED LIGHT FIXTURE
- WALL MOUNTED SCONCE
- RECESSED SCONCE
- GYPSUM BOARD BULKHEAD
- CEILING STROBE
- EX LIGHT-WALL MOUNTED, SEE ELEC. DWGS.
- EX LIGHT-CEILING MOUNTED, SEE ELEC. DWGS.
- DETECTOR
- VENTILATION LOCATION W/ ELEC. DWGS
- WIRELESS ACCESS POINT
- HEAT DETECTOR
- JUNCTION BOX ABOVE CEILING FOR I.T. USE
- OCCUPANCY SENSOR
- OCCUPANCY SENSOR POWER PACK
- DUCT DETECTOR REMOTE INDICATING LIGHT
- ADA CEILING MOUNTED FIRE ALARM HORN STROBE LIGHT
- ADA CEILING MOUNTED FIRE ALARM STROBE LIGHT
- EXTERIOR EMERGENCY FIXTURE
- HVAC SUPPLY GRILLE
- HVAC RETURN GRILLE
- EXHAUST FAN-SEE MECH. DRAWINGS
- CEILING MOUNTED FIRE ALARM DEVICE FOR REF. ONLY. SEE ELEC. DWGS. FOR LOCATIONS.
- GYPSUM BOARD
- SECURITY CAMERA

GENERAL NOTES:

- 1) ALL CEILING HEIGHTS ARE RELATIVE TO FINISH FLOOR ELEVATION UNLESS OTHERWISE NOTED.
- 2) SEE ELECTRICAL DRAWINGS FOR LOCATION OF ALL NEW EMERGENCY LIGHTS, EXIT SIGNS, HORNS, STROBES, & PULL STATIONS
- 3) ALL LIGHT FIXTURES, SPEAKERS, ECT., IN CEILING TYPES ARE TO HAVE WHITE TRIM OR COVERS U.N.O.
- 4) ALL CEILINGS ARE TO BE INSTALLED AS REQUIRED BY ASCE 7-08 CHAPTER 13 SEISMIC DESIGN FOR NONSTRUCTURAL COMPONENTS AND ANCHORED PER NCSCC SECTION 1821.
- 5) ALL GYPSUM BOARD BULKHEADS TO BE AT 2" BELOW LOWEST ADJACENT CEILING U.N.O.

CEILING TYPES:

- TYPE #1: ACT-1: 24"x24"x5/8" LAY-IN REGULAR ACOUSTICAL CEILING - WHITE W/ WHITE ALUM. GRID
- TYPE #2: ACT-2: 24"x24"x5/8" LAY-IN REGULAR ACOUSTICAL CEILING (VINYL COATED) - WHITE W/ WHITE ALUM. GRID
- TYPE #3: ACT-3: 48"x48"x5/8" LAY-IN ACOUSTICAL CEILING - WHITE W/ WHITE ALUM. GRID
- TYPE #4: GYPSUM BOARD CEILING/SOFFIT - PAINTED (PROVIDE MOIST. RESIST. GYP. BD & EPOXY PAINT AT ALL WET LOCATIONS U.N.O.)
- TYPE #5: OPEN TO STRUCTURE
- TYPE #6: S-1: ARMSTRONG, STYLE: SOUNDSCAPES, SHAPE: VERTICAL BLADES, SIDE A: 9" SIDE B: 46", THICKNESS: 7, EDGE: SQUARE, COLORS: 30% WHITE AND 70% STONE

TITLE SCALE: 6

TITLE SCALE: 2

TITLE SCALE: 5

TITLE SCALE: 1