



1927 South Tryon St., Suite 300, Charlotte, NC 28203
150 Fayetteville St., Suite 520, Raleigh, NC 27601
Phone: 704-359-1292 • www.optimaengineering.com



SCO #16-15889-02A

**RICHMOND
COMMUNITY
COLLEGE**

LEE BUILDING
STUDENT SERVICES &
CAREER CENTER
VOL.2

BID DOCUMENTS

FLOOR PLAN -
WASTE & VENT

DATE 4-5-2019
PROJECT NO 16063


NO	DATE	DESCRIPTION

THIS DRAWING IS THE PROPERTY OF ADW ARCHITECTS, P.A. AND SHALL NOT BE REPRODUCED OR COPIED IN WHOLE OR IN PART, IT SHALL NOT BE USED ON ANY OTHER PROJECT OR GIVEN TO ANY OTHER COMPANY OR AGENCY WITHOUT THE CONSENT OF ADW ARCHITECTS, P.A.



SEAL 04/25/19

SHEET NUMBER **P101**
5 OF 7
OPTIMA # 17-0017

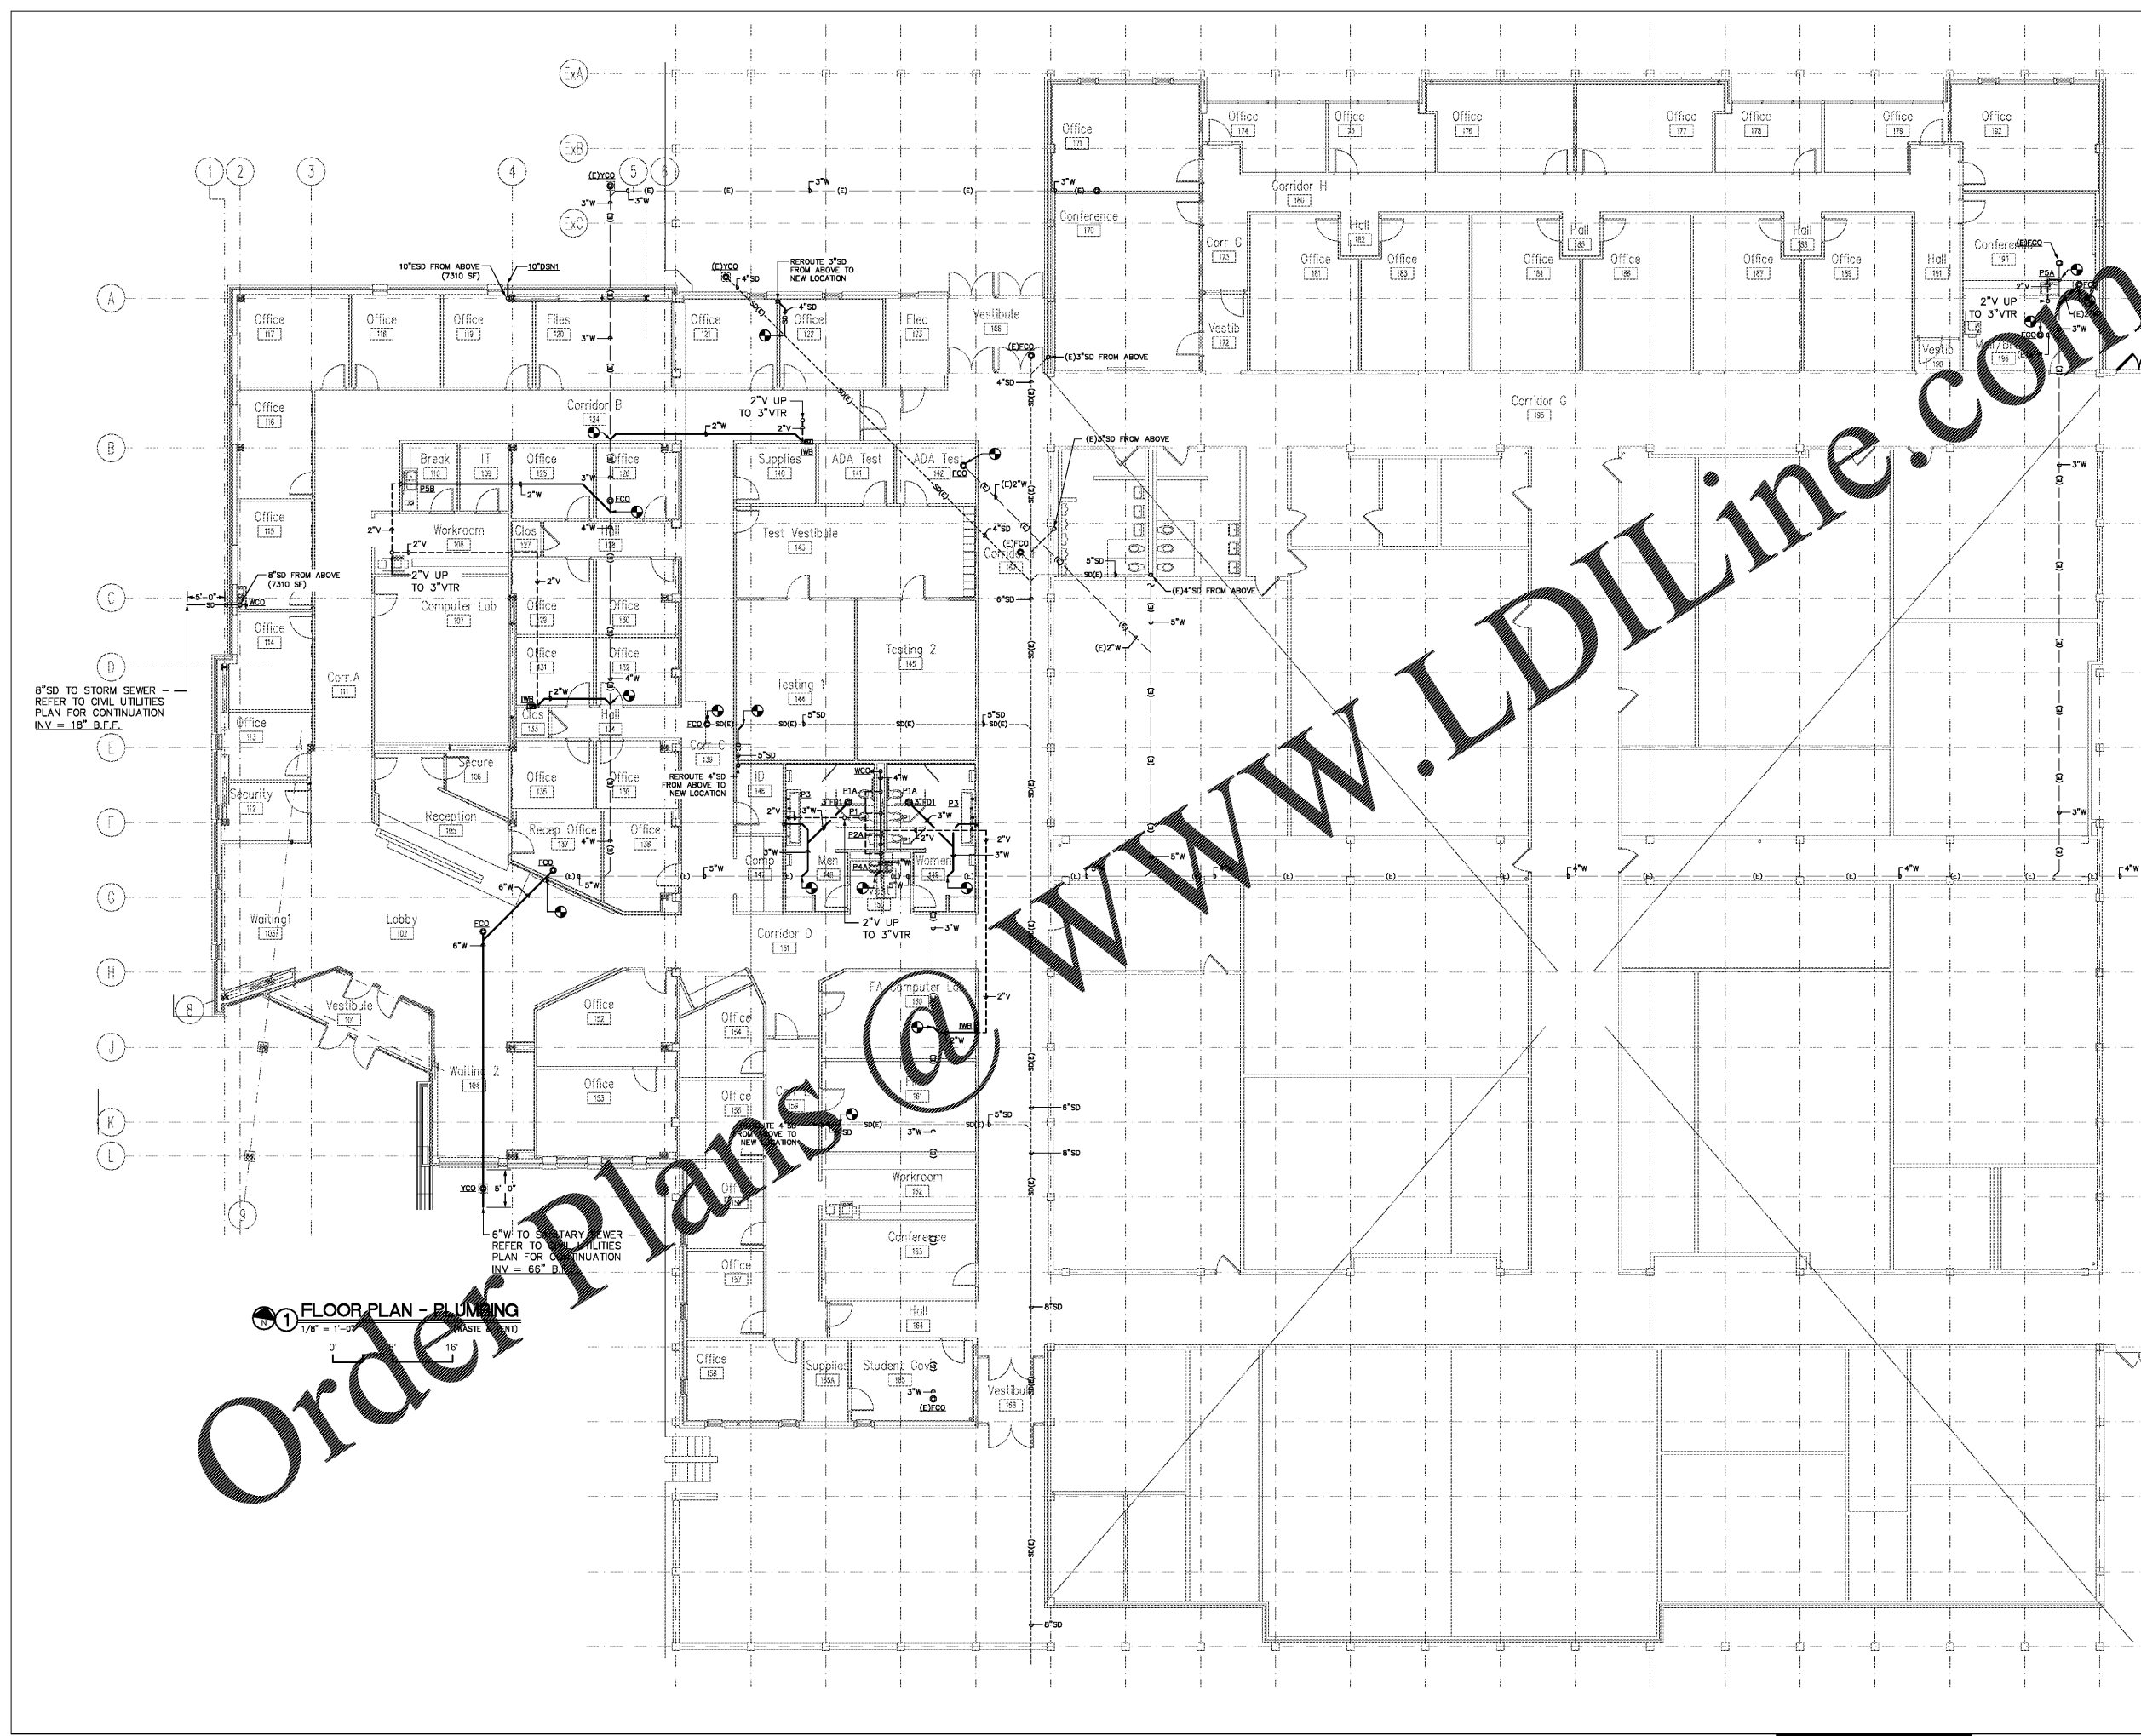

Order Plans @ www.LDILine.com

1 FLOOR PLAN - PLUMBING
1/8" = 1'-0" (WASTE & VENT)

8" SD TO STORM SEWER - REFER TO CIVIL UTILITIES PLAN FOR CONTINUATION INV = 18" B.F.F.

6" W TO SANITARY SEWER - REFER TO CIVIL UTILITIES PLAN FOR CONTINUATION INV = 66" B.F.F.