



SCO #16-15889-02A

**RICHMOND
COMMUNITY
COLLEGE**

LEE BUILDING
STUDENT SERVICES &
CAREER CENTER
VOL.2

BID DOCUMENTS

FLOOR PLAN -
POWER

DATE 4-5-2019
PROJECT NO 16063

NO	DATE	DESCRIPTION


THIS DRAWING IS THE PROPERTY OF ADW ARCHITECTS, P.A. AND SHALL NOT BE REPRODUCED OR COPIED IN WHOLE OR IN PART, IT SHALL NOT BE USED ON ANY OTHER PROJECT OR GIVEN TO ANY OTHER COMPANY OR AGENCY WITHOUT THE CONSENT OF ADW ARCHITECTS, P.A.



SEAL DATE/PA

SHEET NUMBER
13 OF 16
OPTIMA # 17-0017

E201

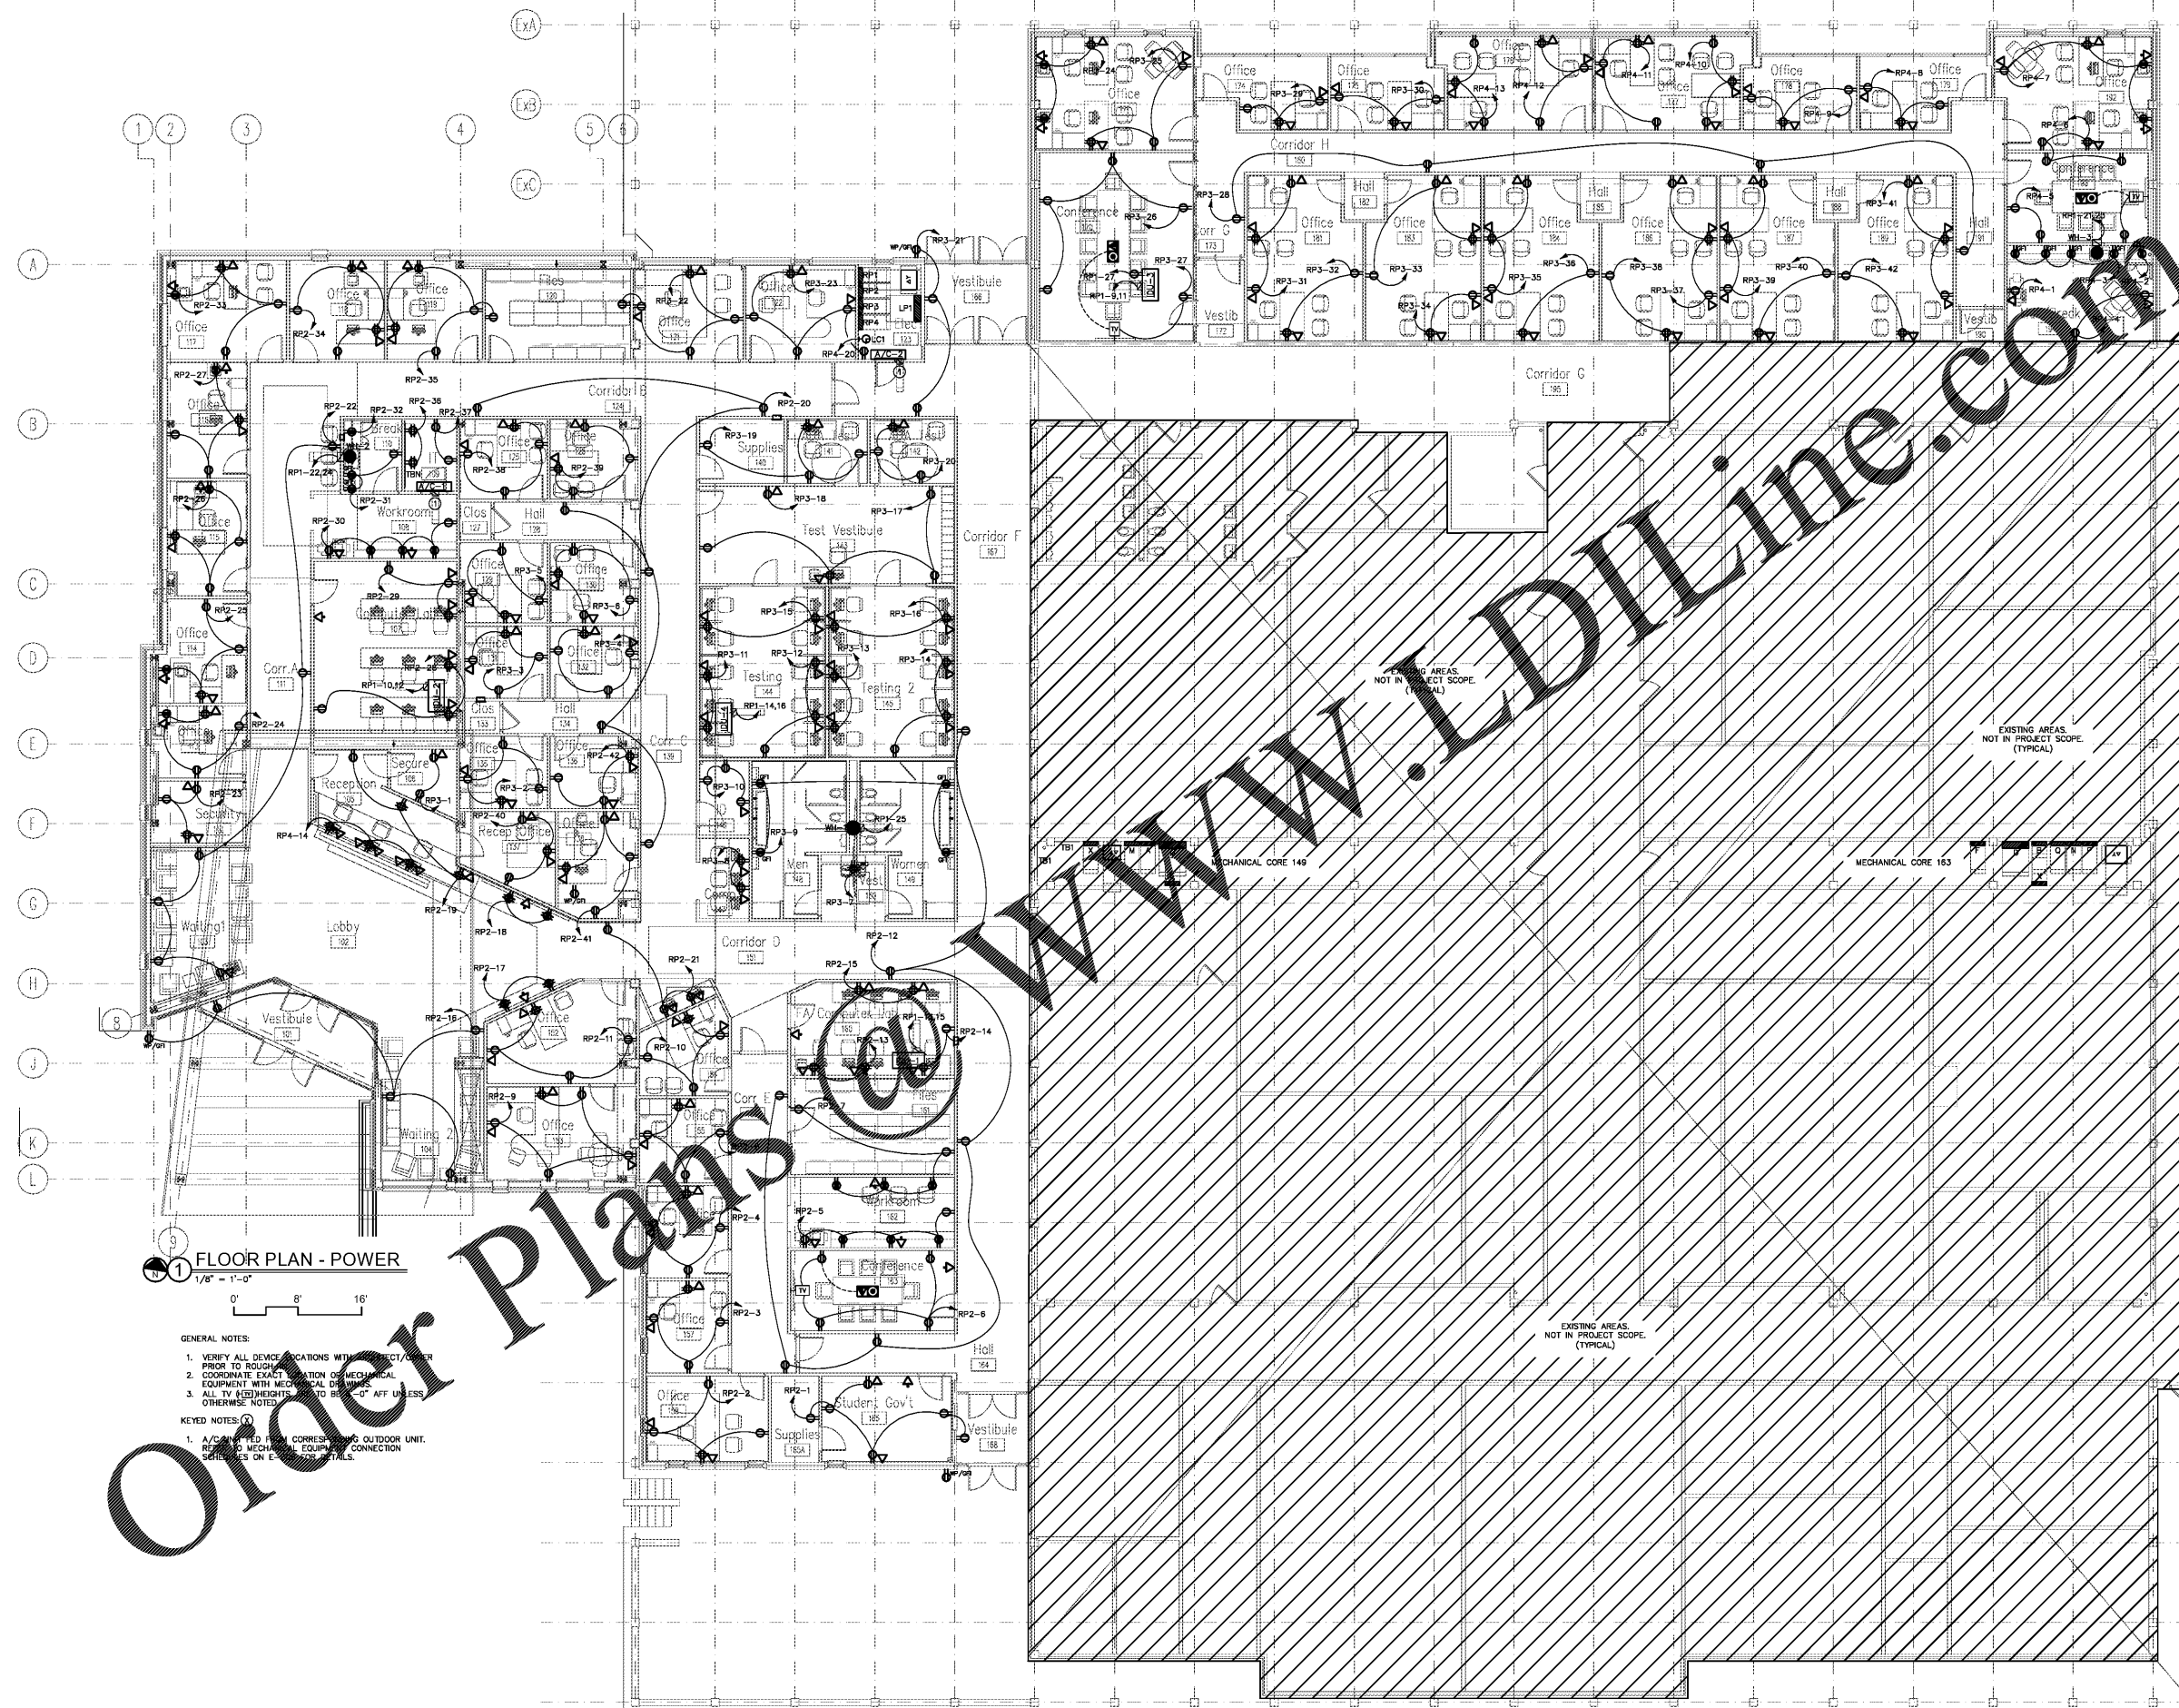

1 FLOOR PLAN - POWER
1/8" = 1'-0"

- GENERAL NOTES:
1. VERIFY ALL DEVICE LOCATIONS WITH FIELD SURVEY PRIOR TO RUSH.
 2. COORDINATE EXACT LOCATION OF MECHANICAL EQUIPMENT WITH MECHANICAL ENGINEER.
 3. ALL TV HEIGHTS TO BE 4'-0" AFF UNLESS OTHERWISE NOTED.

- KEYED NOTES:
1. A/C UNITS TO BE CORRESPONDING OUTDOOR UNIT. REPORT TO MECHANICAL ENGINEER FOR CONNECTION TO THE SYSTEM.

Order Plans @ WWW.LDILLINE.COM