



JOB NO. L1905

NORWOOD ARCHITECTS
807 FORREST ST. N.W.
ATLANTA, GEORGIA 30318
PH: 478-921-0302 FAX: 478-921-0301 WWW.NORWOODARCHITECTS.COM

HUDDLE HOUSE
EVO 2000 RESTAURANT
40 US HWY 84 CAIRO, GA
GRADY CO. 39828

NO. ISSUE DATE
PERMIT SET
04/15/2019


DRAWING NUMBER
DIMENSIONED
& NOTED PLAN

A100
ISSUED FOR CONSTRUCTION

GENERAL NOTES


- UNLESS NOTED OTHERWISE, DIMENSIONS ARE FROM FACE FRAMING, EXTERIOR FRAMING IS 2x6
- SEE SHT. A003 FOR FINISH SCHEDULES
- SEE A700 SERIES DRAWINGS FOR EQUIPMENT, EQUIPMENT LOCATIONS & SCHEDULE
- SEE SHT. A103 FOR APPROX. LOCATION OF GRAPHS & DECOR, SECURELY ANCHOR TO WALL FRAMING OR PROVIDE ADEQUATE BLOCKING IN WALL; CONTACT W/ VENDOR FOR BLOCK RECOMMENDATIONS PRIOR TO INSTALLATION
- PLUMBING FIXTURES ARE PROVIDED BY GC, U.N.O.
- PLUMBING FIXTURES, FAUCETS & ACCESSORIES TO BE ADA COMPLIANT
- G.C. TO PROVIDE PLYWOOD SHEET BLOCKING AT FULL HEIGHT PARTITIONS FOR ALL WALL MOUNTED EQUIPMENT & FIXTURES, DECOR & ACCESSORIES, U.N.O.; G.C. TO COORDINATE W/ VENDORS & SUPPLIERS, CUT SHEETS & INSTALLATION RECOMMENDATIONS PRIOR TO CONSTRUCTION OF WALL FINISH; PLYWOOD TO EXTEND FROM 2'-0" A.F.F. TO 8" ABOVE CEILING, G.C. TO PROVIDE NON-COMBUSTIBLE MITL. BLOCKING ON COOKLINE BACK WALL
- SEE SHT. A402 FOR LOW WALL PARTITION TYPES AND DETAILS

LEGEND

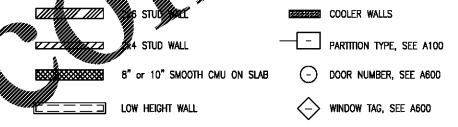


KEY NOTES

- HUDDLE HOUSE TOWER SIGNAGE
- HUDDLE HOUSE BUILDING CHANNEL LETTERS ON RACEWAY (TYP. OF 2)
- NOT USED
- NOT USED
- PRE-FABRICATED SERVICE CANOPY
- DOWNSPOUTS W/ SPLASH BLOCK (TYP. OF 2); PER SITE CONDITIONS
- DOWNSPOUTS W/ HEEL PROOF GRATE (TYP. OF 2) PER SITE CONDITIONS
- WALK-IN CONCRETE SLAB
- HOSE BIBB
- CO2 TANK
- GAS METER
- ELECTRICAL METER
- KNOX BOX, VERIFY LOCATION W/ LOCAL AUTHORITY
- BREAKFAST, LUNCH, & DINNER ENTRY SIGNAGE
- RECESSED ELECTRICAL PANELS
- 24"x24" PLYWD. TELEPHONE BOARD; CENTERLINE MOUNTED AT 48" A.F.F.
- WATER RISER
- MOP SINK; SEE PLUMBING DWGS.
- WATER HEATER ON PLATFORM; SEE PLUMBING DWGS.; RE: DTL. 18/A402
- MANAGER'S DESK W/ LOCKABLE CABINETS; RE: DTL. 17/A402
- FLOOR TO CEILING QUILTED STAINLESS STEEL Q/ PLYWD. Q/ MITL. FRAMING
- LADDER TO ROOF
- DOUBLE PASS-THRU SHELF ON 48" A.F.F. LOW WALL. RE: B/A402
- NOT USED
- LOW WALL TYP. RE: DTL. 9/A402
- STEEL POST WITHIN LOW WALL. SEE STRUCTURAL FOR QUANTITY, LOCATIONS, & DETAILS
- LOW WALL W/CASHER COUNTER. RE: DTL. 7/A402
- STEEL COLUMN; RE: STRUCT. PLANS

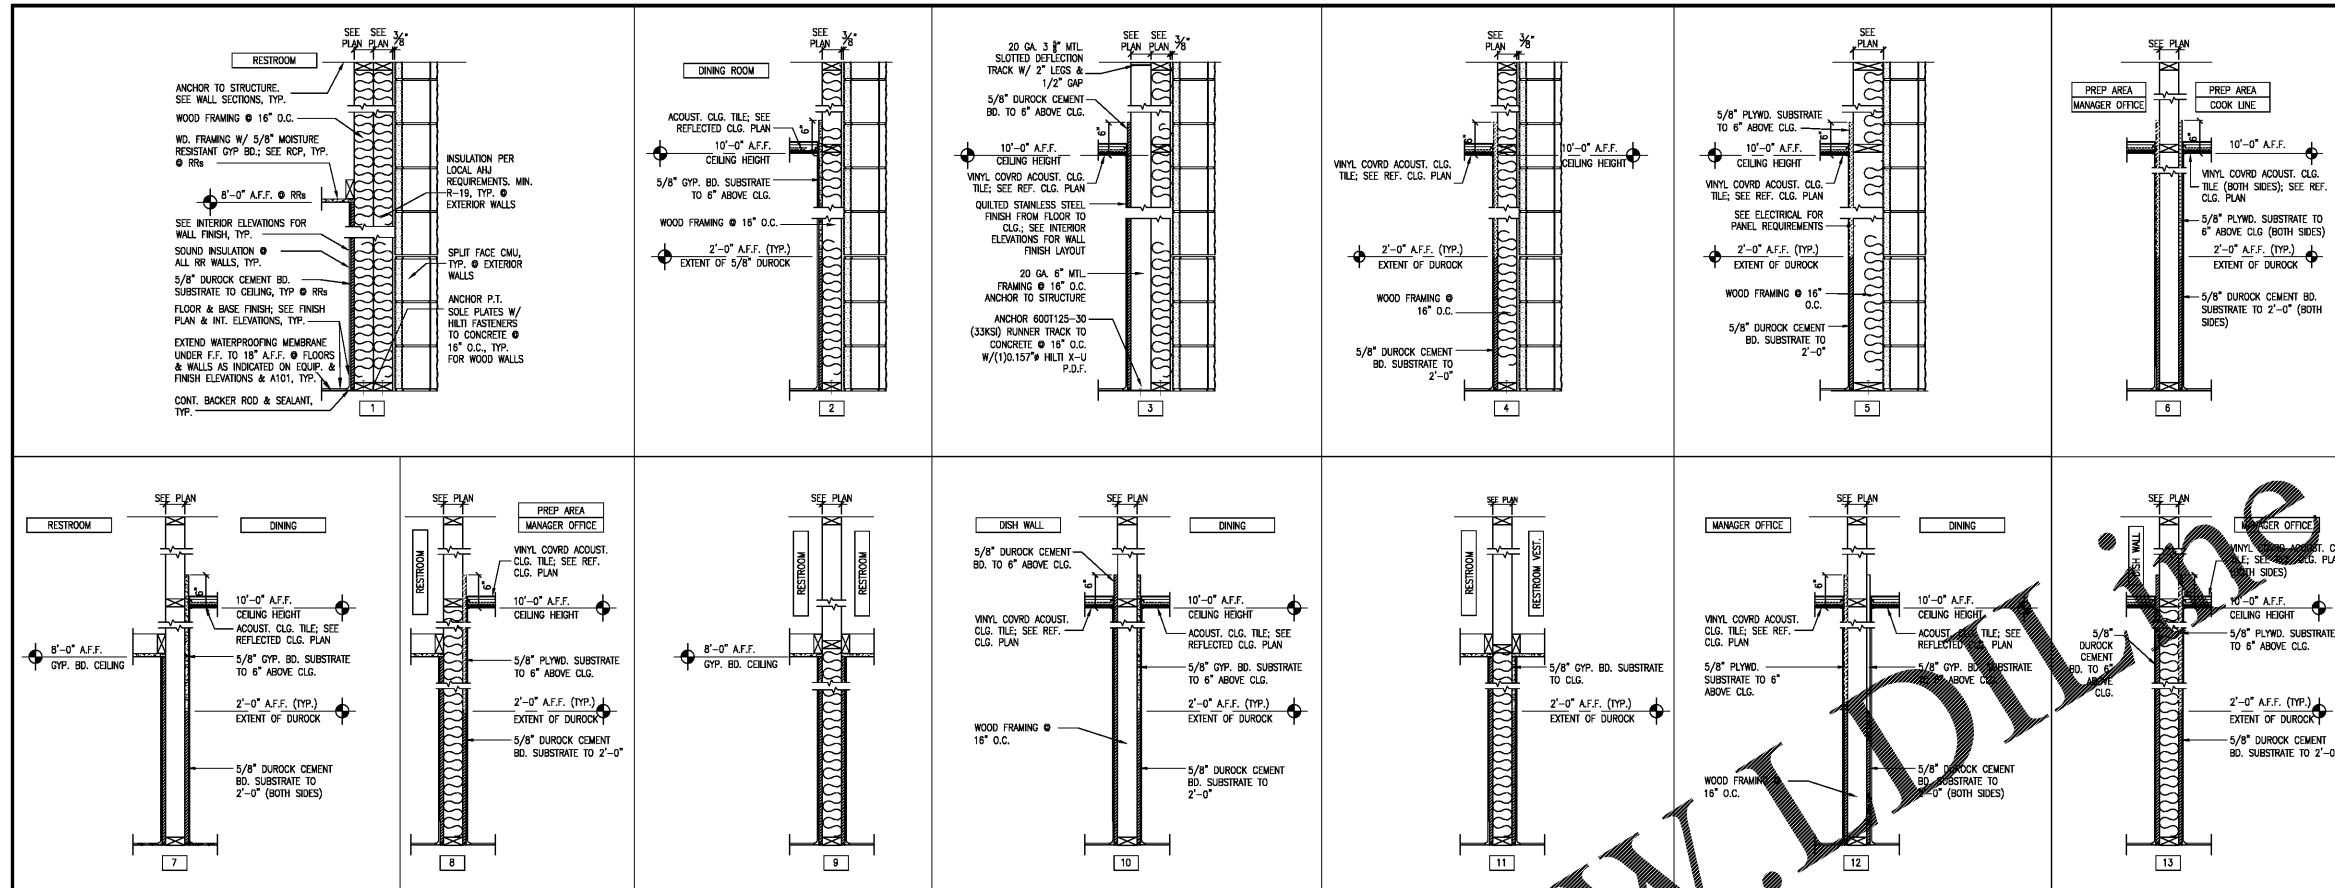

2 PARTITION SCHEDULE SEE WALL TYPE 1 FOR TYPICAL PARTITION WALL NOTES SCALE: 3/4"=1'-0"

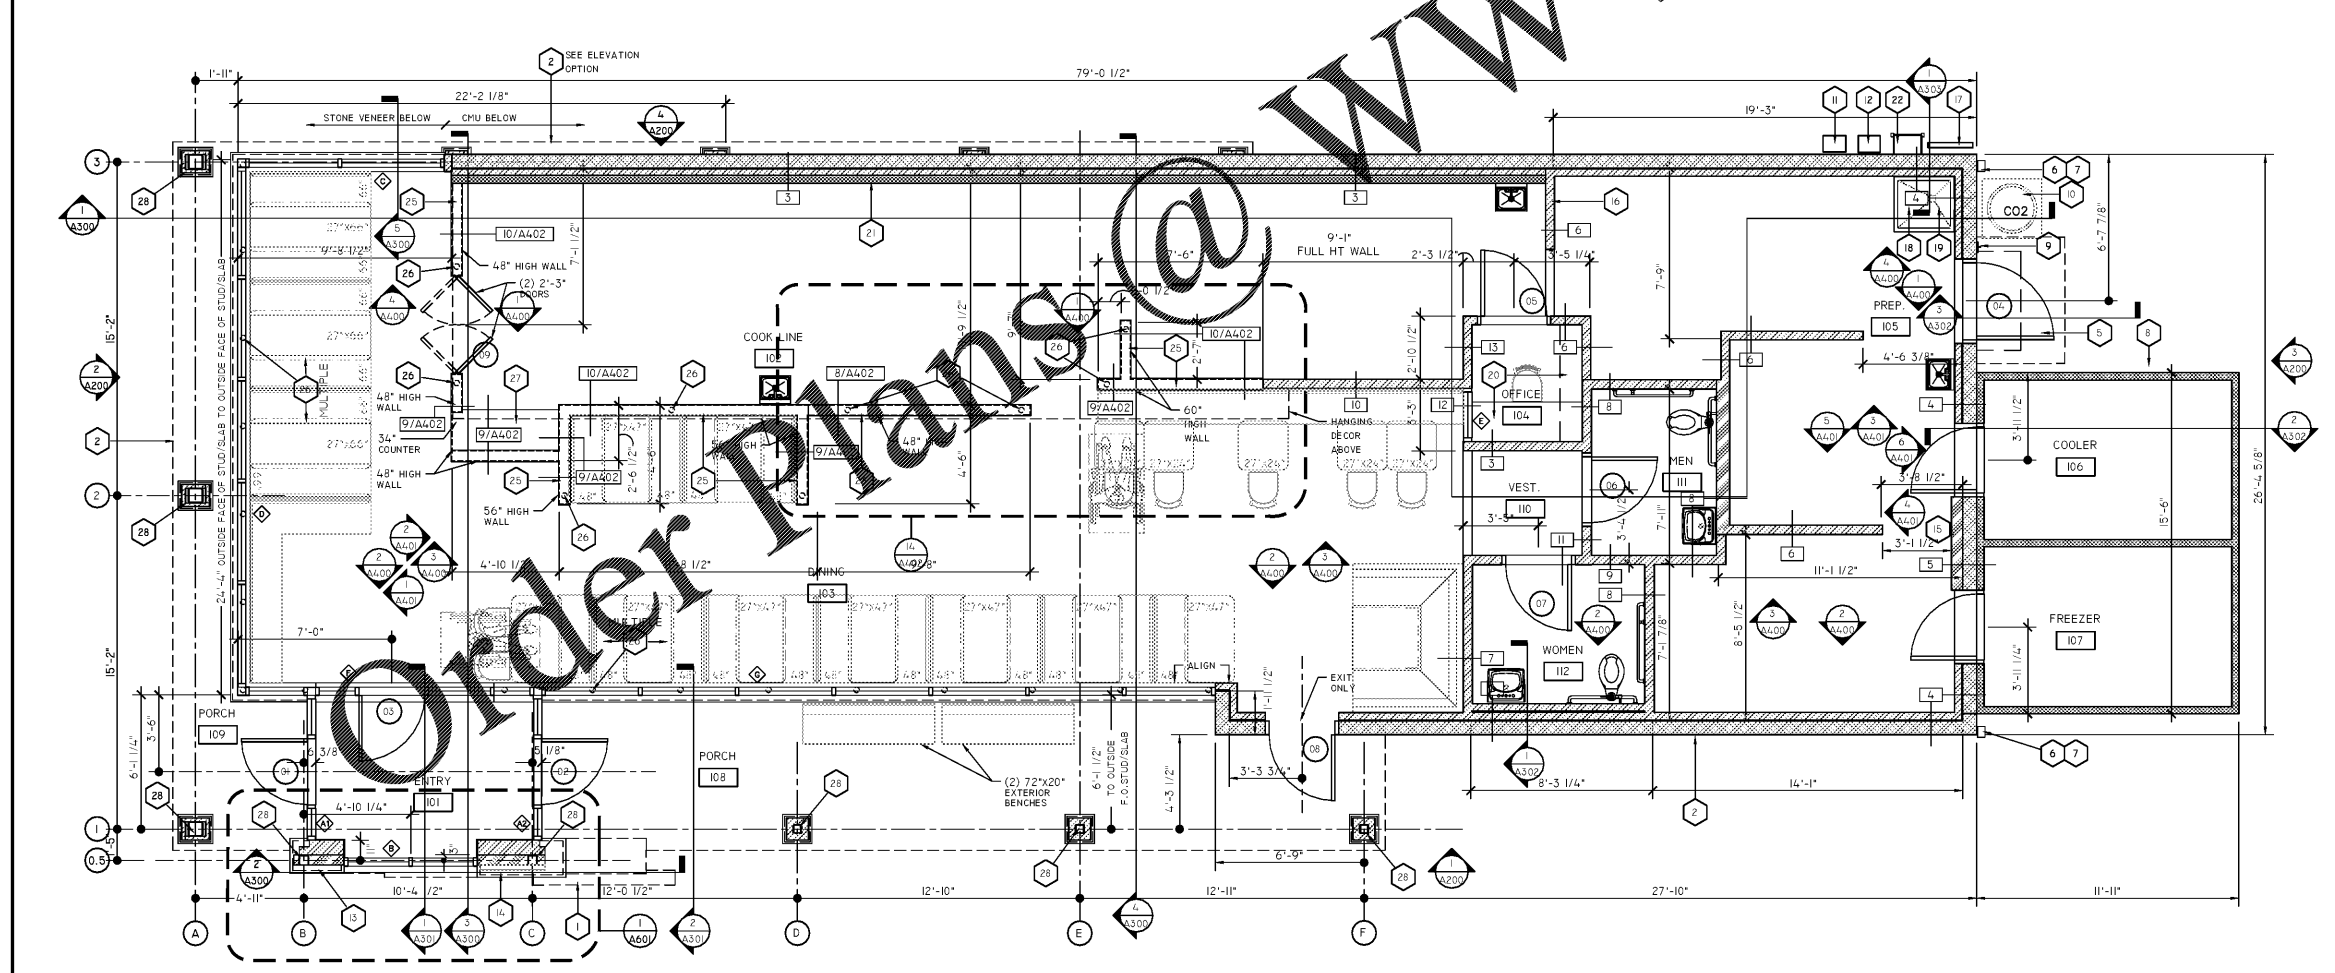

1 DIMENSION PLAN SCALE: 1/4"=1'-0"