



JOB NO. L1905

NORWOOD ARCHITECTS  
 807 FORREST ST. N.W.  
 ATLANTA, GEORGIA 30318  
 PH: 478-921-0302 FAX: 478-921-0301 WWW.NORWOODARCHITECTS.COM

HUDDLE HOUSE  
 EVO 2000 RESTAURANT  
 40 US HWY 84 CAIRO, GA  
 GRADY CO. 39828

NO. ISSUE DATE  
 PERMIT SET  
 04/15/2019




DRAWING NUMBER  
**REFLECTED  
 CEILING PLAN**

**A104**  
 ISSUED FOR CONSTRUCTION

SUPPLIED AND INSTALLED BY GC				CEILING SYMBOL LEGEND			
SYMBOL	DESCRIPTION	SYMBOL	DESCRIPTION	SYMBOL	DESCRIPTION	SYMBOL	DESCRIPTION
	AC-01 ACoustical CEILING TILE SEE FINISH SCHEDULE, SHEET A003		AC-02 ACoustical CEILING TILE SEE FINISH SCHEDULE, SHEET A003		AC-03 ACoustical CEILING TILE SEE FINISH SCHEDULE, SHEET A003		EXHAUST AIR DIFFUSER, SEE MECHANICAL DWGS.
	CB-01 5/8" (REGULAR) GYP. BD. CEILING; PAINT (PF-02)		CB-02 5/8" (M.L.) GYP. BD. CEILING; PAINT (PF-01)		SUPPLY AIR DIFFUSERS-FINISH TO MATCH ADJACENT CEILING TILE SEE MECHANICAL DWGS.		RETURN AIR DIFFUSERS-FINISH TO MATCH ADJACENT CEILING TILE SEE MECHANICAL DWGS.
	EF-10 EFS (DRYVIT SYSTEM); COLOR SW7005 PAINT "PURE WHITE" (EF-08); FINISH SANDPAPER FINE DPF; APPLY PAINT TO EFS		SUPPLY AIR DIFFUSERS-FINISH TO MATCH ADJACENT CEILING TILE SEE MECHANICAL DWGS.		RETURN AIR DIFFUSERS-FINISH TO MATCH ADJACENT CEILING TILE SEE MECHANICAL DWGS.		NOT USED: SURFACE MOUNTED EXTERIOR WALL SOUNDCES SEE ELECTRICAL DWGS.
	2x4 LENSED FLUORESCENT SEE ELECTRICAL DWGS.		MUSICAL THEATRE LIGHTING SYSTEM SPEAKERS/AMPLIFIER INSTALLED, FINISH TO MATCH ADJACENT CEILING TILE SEE MECHANICAL DWGS.		RECESSED DOWN LIGHTS SEE ELECTRICAL DWGS.		NOT USED: RECESSED ADJUSTABLE CAN LIGHTS SEE ELECTRICAL DWGS.
	5/8" GYP. BD. CEILING PAINT PER FINISH SCHEDULE		SLURP MOUNTED EXTERIOR WALL SCONCE SEE ELECTRICAL DWGS.		RECESSED DOWN LIGHTS SEE ELECTRICAL DWGS.		CEILING MOUNTED EXIT SIGN SEE ELECTRICAL DWGS.
	PENDANT LIGHT - CENTER OVER TABLE SEE ELECTRICAL DWGS.		WALL MOUNTED EXIT SIGN SEE ELECTRICAL DWGS.		CEILING MOUNTED EXIT SIGN SEE ELECTRICAL DWGS.		WALL MOUNTED EXIT SIGN SEE ELECTRICAL DWGS.
	CEILING MOUNTED EXIT SIGN SEE ELECTRICAL DWGS.		EXTERIOR EMERGENCY LIGHT SEE ELECTRICAL DWGS.		EMERGENCY LIGHTING		

- GENERAL NOTES**
- DIMENSIONS ARE FROM WALL SUBSTRATE TO CENTERLINE OF FIXTURE UNLESS NOTED.
  - SEE FOOD SERVICE DWGS. (A700 SERIES) FOR FOOD SERVICE EQUIPMENT, LOCATIONS & SCHEDULE.
  - SEE ELECTRICAL FOR FIXTURE TYPE & REQUIREMENTS.
  - SEE SHEET A103 FOR DECOR PACKAGE & GRAPHIC WALL COVERING LOCATIONS.
  - ELECTRICAL OUTLET MOUNTING HEIGHTS PER ELECTRICAL DWGS.
  - SEE SHEET A100 FOR PARTITION TYPES.
  - SEE SHEET A003 FOR FINISHES.


- KEY NOTES**
- PRE-FABRICATED SERVICE CANOPY; G.C. TO PROVIDE & INSTALL BLOCKING.
  - VALANCE: ATTACHMENT SUPPORT CLIPS TO CEILING GRID.
  - COORDINATE W/ HUDDLE HOUSE FOR EXTERIOR FLOOD LIGHT TO ILLUMINATE FACE OF ENTRY TOWER.
  - CENTER RECESSED DOWN LIGHTS IN CEILING TILE, TYP. UNLESS NOTED.
  - TYPE 1" EXHAUST HOOD.
  - DISHWASHER EXHAUST HOOD; IF REQ'D BY LOCAL AHA's.
  - AIR CURTAIN, CENTER OVER DOOR.
  - CENTER RESTROOM EXHAUST GRILLES OVER TOILET FIXTURES.
  - CEILING MOUNTED TV.

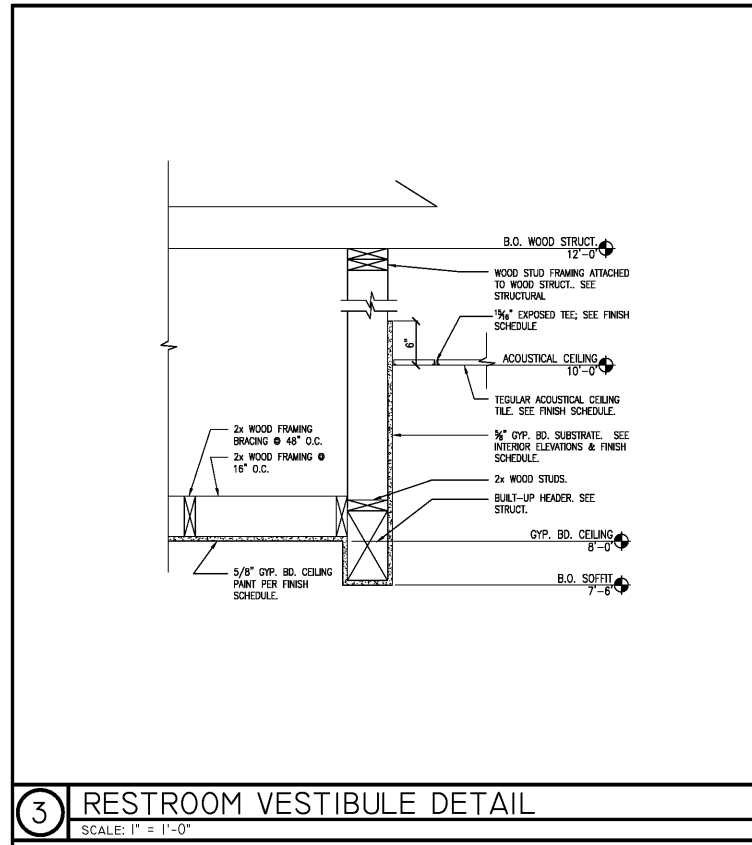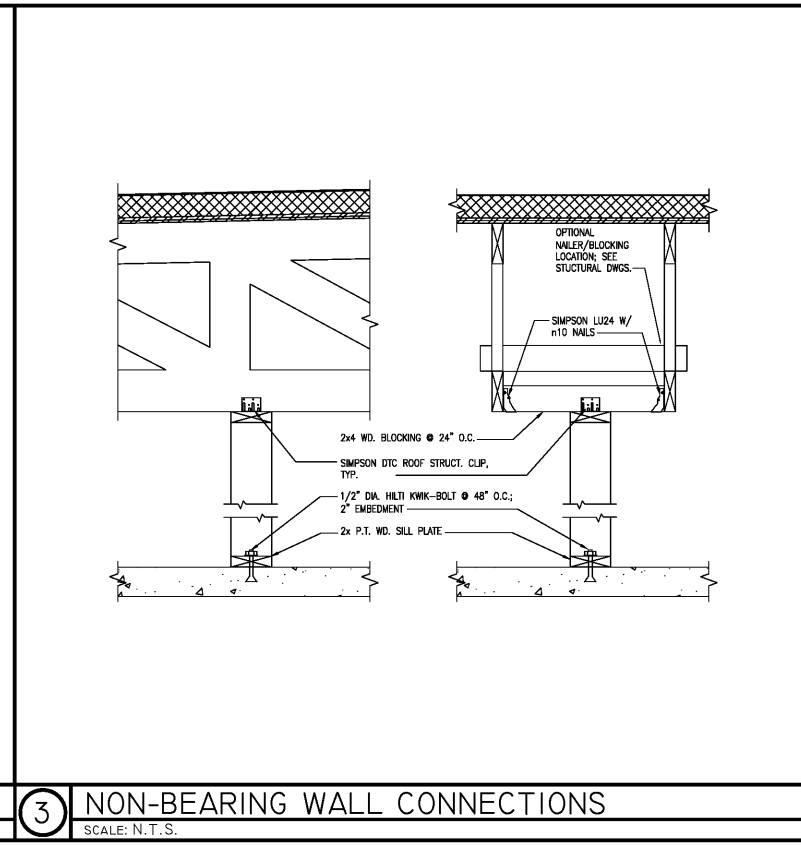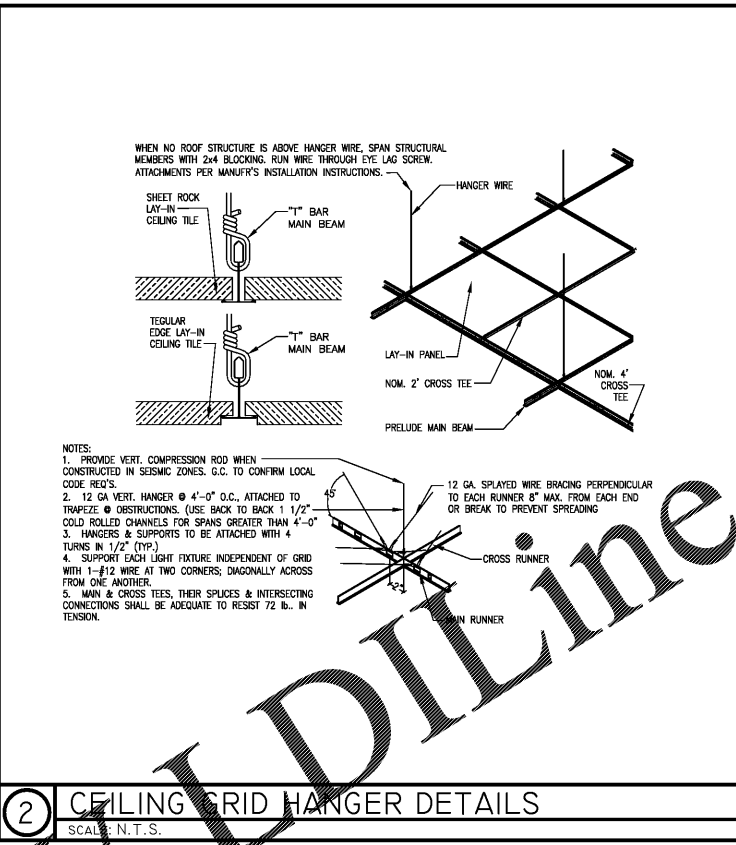

**3 RESTROOM VESTIBULE DETAIL**  
 SCALE: 1" = 1'-0"

**3 NON-BEARING WALL CONNECTIONS**  
 SCALE: N.T.S.

**2 CEILING GRID HANGER DETAILS**  
 SCALE: N.T.S.

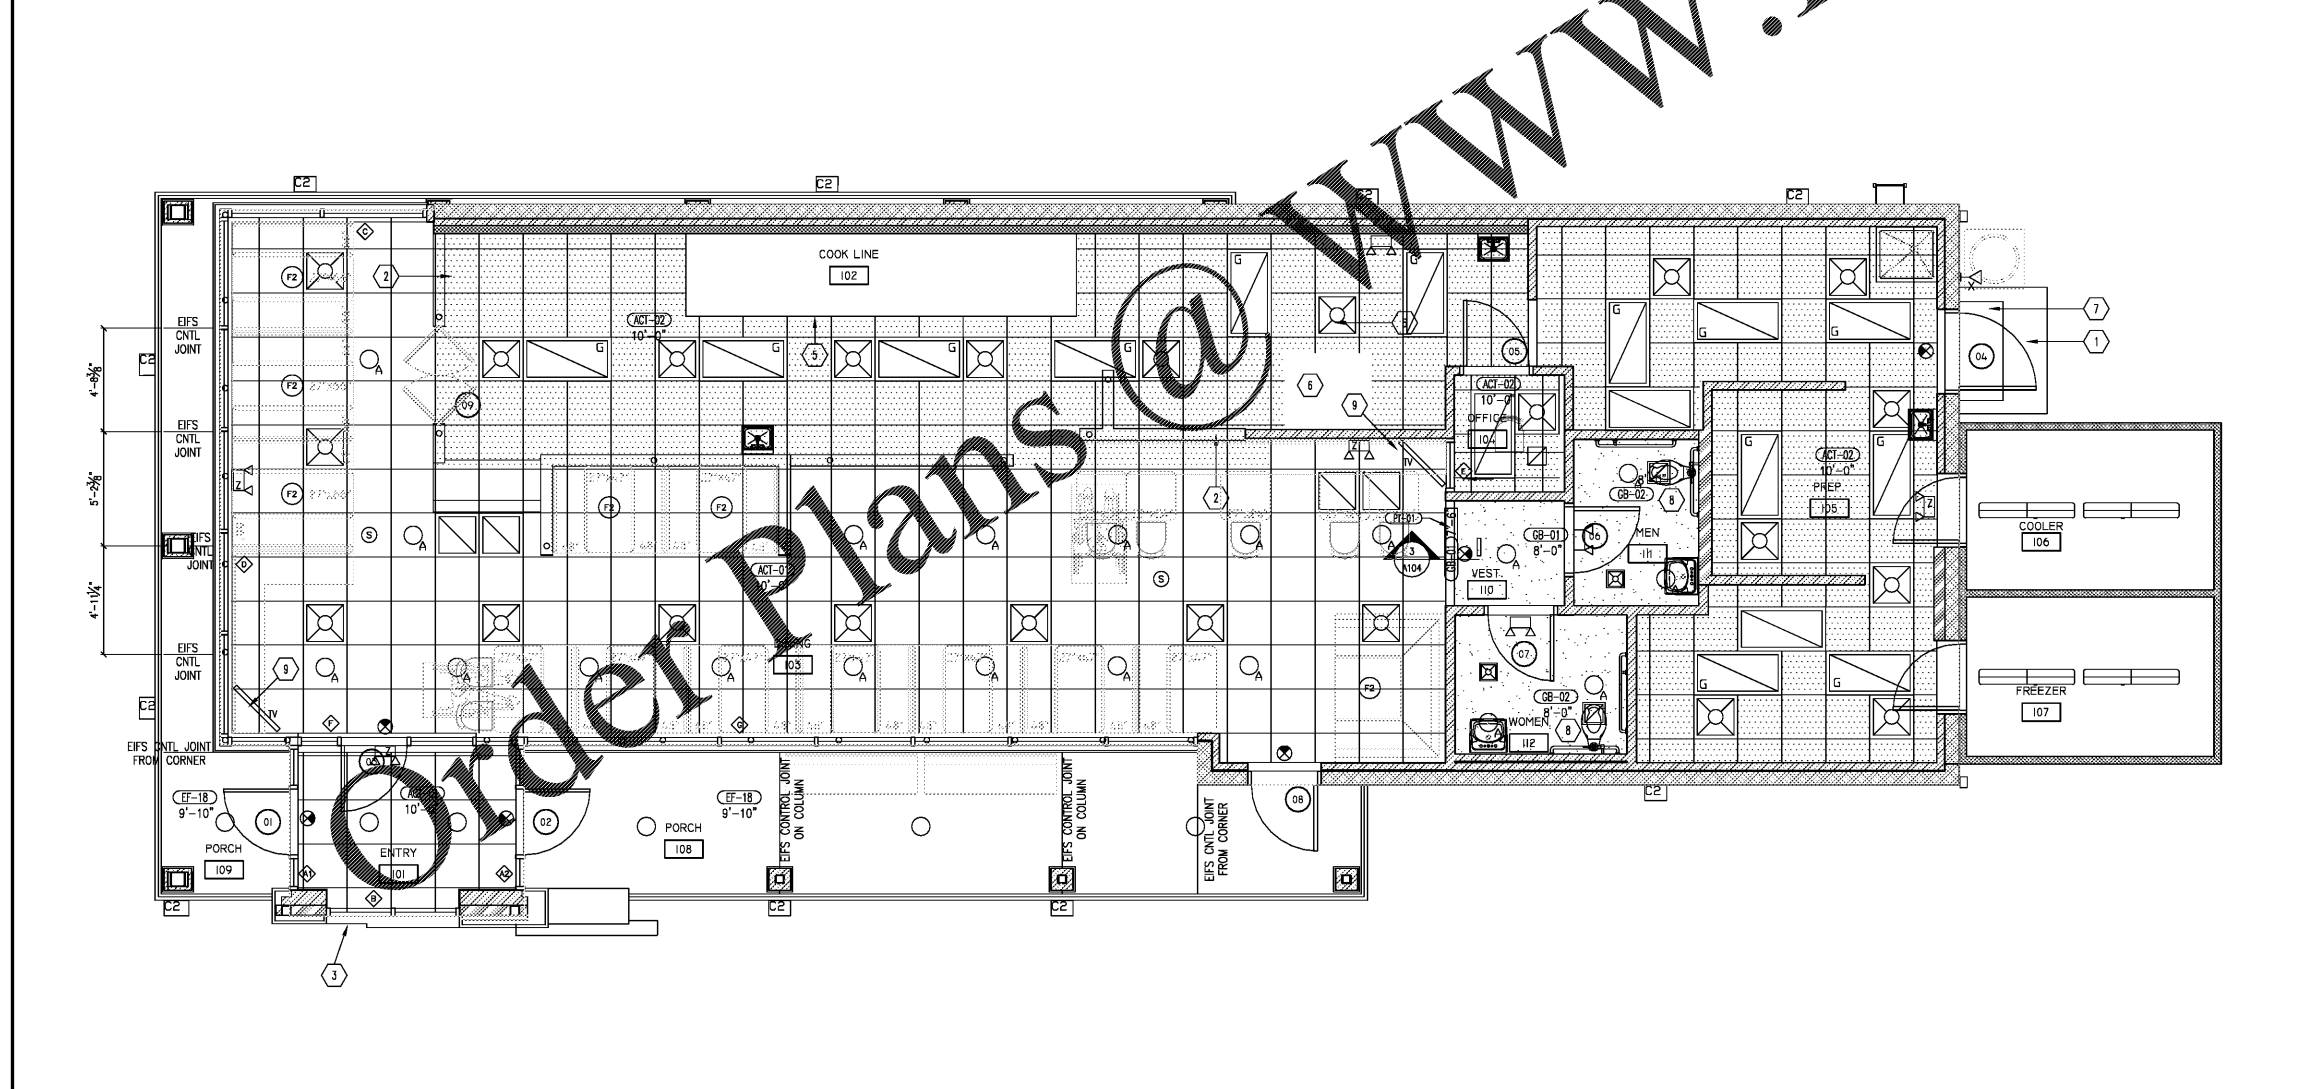

**1 REFLECTED CEILING PLAN**  
 SCALE: 1/4" = 1'-0"