

JOB NO.

NORWOOD ARCHITECTS
807 Torrence Blvd. NW
Atlanta, Georgia 30318
ph. 678-921-0302 fax. 678-921-0301
www.norwoodarchitects.com


HUDDLE HOUSE
EVO 2000 RESTAURANT
40 US HWY 84 CAIRO, GA
GRADY CO. 39828

NO.	ISSUE DATE

DRAWING NUMBER

E100

FLOOR PLAN - LIGHTING

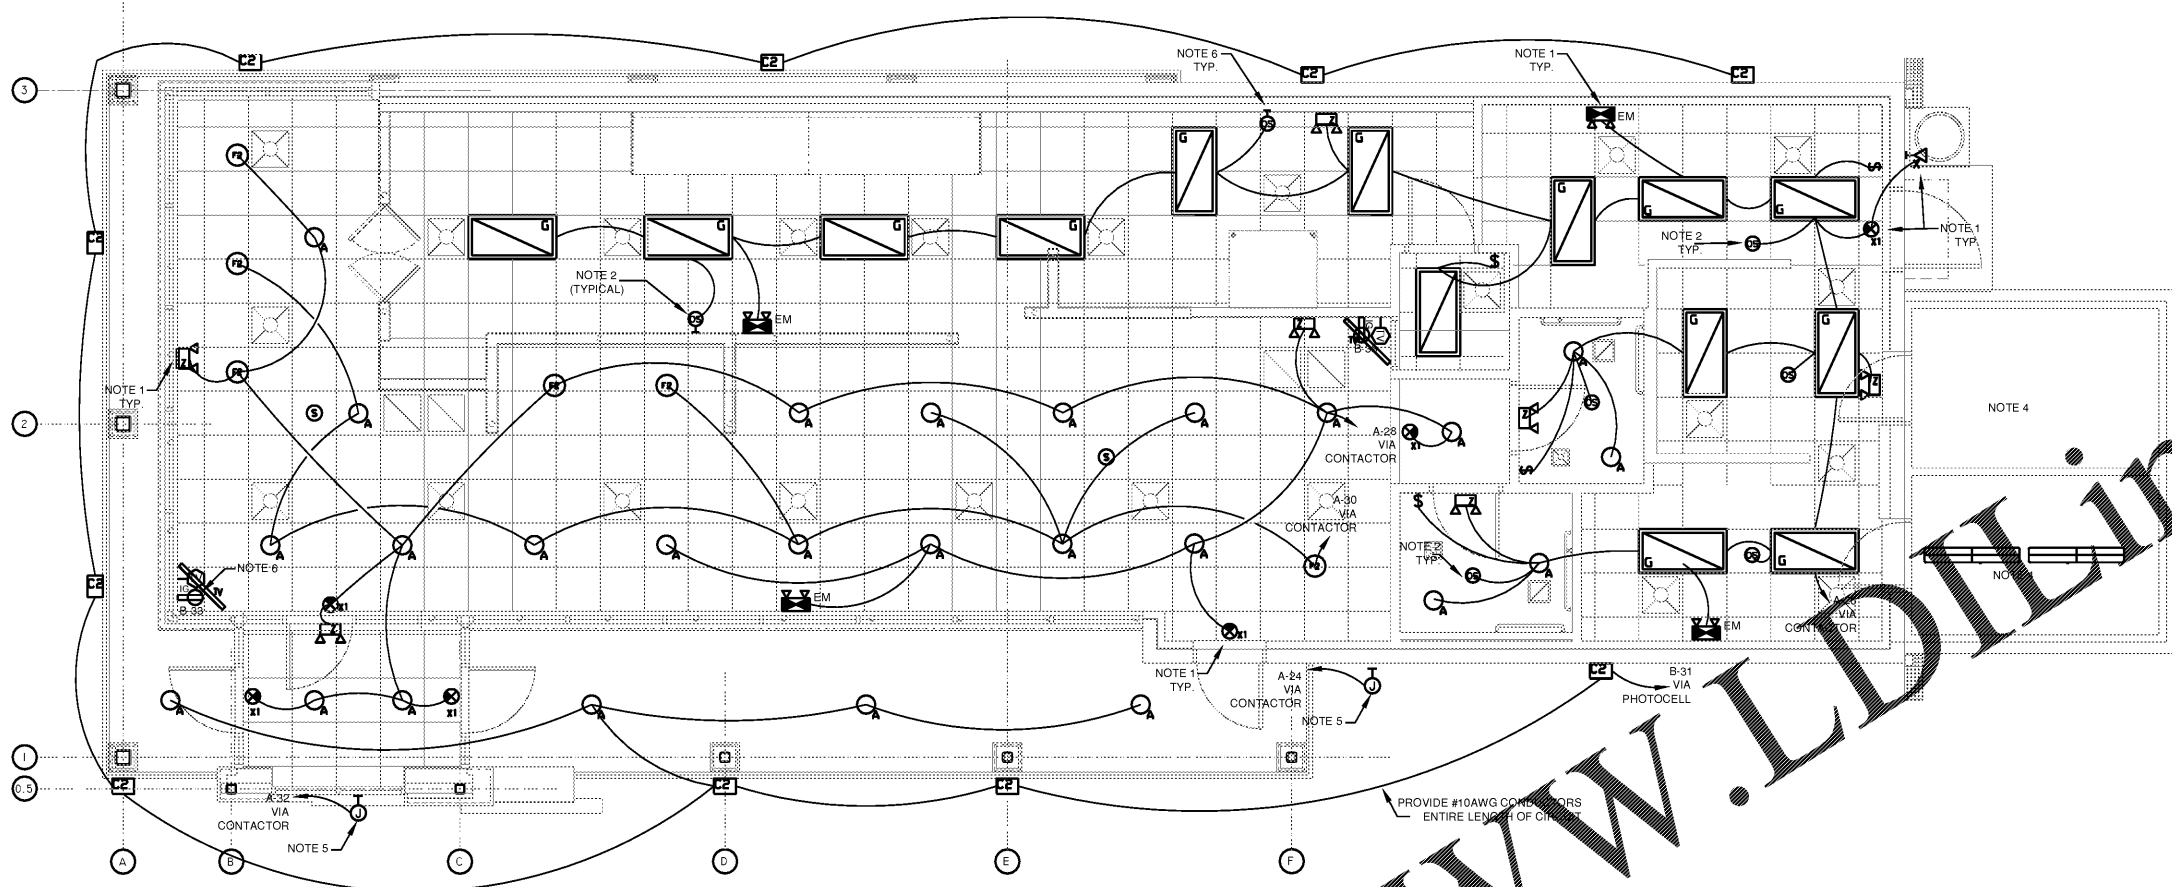

LIGHTING FLOOR PLAN
1/4" = 1'-0"

COMcheck Software Version 4.1.1.0
Interior Lighting Compliance Certificate

Project Information
Energy Code: 90.1 (2007) Standard
Project Name: HUDDLE HOUSE
Project Date: New Construction

Contributor: QUOC A. ALVAREZ
Owner/Client: HUDDLE HOUSE
Design/Contractor: NORWOOD ARCHITECTS

Area Category	Floor Area (SF)	Allowed Watts (W)	Actual Watts (W)	Compliance
Proposed Interior Lighting Power	1180	1180	2030	FAIL

Interior Lighting Compliance Statement
The proposed interior lighting design complies with the requirements of the International Energy Conservation Code (IECC) and the International Building Code (IBC) for the proposed project. The lighting design was prepared in accordance with the requirements of the International Energy Conservation Code (IECC) and the International Building Code (IBC) for the proposed project. The lighting design was prepared in accordance with the requirements of the International Energy Conservation Code (IECC) and the International Building Code (IBC) for the proposed project.

Project Name: HUDDLE HOUSE
Date: 08/20/2018
Page: 1 of 1

LIGHTING NOTES:

- PROVIDE NON-CONTACTED, NON-SWITCHED HOT CONDUCTOR OF SAME CIRCUIT TO EACH EMERGENCY LIGHTING FIXTURE, EXIT SIGN AND NIGHT LIGHT.
- PROVIDE CEILING MOUNTED OCCUPANCY SENSOR. LEVITON #00C10-MRW. SENSOR SHALL CONTROL RESTROOM LIGHTING AND LIGHTING EXHAUST FANS (F-3, F-4). LOCATION OF RESTROOM EXHAUST FANS SHOWN ON DRAWING E2.0.
- PROVIDE NEW ASTRONOMICAL TIMECLOCK FOR ALL EXTERIOR SIGNS. TORK CAT. NO. 7200 (OR EQUAL).
- FIXTURE PROVIDED WITH WALK-IN COOLER. CONTRACTOR TO PROVIDE POWER TO COOLER AS SPECIFIED IN KITCHEN EQUIPMENT SCHEDULE.
- PROVIDE DISCONNECT SWITCH UP HIGH AT SIGN FOR SIGNAGE CIRCUITS AS REQUIRED BY NEC 600. SIGNS SHALL BE RUN THROUGH A CONTACTOR. SEE DETAIL. COORDINATE REQUIREMENTS AND MOUNTING LOCATION WITH OWNER AND LANDLORD.
- OCCUPANCY SENSOR WALL SWITCH WHITE FINISH. LEVITON #OSW12-MDW. COORDINATE MANUAL TIME ADJUSTMENT TIME WITH OWNER.
- (WHEN NEEDED) COORDINATE HEIGHT OF TELEVISION POWER, RECEPTACLES, AND SIGNAL BOX WITH ARCHITECTURAL DRAWINGS. RECESS INTO CEILING WHEN TV IS NOT ADJACENT TO WALL.

NATIONAL ACCOUNTS HERMITAGE LIGHTING LIGHTING PACKAGE

NOTE: THE COMPLETE LIGHTING PACKAGE FOR THIS PROJECT CAN BE OBTAINED THROUGH HERMITAGE LIGHTING NATIONAL ACCOUNTS AS FOLLOWS:

70550 HERMES
HERMITAGE LIGHTING NATIONAL ACCOUNTS
HERMITAGE LIGHTING
3840 PROCDRIVE DR
DALLAS TEXAS 75204
1-800-294-3585

TYPE DESCRIPTION	VOLTS	LAMPS	CATALOG NUMBER	WATTAGE
G 2X4 FLAT PANEL LED TROFFER, 5000 LUMEN, 35K	MVOLT	INTEGRAL	ORACLE LIGHTING/ 24-FPL1-LED-5000L-DIM10-MVOLT-35K-85	50
A 6" APERTURE LED RECESSED DOWNLIGHT, DEEP RECESS 20 DEGREE SHIELD OPTION, DIMMABLE, GU-24 HOUSING, CRI = 90.	120V	LED 1000 LUMENS	CREE LR6-10L-35K-GU24/ HOUSING RC6-12W-GU24	10.5
B 6" APERTURE LED RECESSED WALLWASHER TYPE FIXTURE, .10 TO 30 DEGREE TILT, DIMMABLE, GU-24 HOUSING, CRI = 90.	120V	LED 500 LUMENS	CREE KR6-9L-35K-120V-10V TRIM: KR6T-SSGC-WF-WW	13
F1 3 LIGHT PENDANT, 6"X9" GLASS SHADE, CANOPY WITH BRUSHED STEEL FINISH, LED LAMPS.	120V	(3) 13W GU24	BESA T33XL, CHRISSEY 150918	30
F2 16" 'RUM' STYLE PENDANT, BRUSHED STEEL FINISH, 7" CORD.	120V	(1) 9W LED	HERMITAGE LIGHTING# 85312630	9
C2 LED HIGH OUTPUT TRADITIONAL WALL PACK	MVOLT	LED	SKU: E-WF08A SERIES	87
Z EMERGENCY WALL PACK FIXTURE WITH LED ADJUSTABLE HEADS, 90 MINUTE (MINIMUM) EM BATTERY BACK-UP	MVOLT	LED	EXTRONIX LED-90	2.2
X REMOTE DUAL EMERGENCY LED LAMP HEADS, WET LOCATION LISTED, THERMOPLASTIC HOUSING POWERED FROM REMOTE CAPABLE EM EXIT FIXTURE (X)	MVOLT	LED	EXTRONIX MLED2-G-WP	3
X1 EMERGENCY EXIT SIGN WITH BATTERY PACK, REMOTE CAPABILITY - EMERGENCY & EXIT, RED LETTERING, WHITE THERMOPLASTIC HOUSING, UNIVERSAL FACE, UNIVERSAL CANOPY - SIDE OR TOP.	MVOLT	LED	EXTRONIX I,X-R-EM-WH	2.2

- NOTES:
- CONTRACTOR TO CONSULT WITH LIGHTING MANUFACTURERS TO PROVIDE LL LABELING TO REFLECT ACTUAL LAMP WATTAGE USED, NOT MAX FIXTURE WATTAGE.
 - ALL RECESSED LIGHTING FIXTURES INSTALLED IN AN INSULATED CEILING SHALL BE I.C. RATED OR PROVIDED WITH SUITABLE PROTECTION.
 - REFER TO ARCHITECTURAL SHEETS FOR MOUNTING HEIGHTS OF LIGHTING FIXTURES AND ADDITIONAL INFORMATION.
 - COORDINATE EXACT MANUFACTURER, MODEL NUMBER, MOUNTING, LAMPS, COLORS AND FINISHES WITH ARCHITECT AND OWNER.
 - ALL LIGHTING SHALL BE ORDERED THROUGH HUDDLE HOUSE'S NATIONAL ACCOUNT WITH HERMITAGE LIGHTING.