

LIGHTING DESIGN BY CREE

LUMINAIRE SCHEDULE:

SYMBOL	QTY.	LABEL	ARRANGEMENT	LMF	LUM. LUMENS	LUM. WATTS	PART NUMBER
□	9	OSQ-HO-60D 50L	SINGLE	1.020	51790	420	OSQ-HO-A-NM-60D-50L-57K-xx-xx-xx

CALCULATION SUMMARY:

(FOOTCANDLES CALCULATED USING PREDICTED LUMEN VALUES @ 50K HRS OF OPERATION)

LABEL	UNITS	AVG.	MAX	MIN	AVG/MIN	MAX/MIN
CALC PTS	Fc	4.16	39.4	0.0	N/A	N/A
PARKING LOT ONLY	Fc	8.99	29.4	3.5	2.57	8.40

POLE SCHEDULE:

- (4) PS5530STxx 30' X 5" SQUARE STEEL POLES (+2.5' AFG BASE)
- (4) PB-2A5 TWIN TENONS
- (1) PW-1A3(5") MID-POLE BRACKET
- PROPOSED POLES MEET 90 MPH SUSTAINED WINDS.

 

ADDITIONAL EQUIPMENT:

- (9) OSQ-HO-AA-xx ADJUSTABLE ARMS

CUSTOMER TO VERIFY ORDERING INFORMATION AND CATALOGUE NUMBER PRIOR TO PLACING ORDER

Order Plans

WENDELL FORD EXPRESSWAY (US-60)
(RIGHT-OF-WAY VARIES)

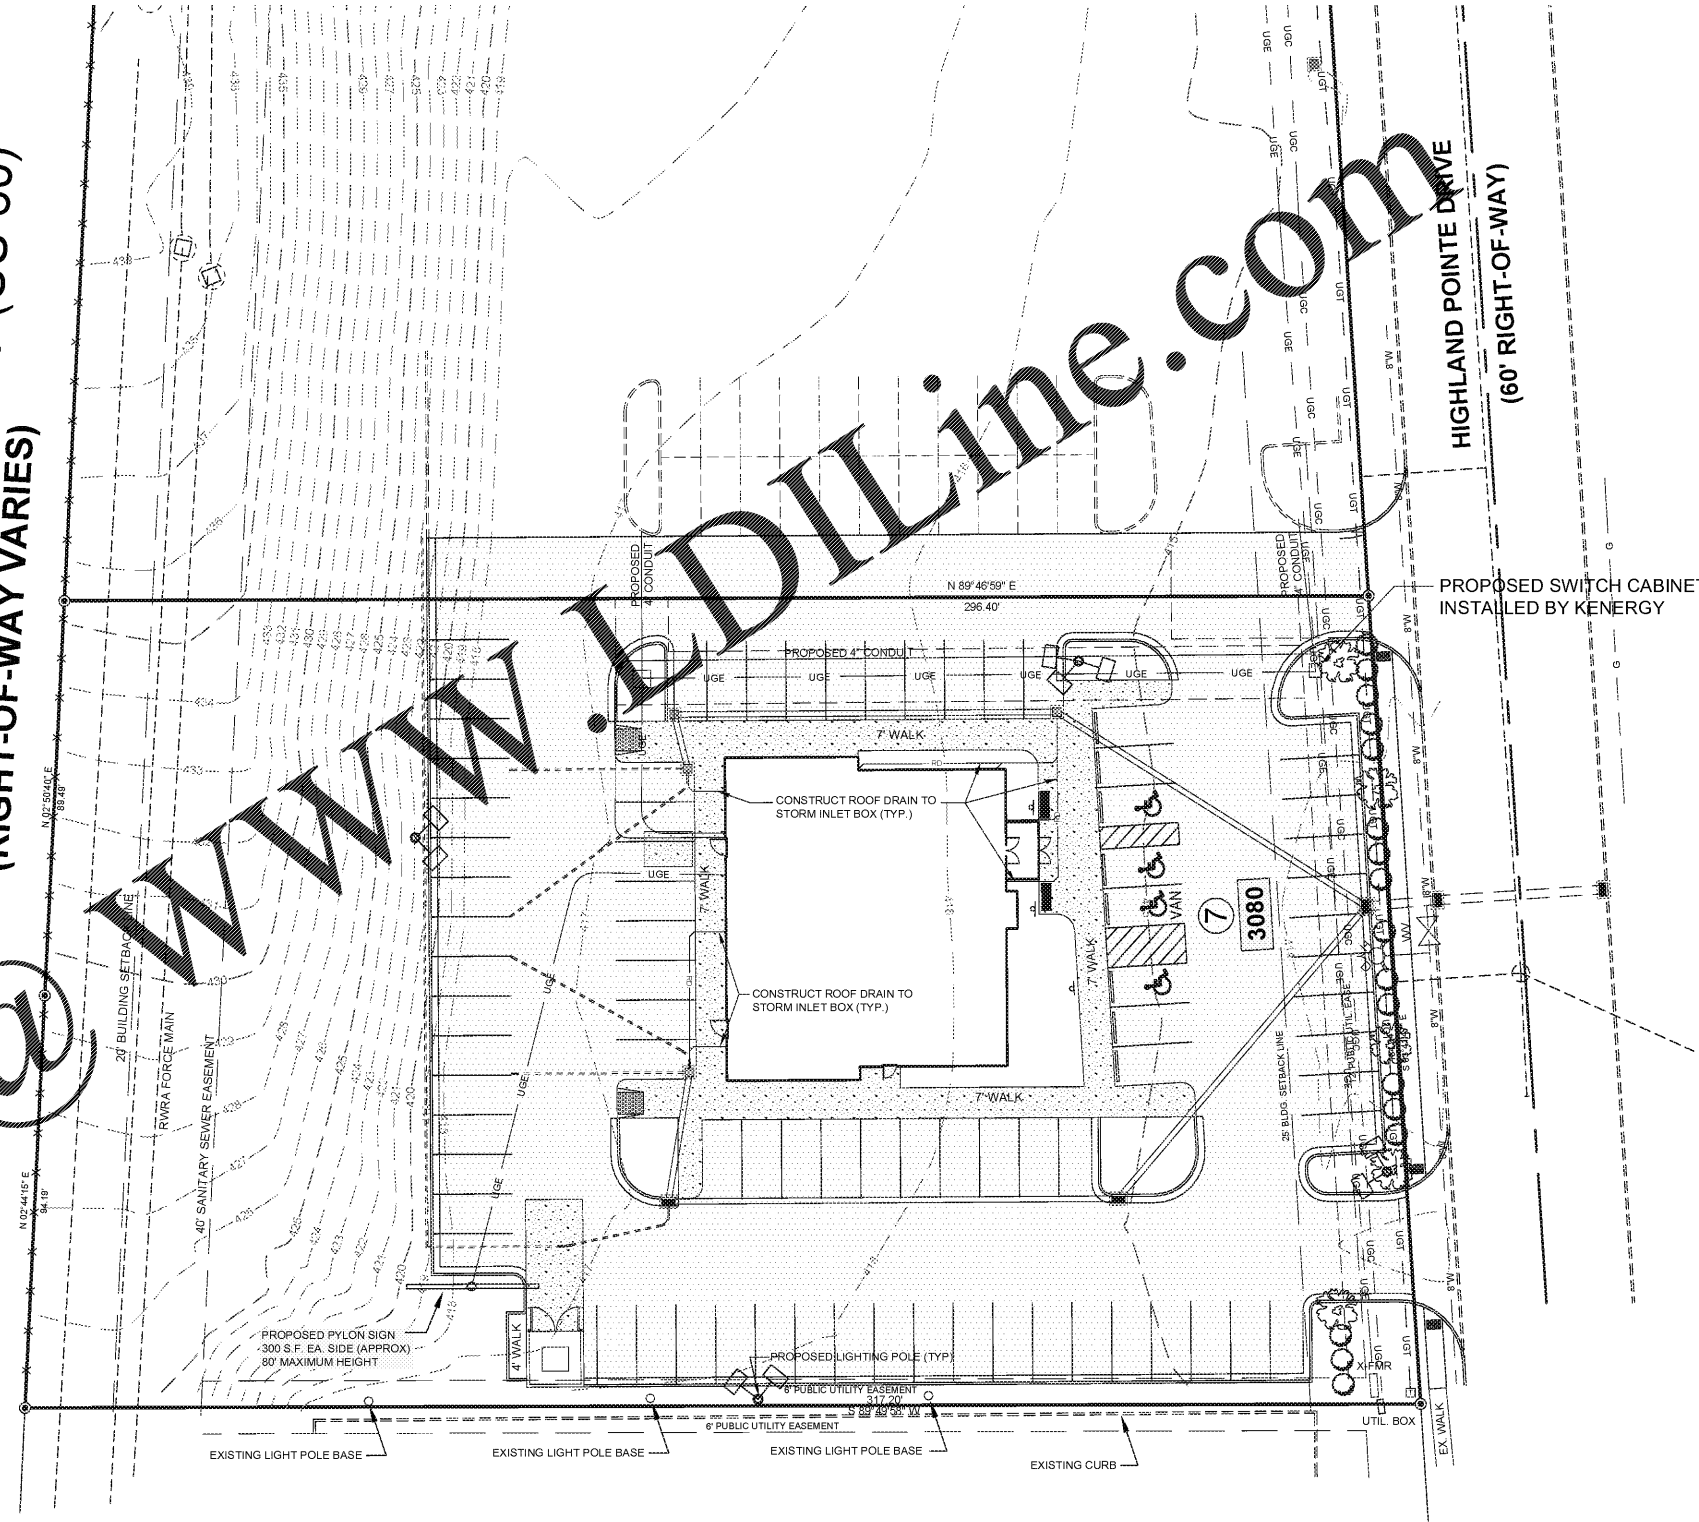

OWNER/DEVELOPER
RIVER ROAD RESTAURANT, LLC
417 MAIN STREET
NATCHEZ, MS 39120

REVISIONS			
NO.	DATE	DESCRIPTION	BY

LIGHTING PLAN

IHOP
3080 HIGHLAND POINTE DRIVE

DATE: MM-DD-YYYY
SCALE: 1"=20'
JOB NO.: 19-5953
SHEET
C4.1

