




THESE DRAWINGS AND DESIGNS ARE THE PROPERTY OF PROFICIENT ENGINEERING, INC. AND SHALL NOT BE REPRODUCED, COPIED, OR TRANSMITTED IN ANY FORM OR BY ANY MEANS, ELECTRONIC OR MECHANICAL, WITHOUT THE WRITTEN PERMISSION OF PROFICIENT ENGINEERING, INC. THESE DRAWINGS ARE PREPARED FOR USE ON THIS SPECIFIC PROJECT AND ARE NOT VALID FOR ANY OTHER PROJECT. ALL DIMENSIONS MUST BE VERIFIED BY THE CONTRACTOR AND DISCREPANCIES BEFORE PROCEEDING WITH CONSTRUCTION. DO NOT SCALE DRAWINGS.

Life Storage #357

115 S. Arrowhead Dr.  
Montgomery, AL 36117

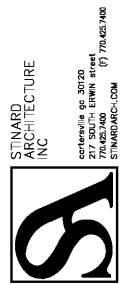

ISSUE FOR CONSTRUCTION REVISIONS:


NO.	DESCRIPTION

PROJECT NUMBER: 201841  
DATE: 4-8-2019

SHEET NUMBER: M1.1

- GENERAL NOTES**
- A. EACH SUPPLY DIFFUSER/REGISTER RUNOUT SHALL BE PROVIDED WITH A VOLUME DAMPER. REFER TO THE DIFFUSER TAKE-OFF DETAIL FOR ADDITIONAL INFORMATION.
  - B. DRAWINGS ARE DIAGRAMMATIC ONLY; FINAL ROUTING OF DUCTWORK AND EQUIPMENT LOCATIONS SHALL BE DETERMINED IN THE FIELD. ADDITIONAL OFFSETS, ELBOWS, ETC. SHALL BE PROVIDED AND INSTALLED WITHOUT ADDITIONAL COST TO THE OWNER.
  - C. COORDINATE LOUVER LOCATIONS WITH ARCHITECTURAL ELEVATIONS.

- KEYNOTES**
- ① CONDENSATE RISER 1. REFER TO CONDENSATE RISER 1 DETAIL ON SHEET MO.2.
  - ② CONDENSATE RISER 2. REFER TO CONDENSATE RISER 2 DETAIL ON SHEET MO.2.
  - ③ EXHAUST DUCT ROUTED TO WALL CAP, WALL CAP COLOR AND FINISH SHALL BE SELECTED BY ARCHITECT.
  - ④ TAP & ROUTE 1" CONDENSATE DRAIN LINE TO SPLASH PAN(S) ON CEILING.

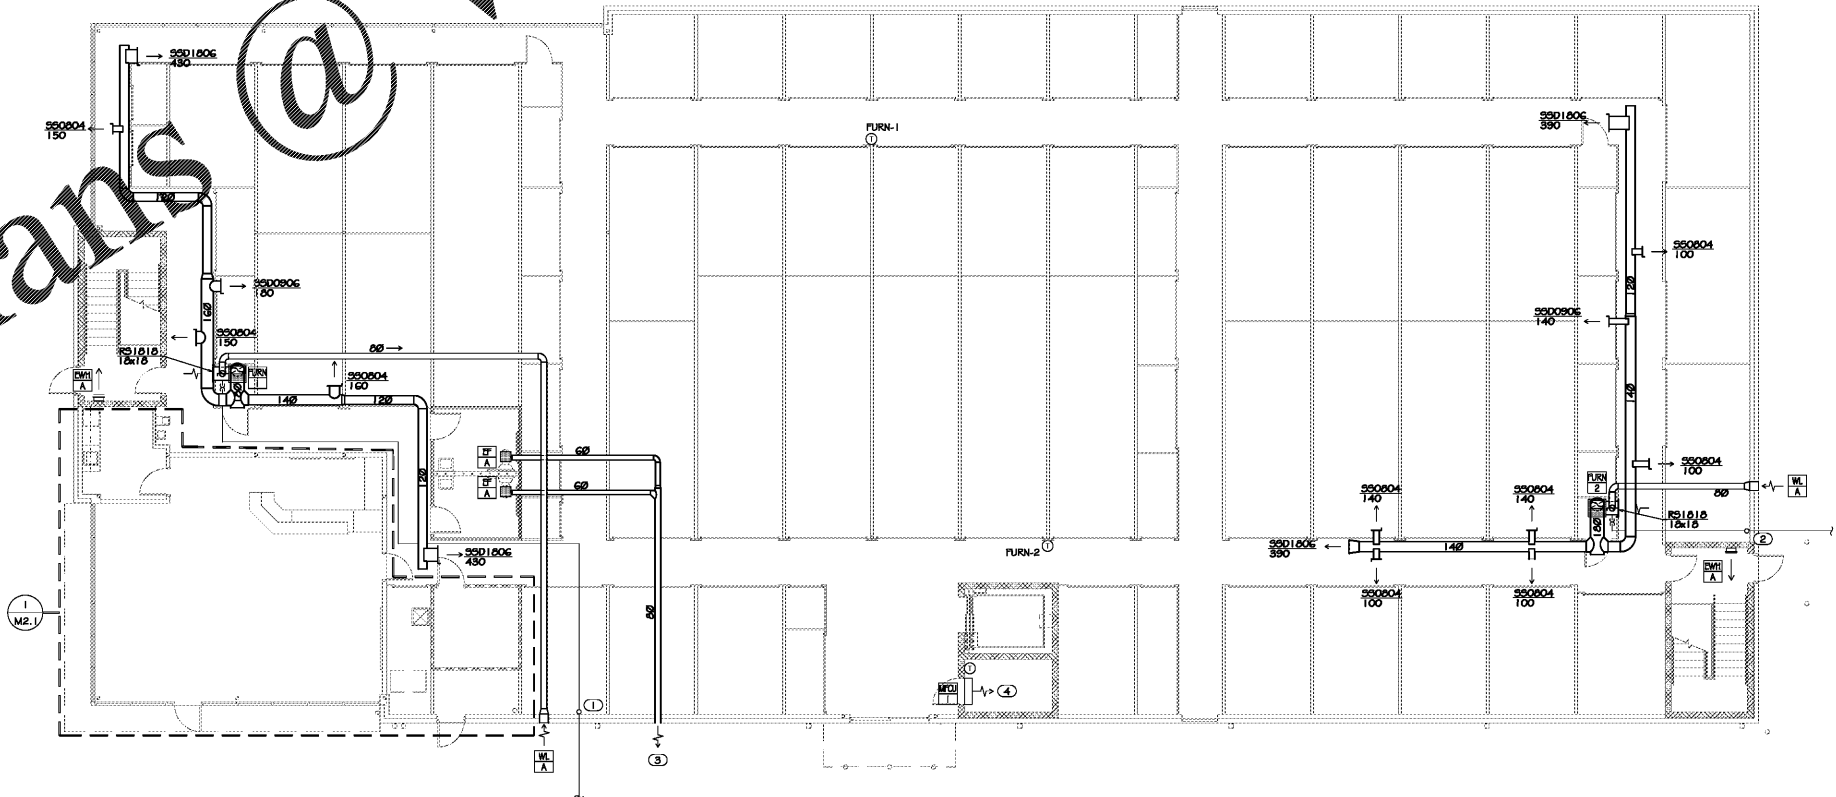

1 FIRST FLOOR PLAN  
M1.1 SCALE: 1/8"=1'-0"

Order Plans @ [www.LDILine.com](http://www.LDILine.com)