


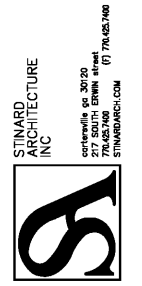

THESE DRAWINGS AND DESIGNS ARE THE PROPERTY OF STINARD ARCHITECTURE, INC. AND SHALL NOT BE REPRODUCED OR TRANSMITTED IN ANY FORM OR BY ANY MEANS, ELECTRONIC OR MECHANICAL, INCLUDING PHOTOCOPYING, RECORDING, OR BY ANY INFORMATION STORAGE AND RETRIEVAL SYSTEM, WITHOUT THE WRITTEN PERMISSION OF STINARD ARCHITECTURE, INC. THESE DRAWINGS AND DESIGNS ARE NOT TO BE USED FOR ANY OTHER PROJECT OR DATE AND ARE NOT SUITABLE FOR USE IN ANY OTHER JURISDICTION. ALL DIMENSIONS MUST BE VERIFIED BY THE CONTRACTOR AND DISCREPANCIES BEFORE PROCEEDING WITH CONSTRUCTION. DO NOT SCALE DRAWINGS.

Life Storage #357

115 S. Arrowhead Dr.  
Montgomery, AL 36117




ISSUE FOR CONSTRUCTION REVISIONS	
1	City Comments 5-6-2019


PROJECT NUMBER  
201841  
DATE  
4-8-2019

SHEET NUMBER  
**P1.1**


- KEYNOTES**
- 1 2" PD DN TO ELEVATOR SUMP PUMP (SEE DETAIL)
  - 2 6" SPRINKLER MAIN B.G. SEE CIVIL DRAWING FOR CONTINUATION AND BACKFLOW PREVENTER
  - 3 1" DOMESTIC WATER SERVICE B.G. SEE CIVIL DWG FOR CONT
  - 4 4" S B.G. SEE CIVIL DWG FOR CONT
  - 5 1" DOMESTIC WATER SERVICE UP WITH SHUTOFF VALVE & PRESSURE GAUGE. PROVIDE PRESSURE REDUCING VALVE IF INCOMING PRESSURE EXCEEDS 60PSI.
  - 6 6" SPRINKLER MAIN DM & STUB UP. SPRINKLER DESIGN BY SPRINKLER CONTRACTOR.
  - 7 CW & HW DN
  - 8 CW DN
  - 9 CW & HW DN TO STAND MOUNTED WATER HEATER, SEE DETAIL
  - 10 2" V DN
  - 11 2" PD DN & DISCHARGE TO MOP SINK WITH AIR GAP
  - 12 3" V UP
  - 13 NATURAL GAS SERVICE B.G. SEE CIVIL DWG FOR CONT
  - 14 NATURAL GAS A/C & DN ON EXTERIOR WALL TO NATURAL GAS METER INSTALLATION (FIELD VERIFY EXACT LOCATION. COORDINATE INSTALLATION OF NEW METER ASSEMBLY WITH NATURAL GAS PROVIDER). SEE RISER DIAGRAM FOR PIPE SIZING AND DESIGN CRITERIA.
  - 15 NATURAL GAS CONNECTION TO FURNACE W/SHUTOFF VALVE, DIRT LEG, PRESSURE REDUCING VALVE & UNION. LABEL PIPING "2PSI NATURAL GAS" AT REGULATORS
  - 16 6" ST FROM ABOVE AND TRANSITION TO 6" ST IN HORIZONTAL. DISCHARGE EXTERIOR WALL & DISCHARGE ST INTO GRADE.
  - 17 4" S DN

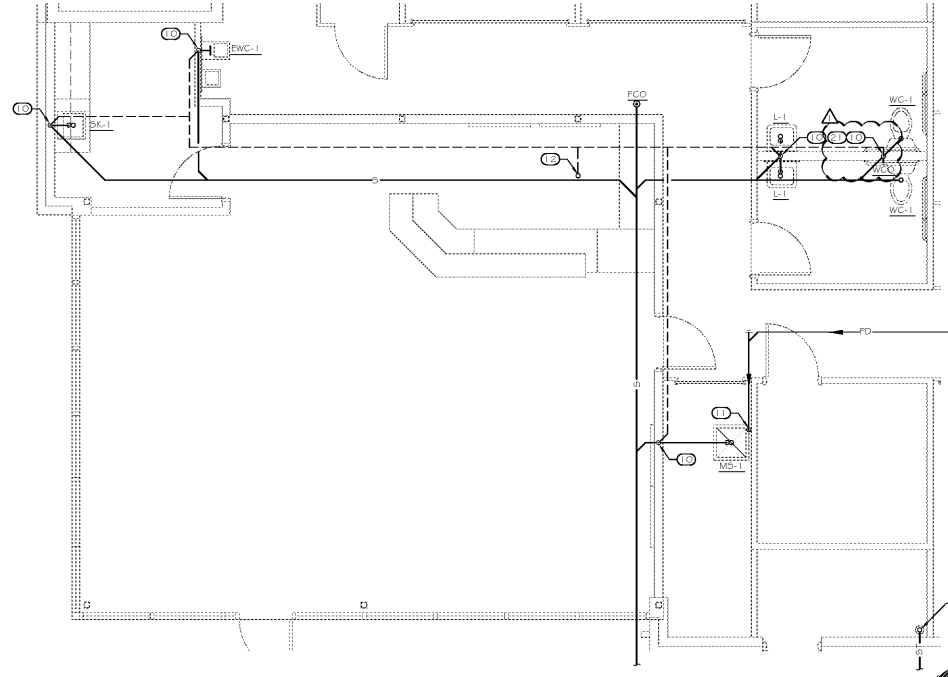

3 ENLARGED PLAN - WASTE & VENT  
P1.1 SCALE: 1/4"=1'-0"

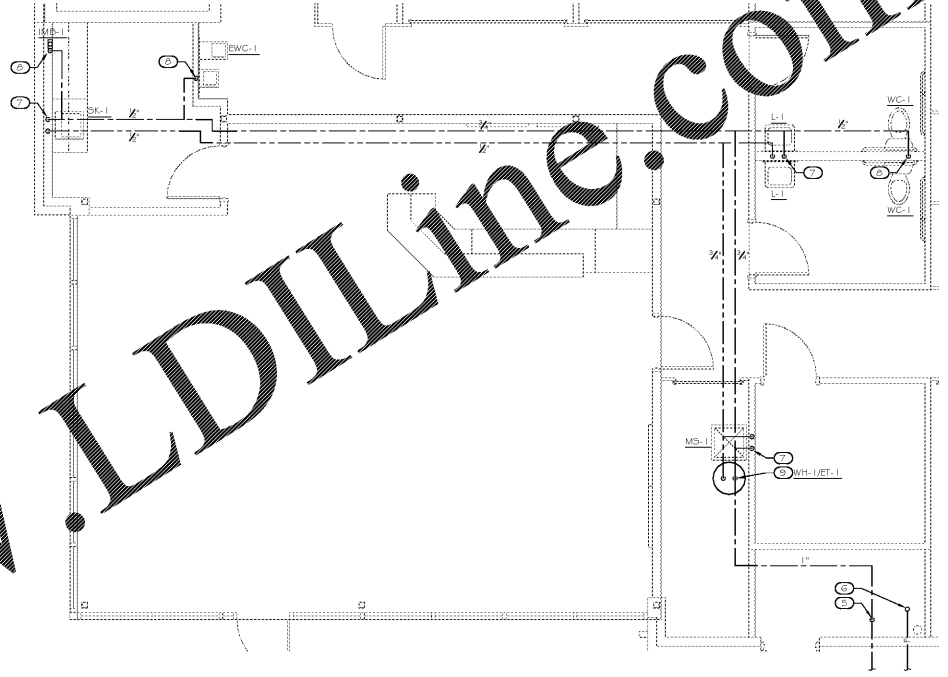

2 ENLARGED PLAN - WATER  
P1.1 SCALE: 1/4"=1'-0"

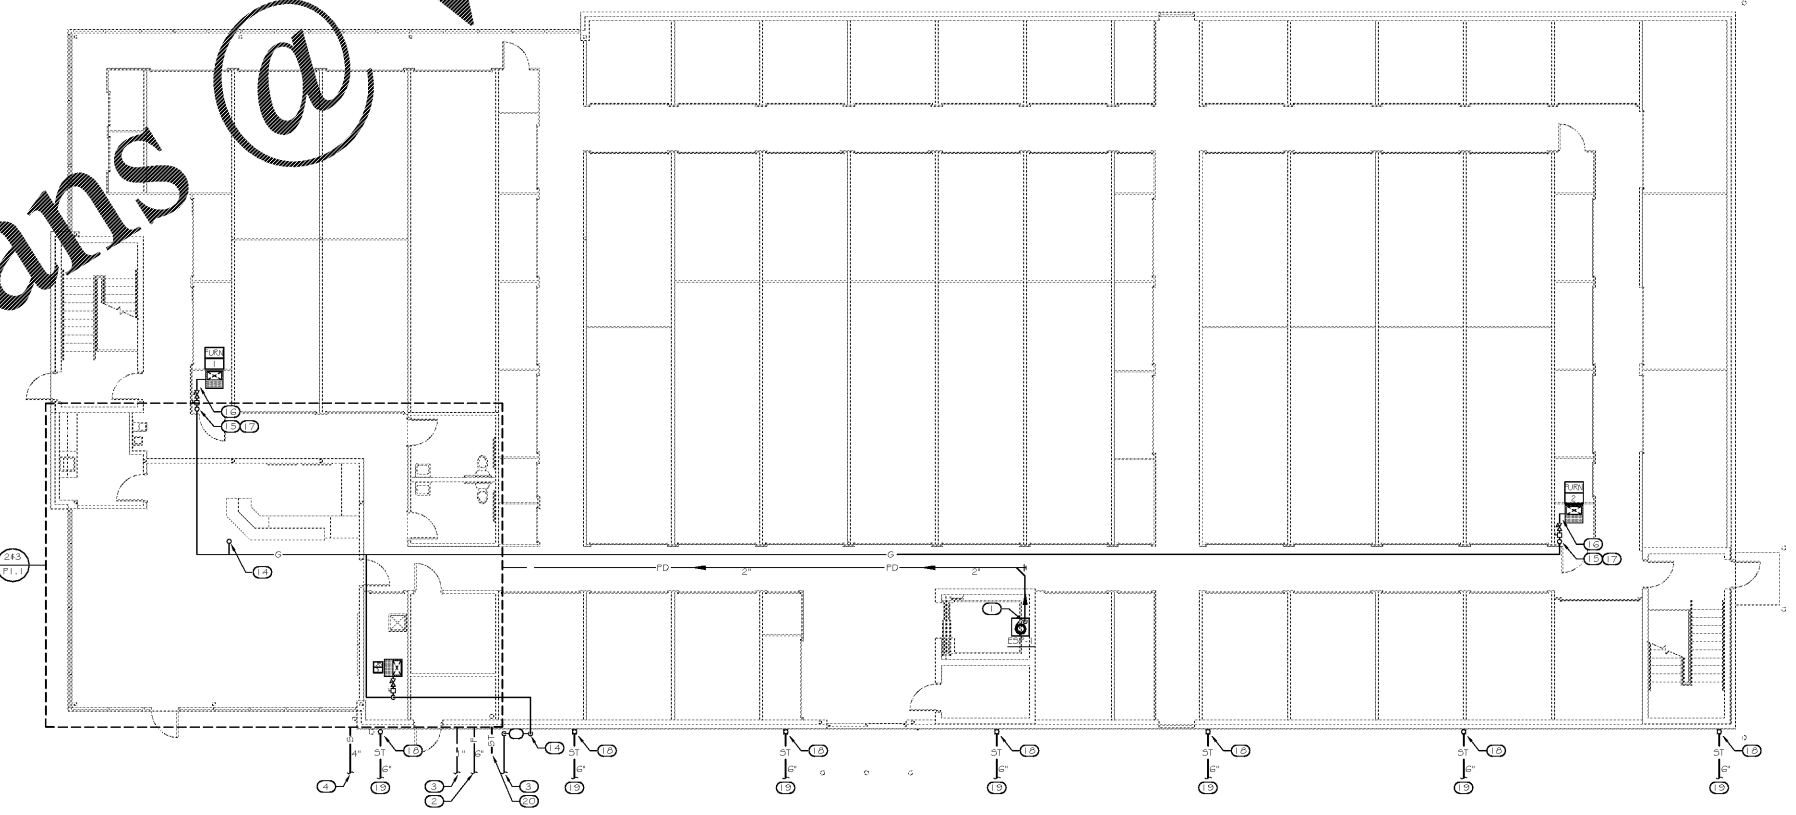

1 FIRST FLOOR PLAN  
P1.1 SCALE: 1/8"=1'-0"

Order Plans @

WWW.LDILine.com