


Order Plans @ [www.LDILine.com](http://www.LDILine.com)

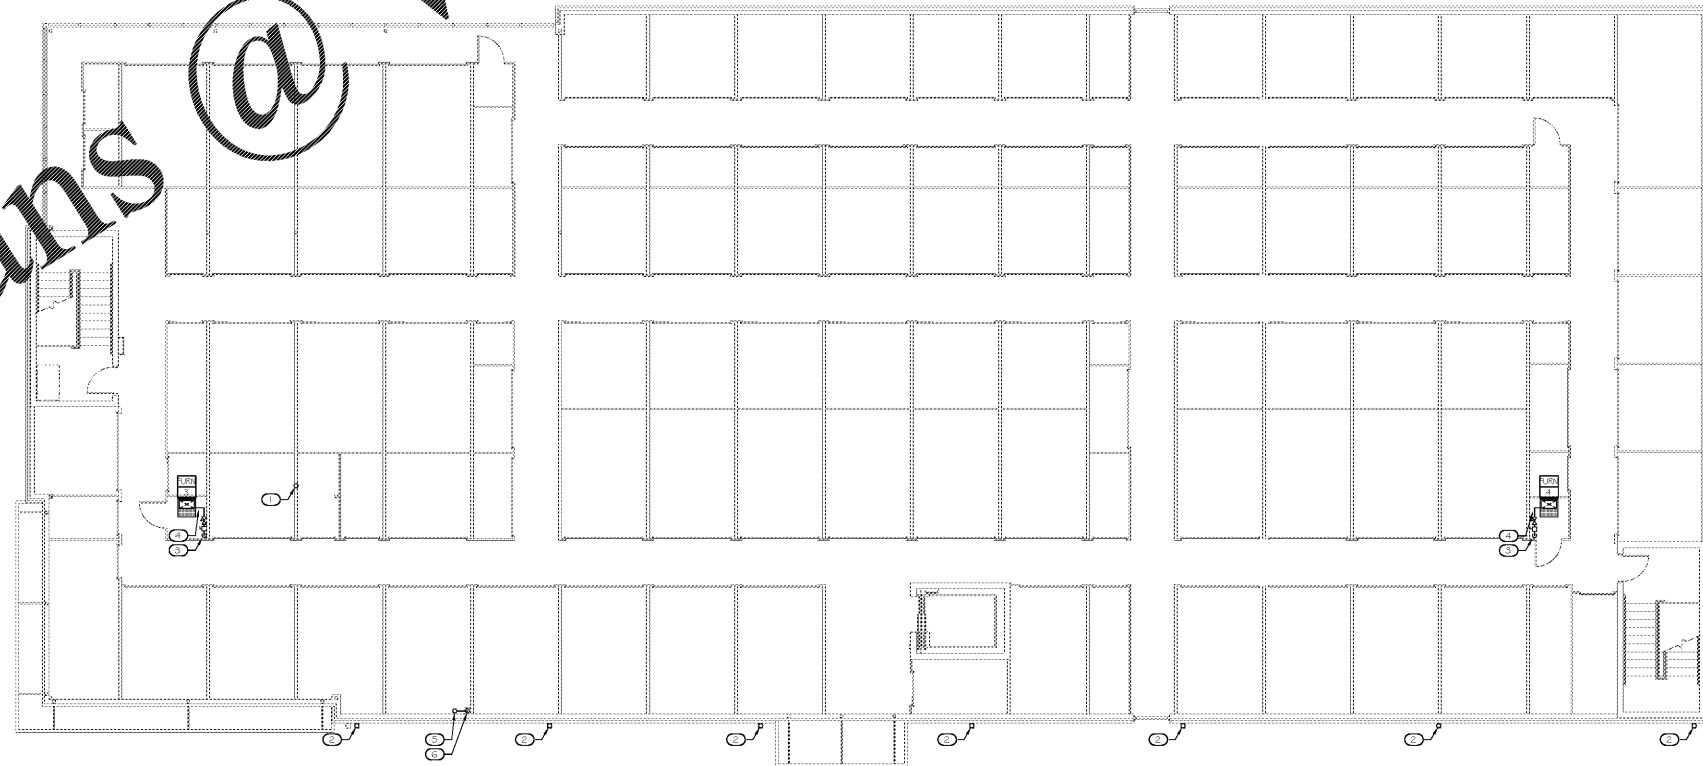


1 SECOND FLOOR PLAN  
P1.2 SCALE: 1/8"=1'-0"

- KEYNOTES
- 1 3" V STACK UP TO 3" VTR
  - 2 6" X 6" DOWNSPOUT DN
  - 3 NATURAL GAS DN
  - 4 NATURAL GAS CONNECTION TO FURNACE W/SHUTOFF VALVE, DIRT LEG, PRESSURE REDUCING VALVE & UNION
  - 5 6" ST UP ON INTERIOR WALL FROM ABOVE. TRANSITION TO 6" ST IN HORIZONTAL INC.
  - 6 6" ST DN ON INTERIOR WALL



THESE DRAWINGS AND DESIGNS ARE THE PROPERTY OF STINARD ARCHITECTURE, INC. AND SHALL NOT BE REPRODUCED OR TRANSMITTED IN ANY FORM OR BY ANY MEANS, ELECTRONIC OR MECHANICAL, INCLUDING PHOTOCOPYING, RECORDING, OR BY ANY INFORMATION STORAGE AND RETRIEVAL SYSTEM, WITHOUT THE WRITTEN PERMISSION OF STINARD ARCHITECTURE, INC. THESE DRAWINGS AND DESIGNS ARE NOT TO BE USED FOR ANY OTHER PROJECT OR DATE AND ARE NOT SUITABLE FOR USE IN ANY OTHER MANNER. ALL DIMENSIONS MUST BE VERIFIED BY THE CONTRACTOR AND DISCREPANCIES BEFORE PROCEEDING WITH CONSTRUCTION. DO NOT SCALE DRAWINGS.

Life Storage #357  
115 S. Arrowhead Dr.  
Montgomery, AL 36117

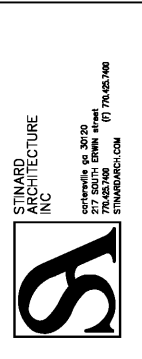

ISSUE FOR CONSTRUCTION REVISIONS:


PROJECT NUMBER: 201841  
DATE: 4-8-2019

SHEET NUMBER: P1.2