


Order Plans @ [www.LDILine.com](http://www.LDILine.com)

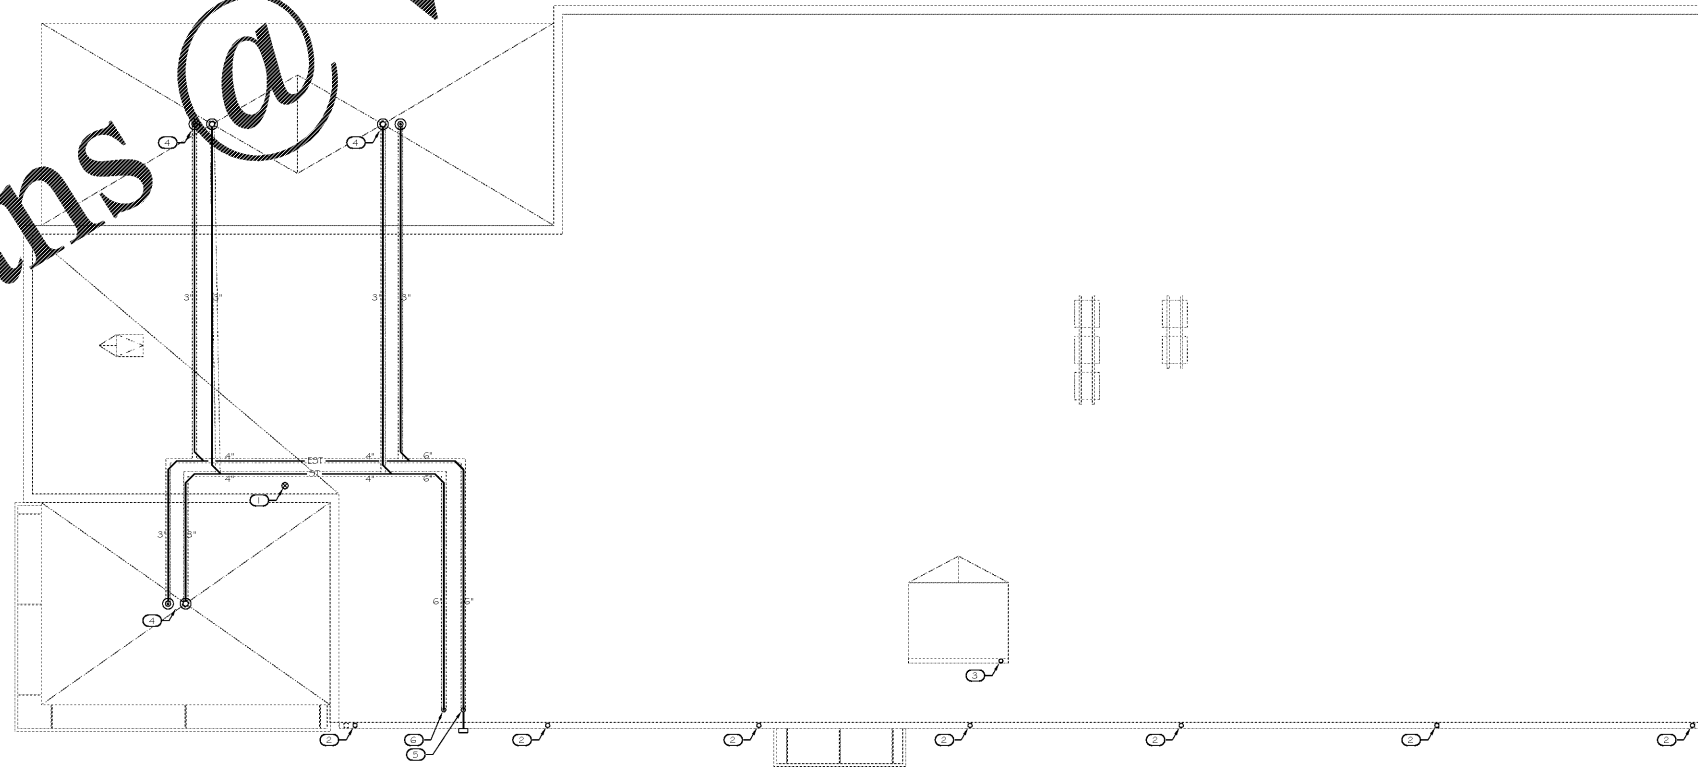

1 ROOF PLAN  
P1.3 SCALE: 1/8"=1'-0"


- KEYNOTES
- 1 3" VTR
  - 2 6" X 6" DOWNSPOUT DN FROM 6" X 6" HORIZONTAL GUTTER. †
  - 3 4" X 4" DOWNSPOUT DN FROM 6" X 6" HORIZONTAL GUTTER. † DISCHARGE ONTO ROOF BELOW.
  - 4 3" ROOF DRAIN RD-1, † 3" EMERGENCY ROOF DRAIN EED-1, TRANSITION TO 3" HORIZONTAL.
  - 5 ROUTE 6" EST @ X/YFT TO INTERIOR WALL, DROP DN ALONG INTERIOR WALL AND DISCHARGE WITH DOWNSPOUT NOZZLE, DON-1.
  - 6 ROUTE 6" ST @ X/YFT TO INTERIOR WALL, DROP DN ALONG INTERIOR WALL.



THESE DRAWINGS AND DESIGNS ARE THE PROPERTY OF PROFICIENT ARCHITECTURE, INC. AND SHALL NOT BE REPRODUCED OR TRANSMITTED IN ANY FORM OR BY ANY MEANS, ELECTRONIC OR MECHANICAL, WITHOUT THE WRITTEN PERMISSION OF PROFICIENT ARCHITECTURE, INC. THESE DRAWINGS AND DESIGNS ARE NOT TO BE USED FOR ANY OTHER PROJECT WITHOUT THE WRITTEN PERMISSION OF PROFICIENT ARCHITECTURE, INC. ALL DIMENSIONS MUST BE VERIFIED BY THE CONTRACTOR AND DISCREPANCIES BEFORE PROCEEDING WITH CONSTRUCTION. DO NOT SCALE DRAWINGS.

Life Storage #357

115 S. Arrowhead Dr.  
Montgomery, AL 36117

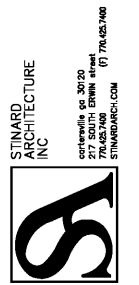

ISSUE FOR CONSTRUCTION REVISIONS:


PROJECT NUMBER  
201841  
DATE  
4-8-2019

SHEET NUMBER  
P1.3