



- NOTES:
- TYPICAL LAYOUT FOR APT XP PRODUCT PIPING - SEE SITE PLAN FOR TANK/CANOPY LAYOUTS; LOCATE PIPING RUNS ACCORDINGLY.
 - FINAL LOCATION OF DIESEL DISPENSERS TO BE VERIFIED WITH WAWA PROJECT MANAGER. SEE SITE PLAN FOR SPECIFIC DIESEL FUELING LOCATIONS. ALL MPDs IN FLORIDA SHALL BE 3+1 DISPENSERS.
 - VERIFY ALL PIPING WITH WAWA PROJECT MANAGER PRIOR TO INSTALLATION.

(A) TYPICAL PIPING RUNS
G-3 SCALE: 1" = 30'-0"

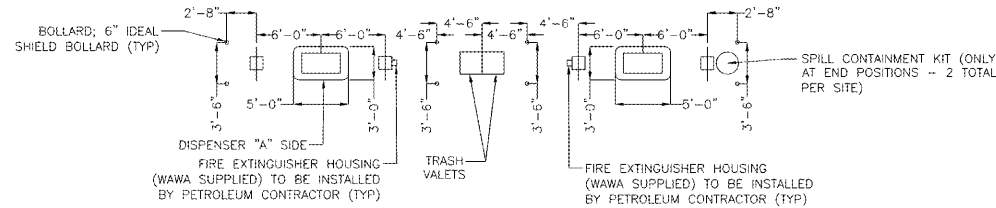


- NOTES:
- VERIFY WITH BUILDING/ CANOPY DRAWINGS BY ARCHITECT (NOT FOR CONSTRUCTION)
 - BOLLARDS BETWEEN DISPENSERS SHALL BE PROVIDED AT END POSITIONS ONLY (VERIFY PLAN WITH LAYOUT).


(B) ISLAND PLAN
G-3 SCALE: 1/8" = 1'-0"

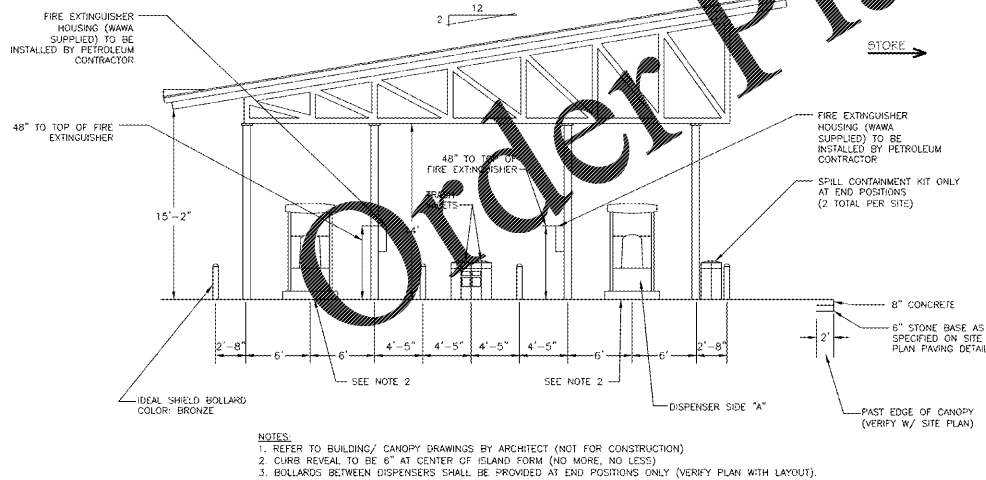


(C) CANOPY ELEVATION
G-3 SCALE: 1/8" = 1'-0"

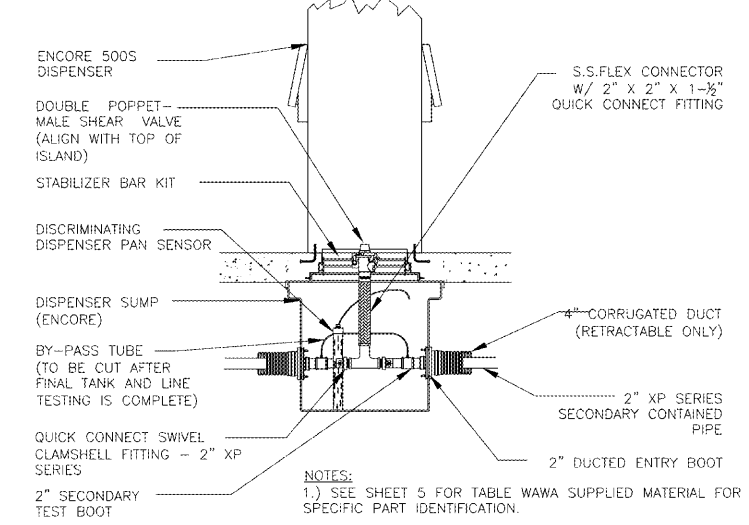


(D) SIDE VIEW DISPENSER SUMP - INLINE
G-3 SCALE: 3/4" = 1'-0"

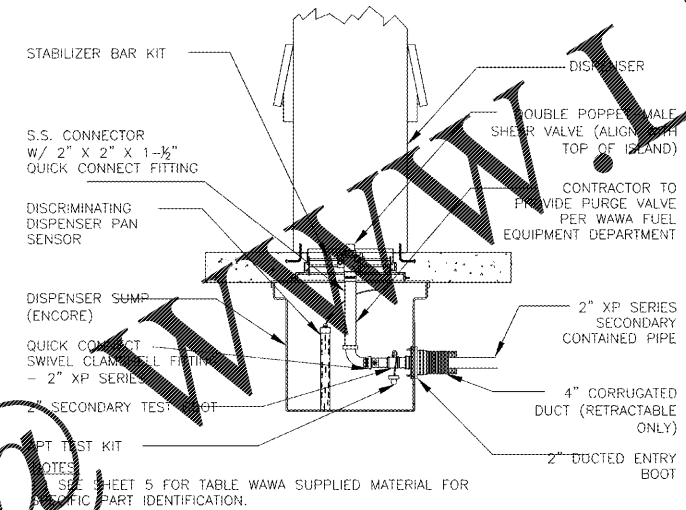


(E) SIDE VIEW DISPENSER SUMP - TERMINATING
G-3 SCALE: 3/4" = 1'-0"

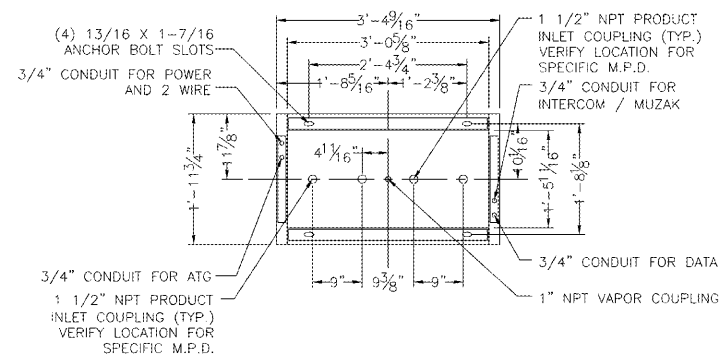


(F) DISPENSER BASE DIMENSIONS
G-3 SCALE: 3/4" = 1'-0"

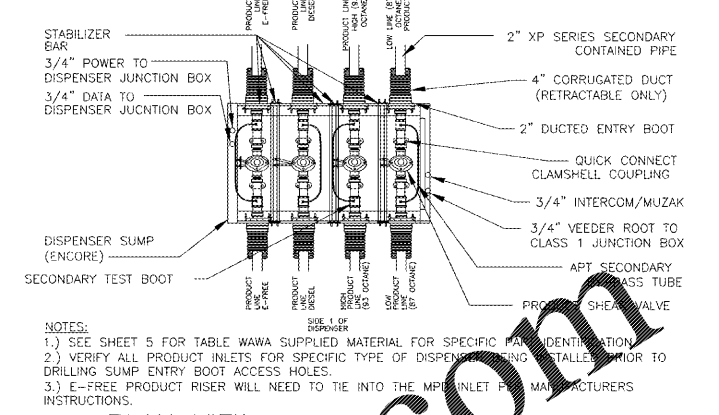

(G) PLAN VIEW DISPENSER SUMP - INLINE (3+1)
G-3 SCALE: 3/4" = 1'-0"

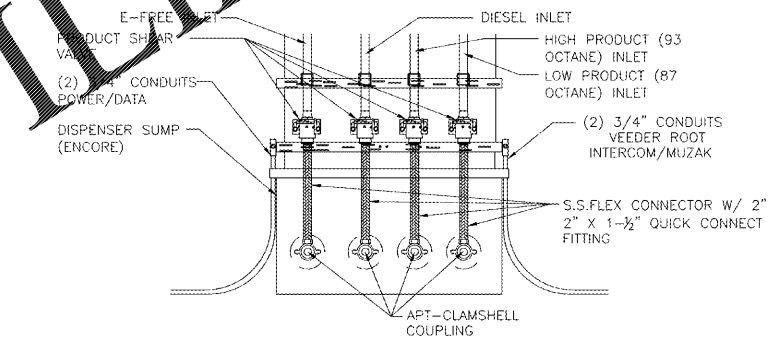

(H) DISPENSER SUMP - SECTION VIEW (3+1)
G-3 SCALE: 3/4" = 1'-0"

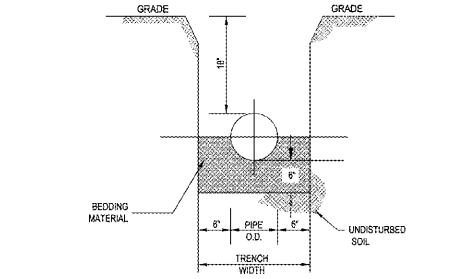

(I) PIPE TRENCH DETAIL
G-3 SCALE: 3/4" = 1'-0"

BOHLER ENGINEERING

SITE CIVIL AND CONSULTING ENGINEERING ANALYSIS FOR SITE SUSTAINABLE DESIGN HYDRAULIC SERVICES TRANSPORTATION SERVICES

RALEIGH, NC
CHARLOTTE, NC
DALLAS, TX
FORT WORTH, TX
HOUSTON, TX
MIAMI, FL
MIAMI BEACH, FL
NEW YORK, NY
NEW YORK, NY
PHILADELPHIA, PA
RICHMOND, VA
ROANOKE, VA
SOUTH BEND, IN
TAMPA, FL
TAMPA, FL
TAMPA, FL
TAMPA, FL
TAMPA, FL

REVISIONS

REV	DATE	COMMENT	BY

811 KNOW WHAT'S BELOW ALWAYS CALL 811 BEFORE YOU DIG

www.callsunshine.com

APPROVED FOR CONSTRUCTION

PROJECT No. FLB180067
DRAWN BY: DH
CHECKED BY: CR
DATE: 08/30/18
SCALE: AS NOTED
CAD.D: FTS

PROJECT: SITE CONSTRUCTION DRAWINGS FOR WAWA

LOCATION OF SITE
3300 NW 87TH AVENUE
MIAMI, FL

BOHLER ENGINEERING

2255 GLADES ROAD, SUITE 305E
BOCA RATON, FLORIDA 33431

Phone: (561) 571-0280
Fax: (561) 571-0281
FLORIDA BUSINESS CERT. OF AUTH. No. 00790
100350450 PROJECT REGISTERED UNDER REG. NO. 0079000000

CHRISTOPHER CAPELLINI

No. 83025

STATE OF FLORIDA
PROFESSIONAL ENGINEER

01/02/2019

SHEET TITLE: TANK DETAILS STACKED 8 SLOPED ROOF

SHEET NUMBER: G-3