


GRAPHIC SCALE 1/8"=1'-0"


GRAPHIC SCALE 1/8"=1'-0"

GRAPHIC SCALE 1/8"=1'-0"

THIS DRAWING IS NOT TO BE SCALED FOR DIMENSION PURPOSES. THE SCALE WHICH APPLIES TO THIS DRAWING IS FOR GENERAL REFERENCE ONLY.

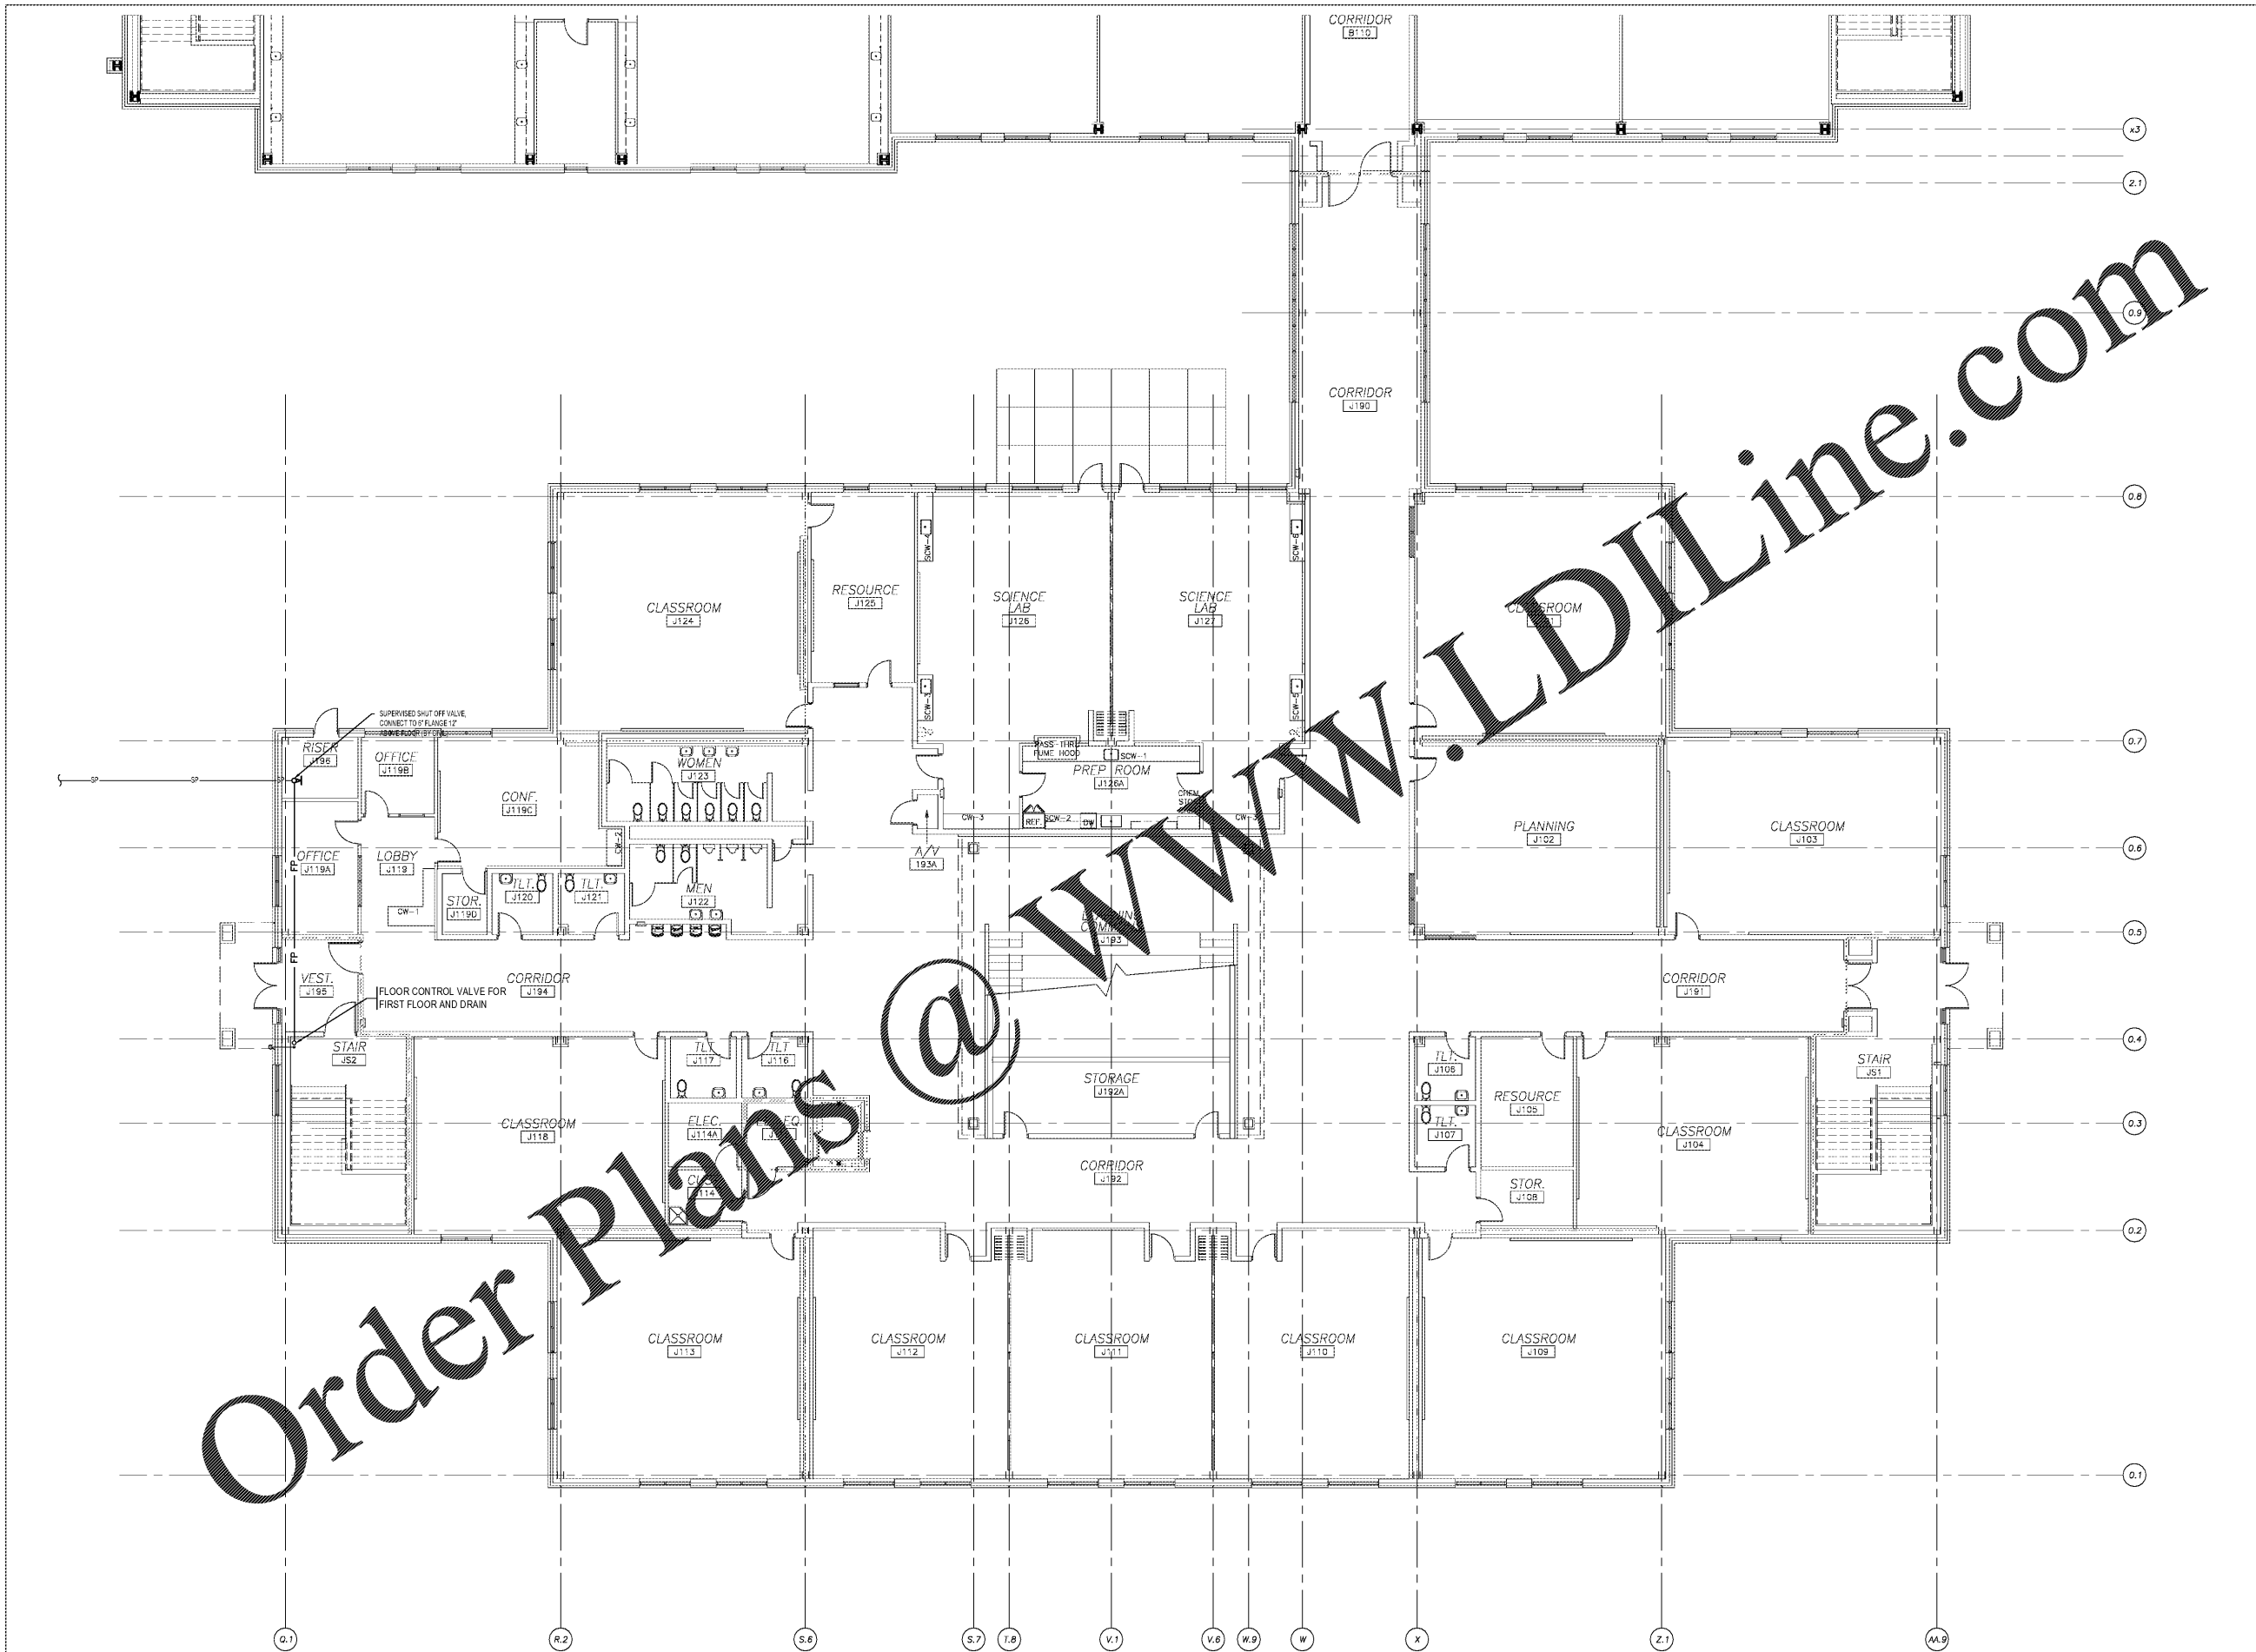


Order Plans @ WWW.LDILine.com

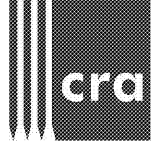

222 cloister court
chapel hill, nc 27514
919.401.8586
www.cra-nc.com



Cedar Ridge High School
Classroom Addition
Orange County Schools
1125 New Grady Brown School Road
Hillsborough, North Carolina

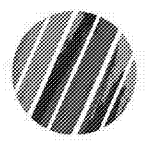

no.	revisions

The user of these plans and specifications shall be responsible for the accuracy of the drawings after the date of their issuance and shall not be held responsible for any errors or omissions in the drawings or specifications or for any consequences of any such errors or omissions. It is the user's responsibility to verify the accuracy of the drawings and specifications before use. No liability shall be assumed by the architect for any errors or omissions in the drawings or specifications or for any consequences of any such errors or omissions.

drawn	checked
JPO	JPO

First Floor
Fire Protection Plan

sheet
FP1.1

project no. 1716

date 4/25/19

First Floor Fire Protection Plan
Scale: 1/8" = 1'-0"