


THIS DRAWING IS NOT TO BE SCALED FOR DIMENSION PURPOSES. THE SCALE WHERE INDICATED IS FOR GENERAL REFERENCE ONLY.

GRAPHIC SCALE 1/8" = 1'-0"

GRAPHIC SCALE 1/8" = 1'-0"

GRAPHIC SCALE 1/8" = 1'-0"

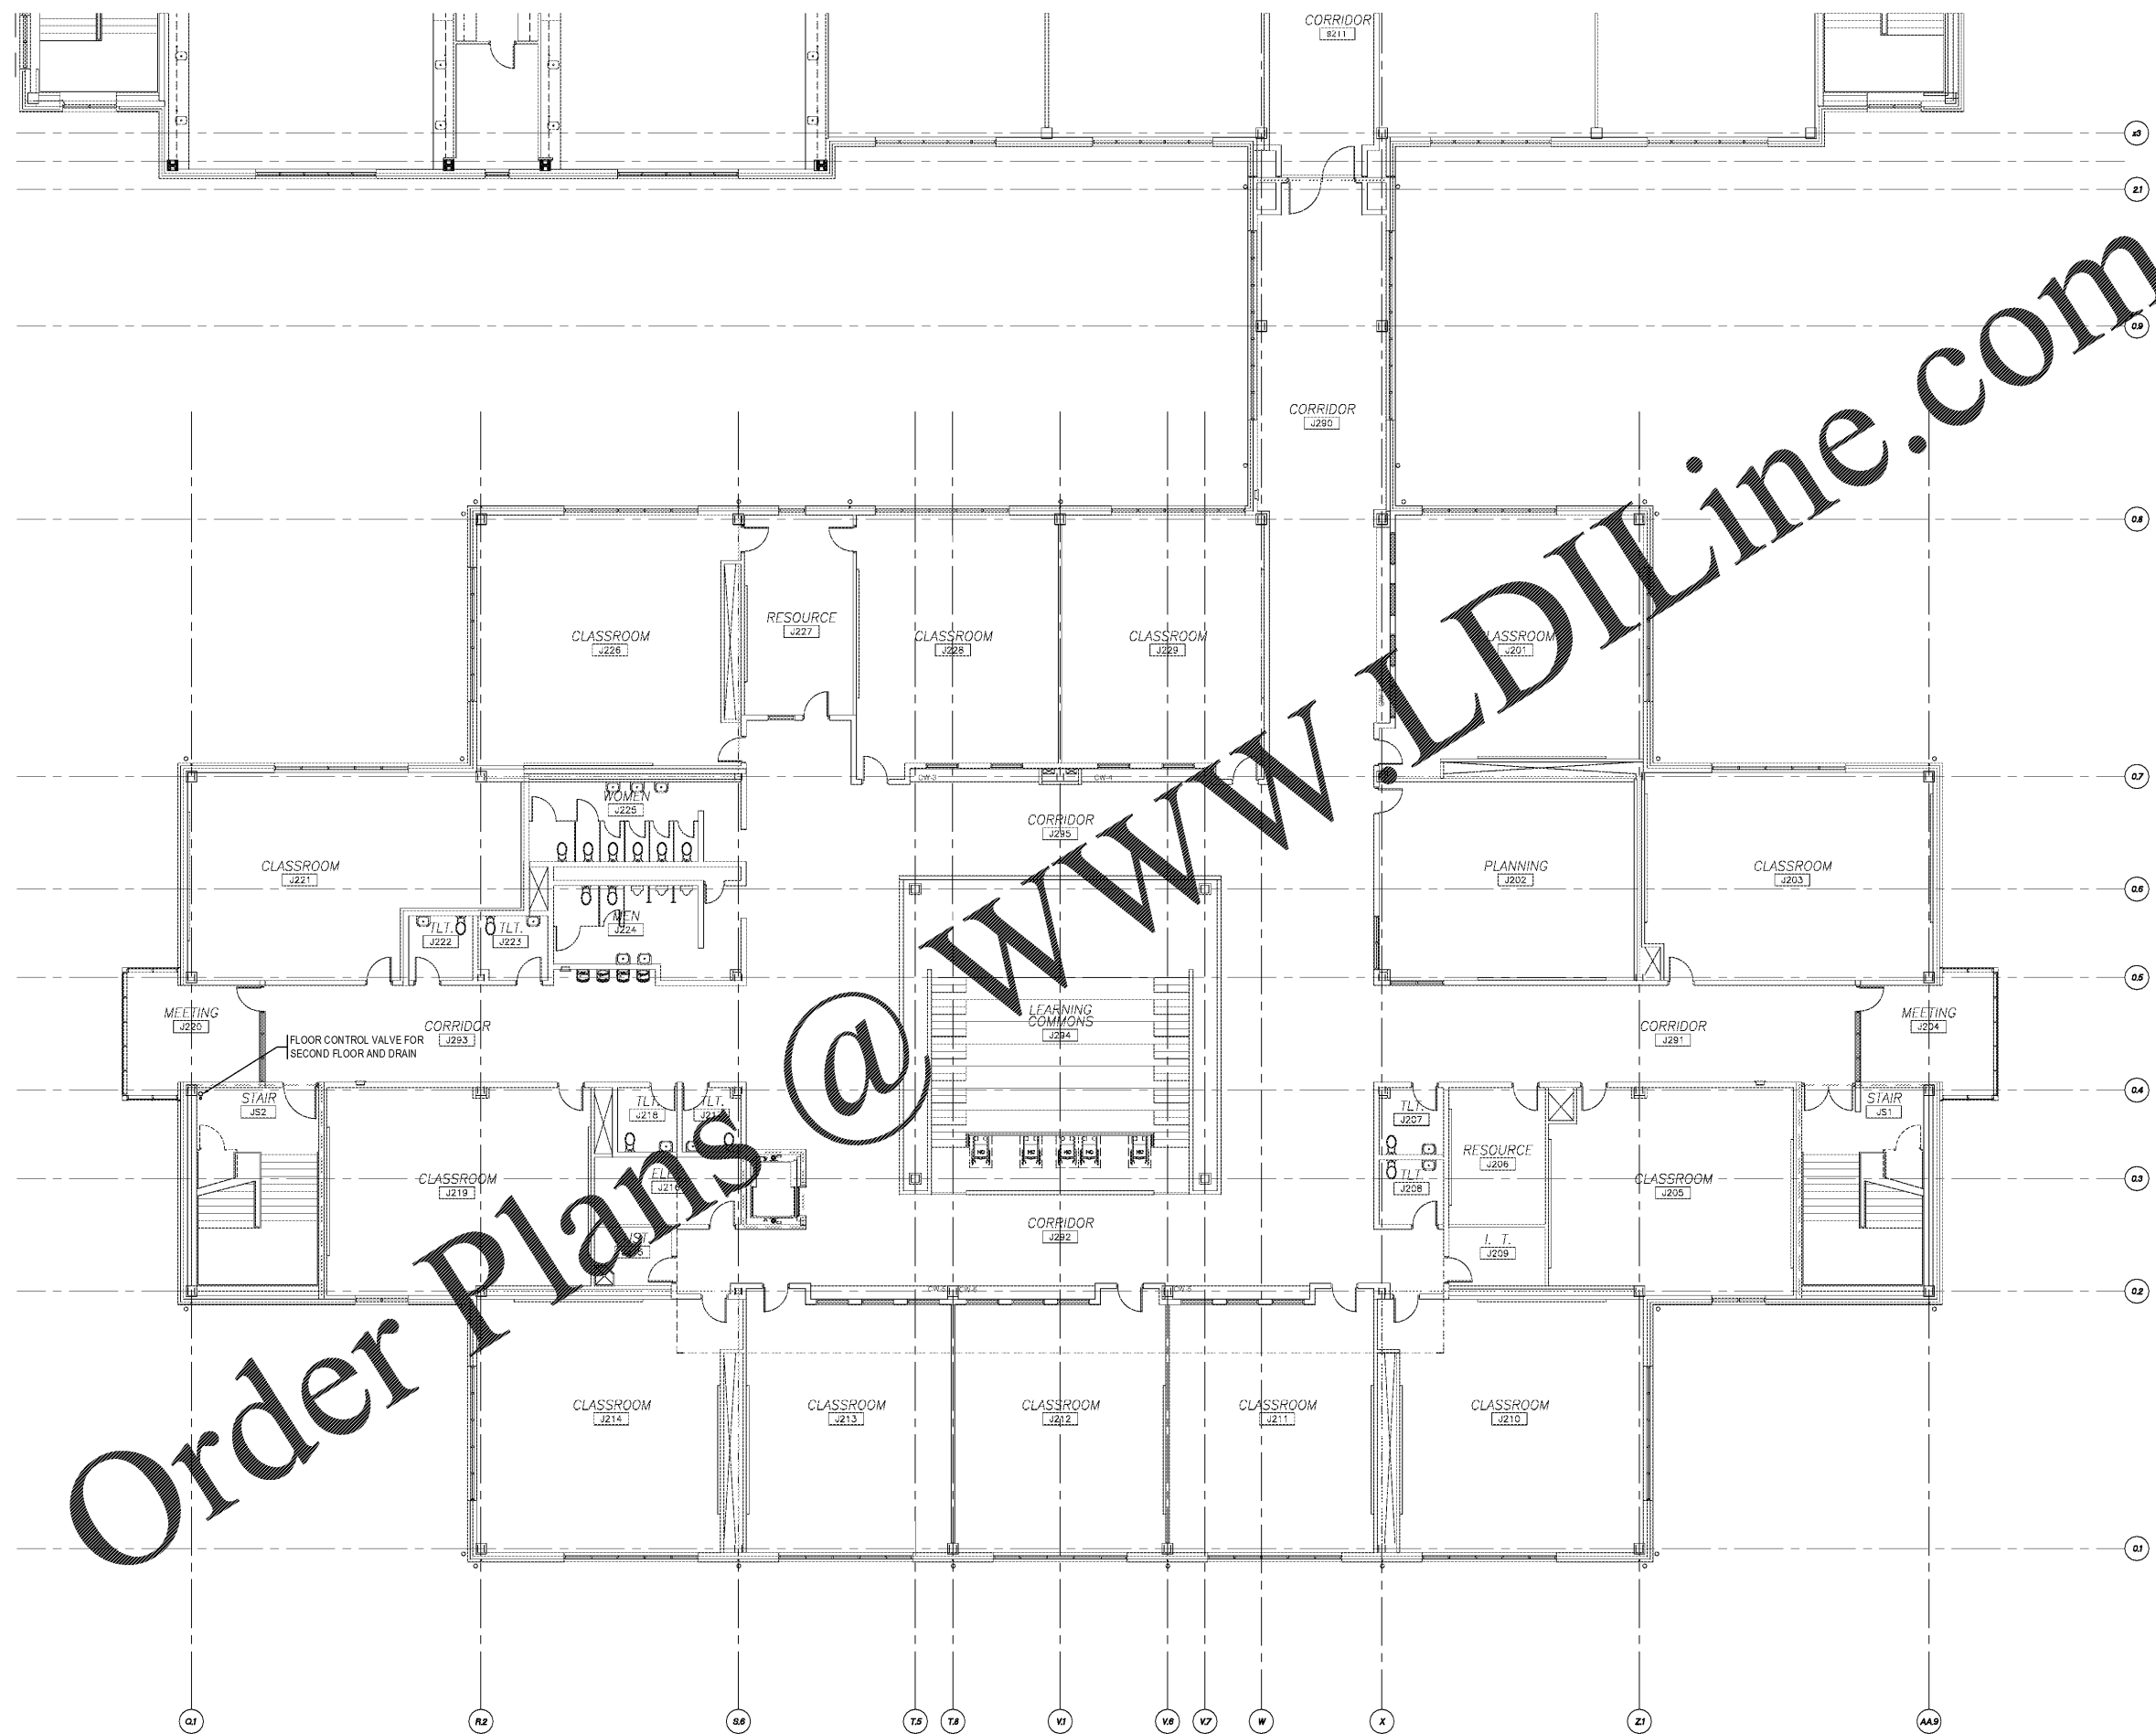

Order Plans @ WWW.LDILine.com

WWW.LDILine.com




222 cloister court
chapel hill, nc 27514
919.401.6586
www.cra-ae.com



Reece, Noland & McElrath, Inc.
24 Main Street
Canton, North Carolina 28716
FLOOR PLAN
WWW.RNMENGINEERS.COM



Cedar Ridge High School
Classroom Addition
Orange County Schools
1125 New Grady Brown School Road
Hillsborough, North Carolina

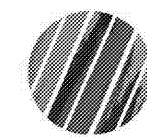

no. revisions

The user of these plans and specifications shall be responsible for the original after the date of issue. Any changes and substitutions must be made in accordance with the provisions of the contract documents. It is to be understood upon request to the architect that the user shall be responsible for the accuracy of the information and that the user shall be responsible for the accuracy of the information.

drawn checked

JPO JPO
Second Floor
Fire Protection Plan

sheet

FP1.2

project no. 1716

date 4/25/19

Construction Document Bid Set

Second Floor Fire Protection Plan
Scale: 1/8" = 1'-0"