



THIS DRAWING IS NOT TO BE SCALED FOR DIMENSION PURPOSES. THE SCALE WHERE PROVIDED IS FOR GENERAL REFERENCE ONLY.

GRAPHIC SCALE 1/4"=1'-0"
GRAPHIC SCALE 1/8"=1'-0"
GRAPHIC SCALE 1/16"=1'-0"

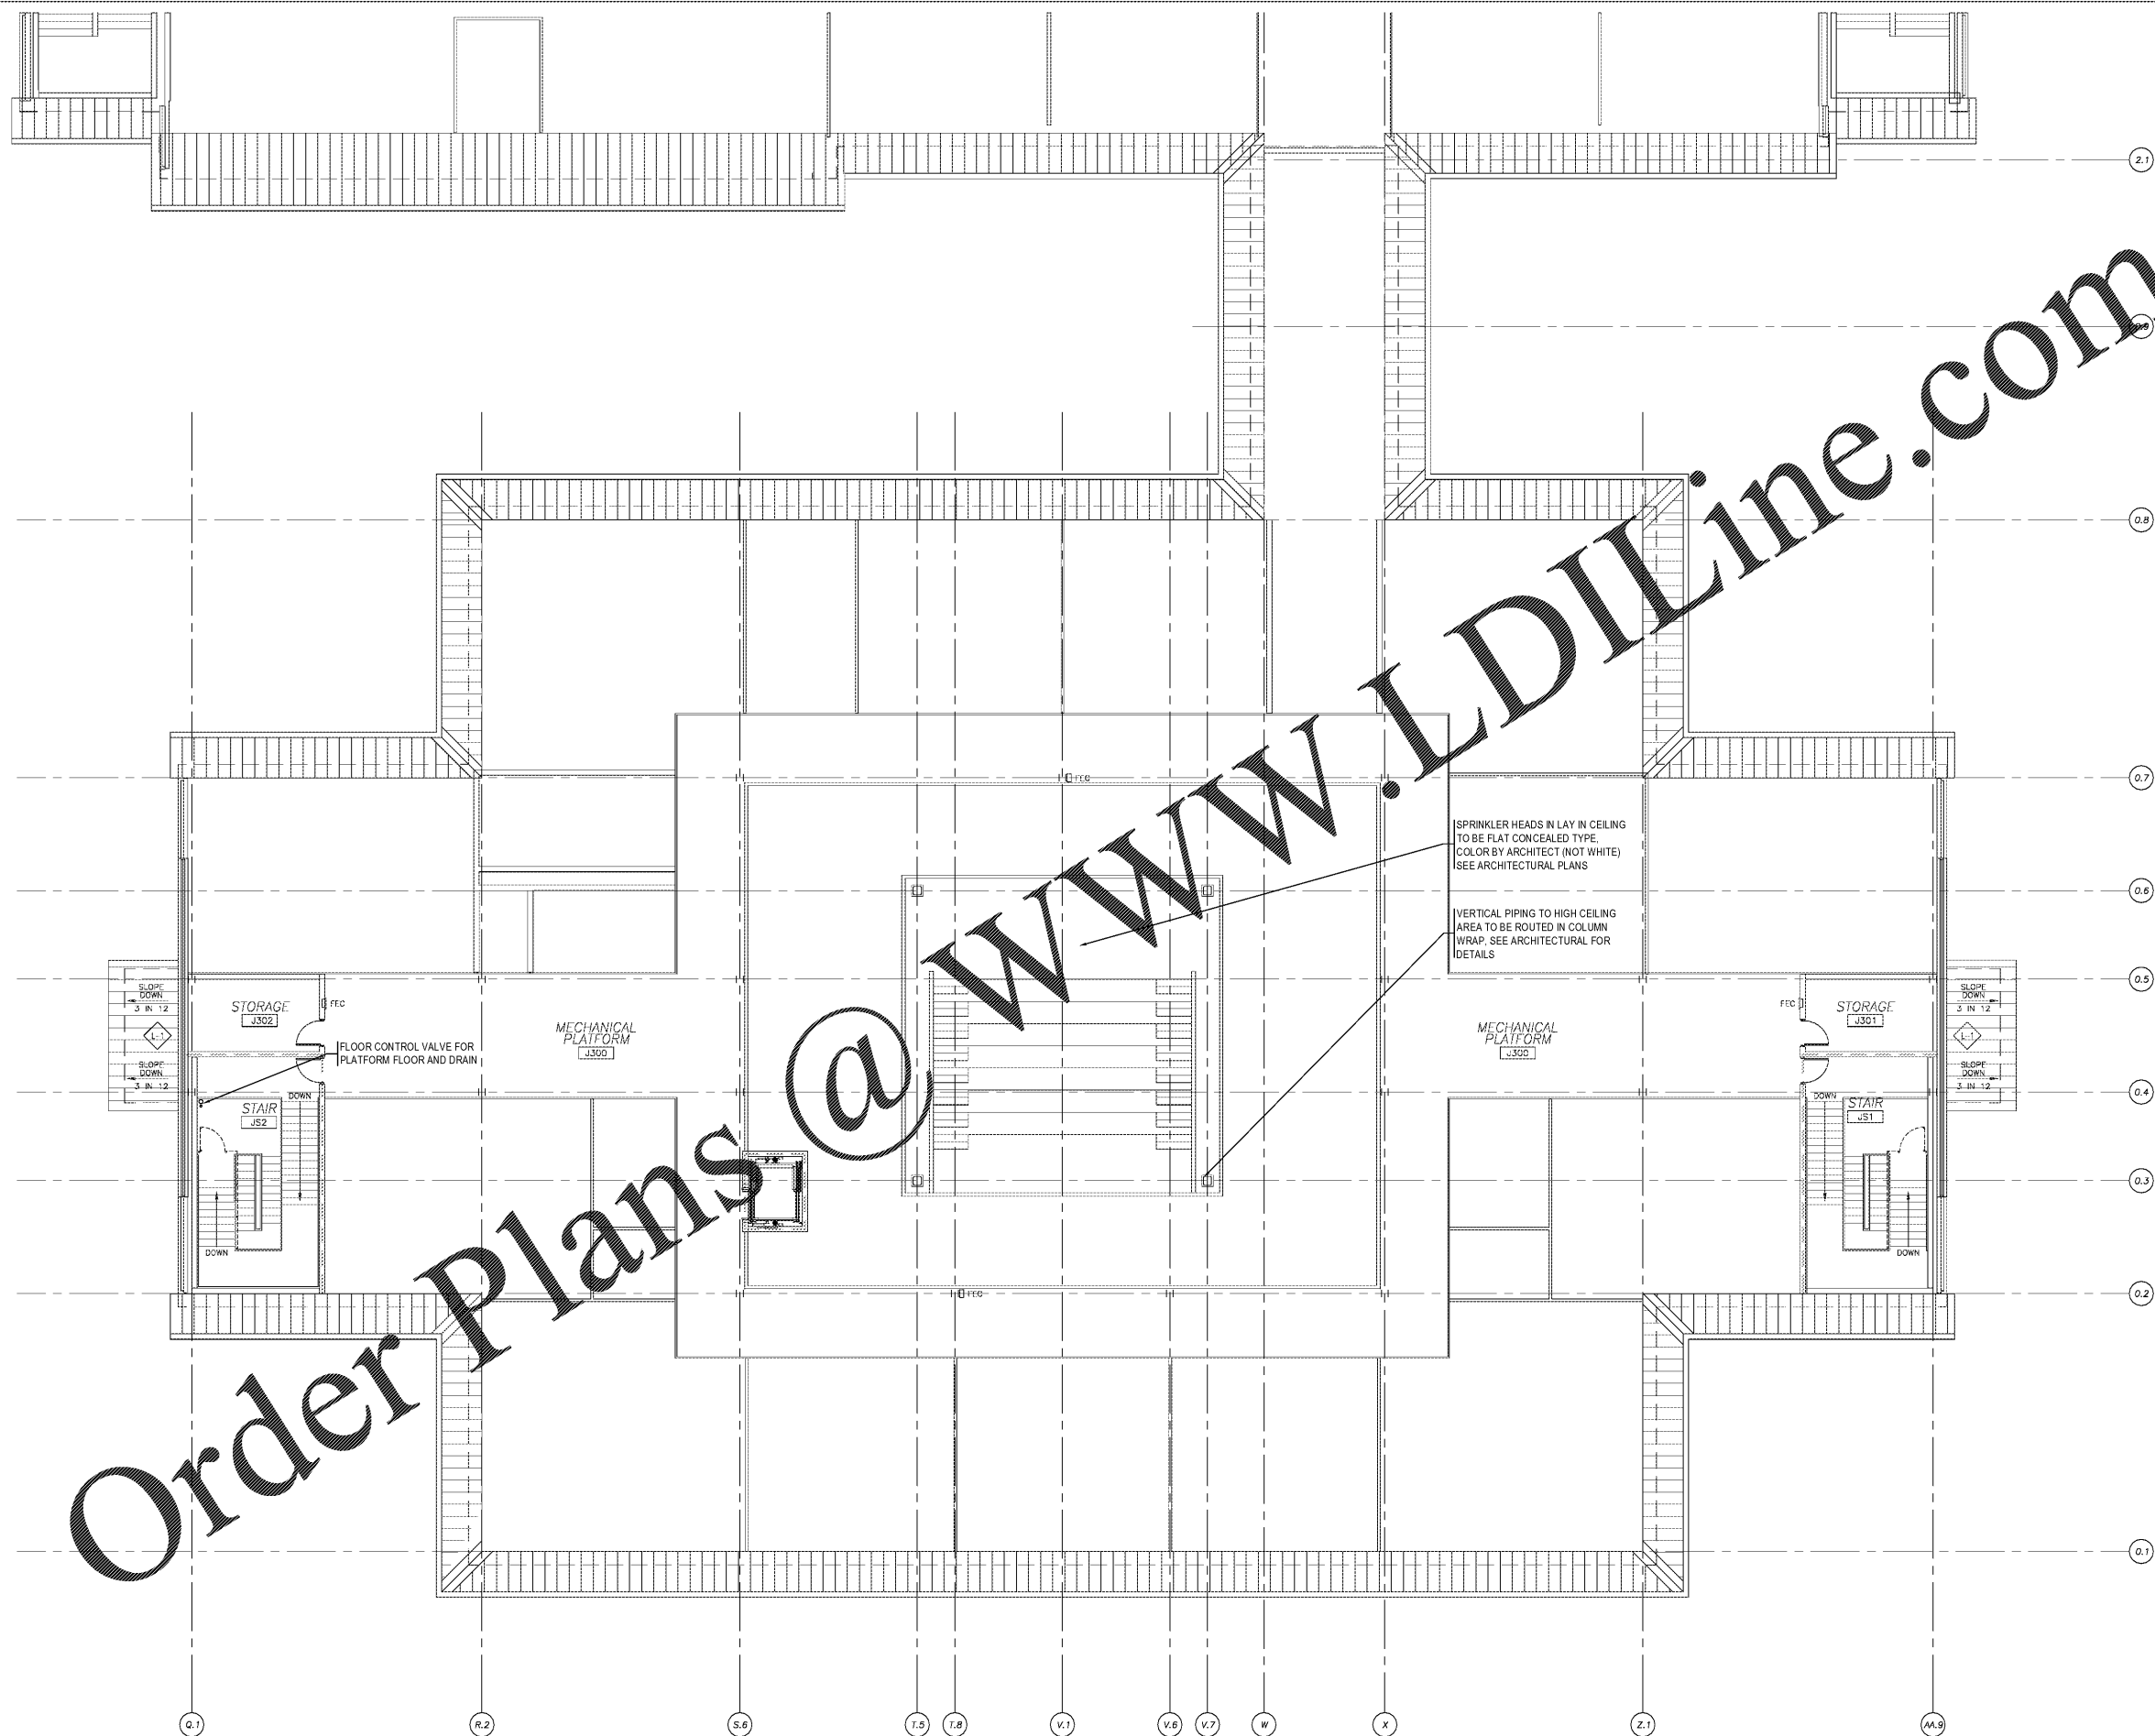

Order Plans @ WWW.LDILine.com

Platform Level Fire Protection Plan
Scale: 1/8" = 1'-0"

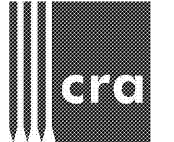


222 cloister court
chapel hill, nc 27514
919.401.6586
www.cra-nc.com



Reece, Noland & McElrath, Inc.
14 Main Street
Canton, North Carolina 28716
PHONE 919.401.1000 FAX 919.401.1001
WWW.RNME.COM



Cedar Ridge High School
Classroom Addition
Orange County Schools
1125 New Grady Brown School Road
Hillsborough, North Carolina

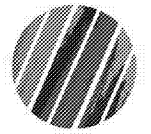

no.	revisions
-----	-----------

The user of these plans and specifications shall be responsible for the accuracy of the original after its adoption. The user shall maintain and distribute a current copy of these plans and specifications for reference. The user shall be responsible for any changes or amendments to these plans and specifications. The user shall be responsible for any errors or omissions in these plans and specifications. The user shall be responsible for any changes or amendments to these plans and specifications.

drawn	checked
IPO	IPO

Platform Level
Fire Protection Plan

sheet
FP1.3

project no. 1716

date 4/25/19