


GRAPHIC SCALE 1/4"=1'-0"


GRAPHIC SCALE 1/8"=1'-0"

GRAPHIC SCALE 1/8"=1'-0"

THIS DRAWING IS NOT TO BE SCALED FOR DIMENSIONS PURPOSES. THE SCALE SHOWN HEREIN IS FOR GENERAL REFERENCE ONLY.

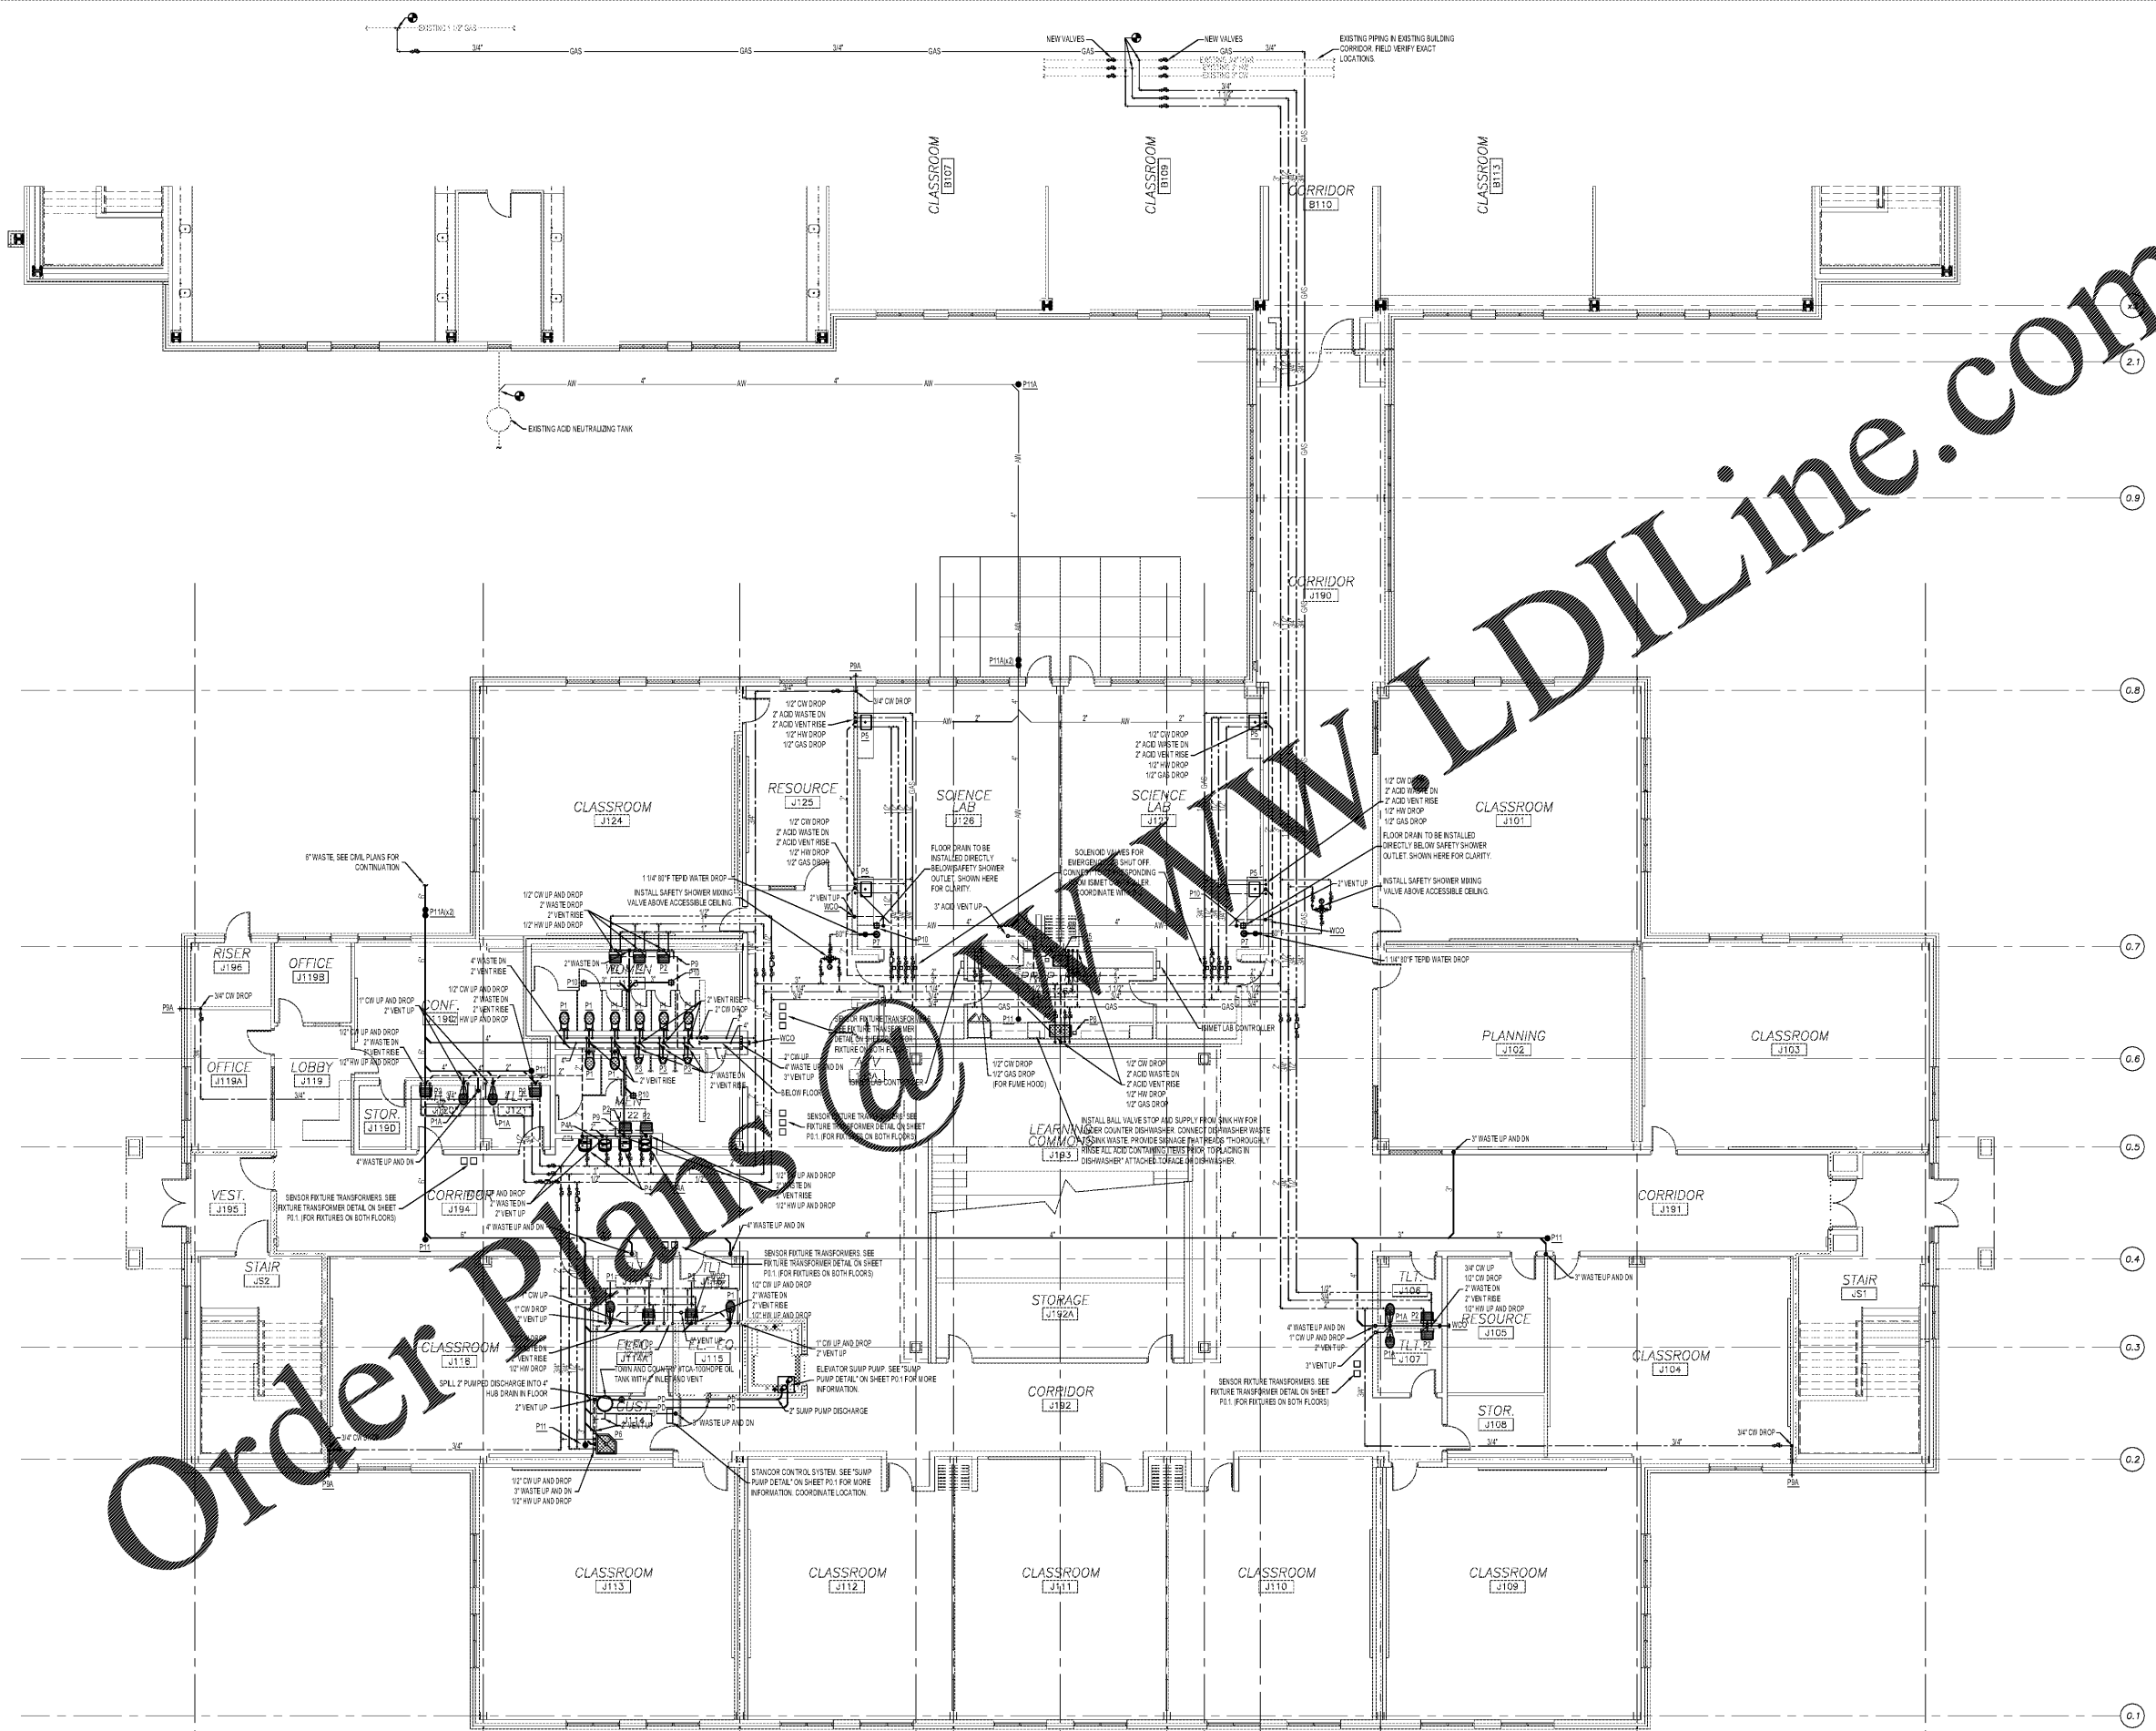

First Floor Plumbing Plan  
 Scale: 1/8" = 1'-0"

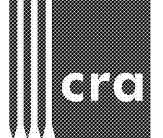


222 cloister court  
 chapel hill, nc 27514  
 919.401.8586  
 www.cra-nc.com



Reece, Noland & McElrath, Inc.  
 14 Main Street  
 Canton, North Carolina 28716  
 919.401.8586  
 www.rnmengineers.com



Cedar Ridge High School  
 Classroom Addition  
 Orange County Schools  
 1125 New Grady Brown School Road  
 Hillsborough, North Carolina

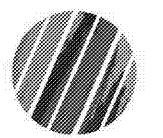

no. revisions

The user of these plans and specifications shall be responsible for the accuracy of the original data provided. The user shall maintain and shall be responsible for any errors or omissions in the original data provided. The user shall be responsible for any errors or omissions in the original data provided. The user shall be responsible for any errors or omissions in the original data provided.

drawn	checked
JRW	JPO

First Floor  
 Plumbing Plan

sheet  
**P1.1**

project no. 1716

date 4/25/19