


GRAPHIC SCALE 1/4"=1'-0"


GRAPHIC SCALE 1/8"=1'-0"

GRAPHIC SCALE 1/16"=1'-0"

THIS DRAWING IS NOT TO BE SCALED FOR CONSTRUCTION PURPOSES. THE SCALE INDICATED IS FOR GENERAL REFERENCE ONLY.

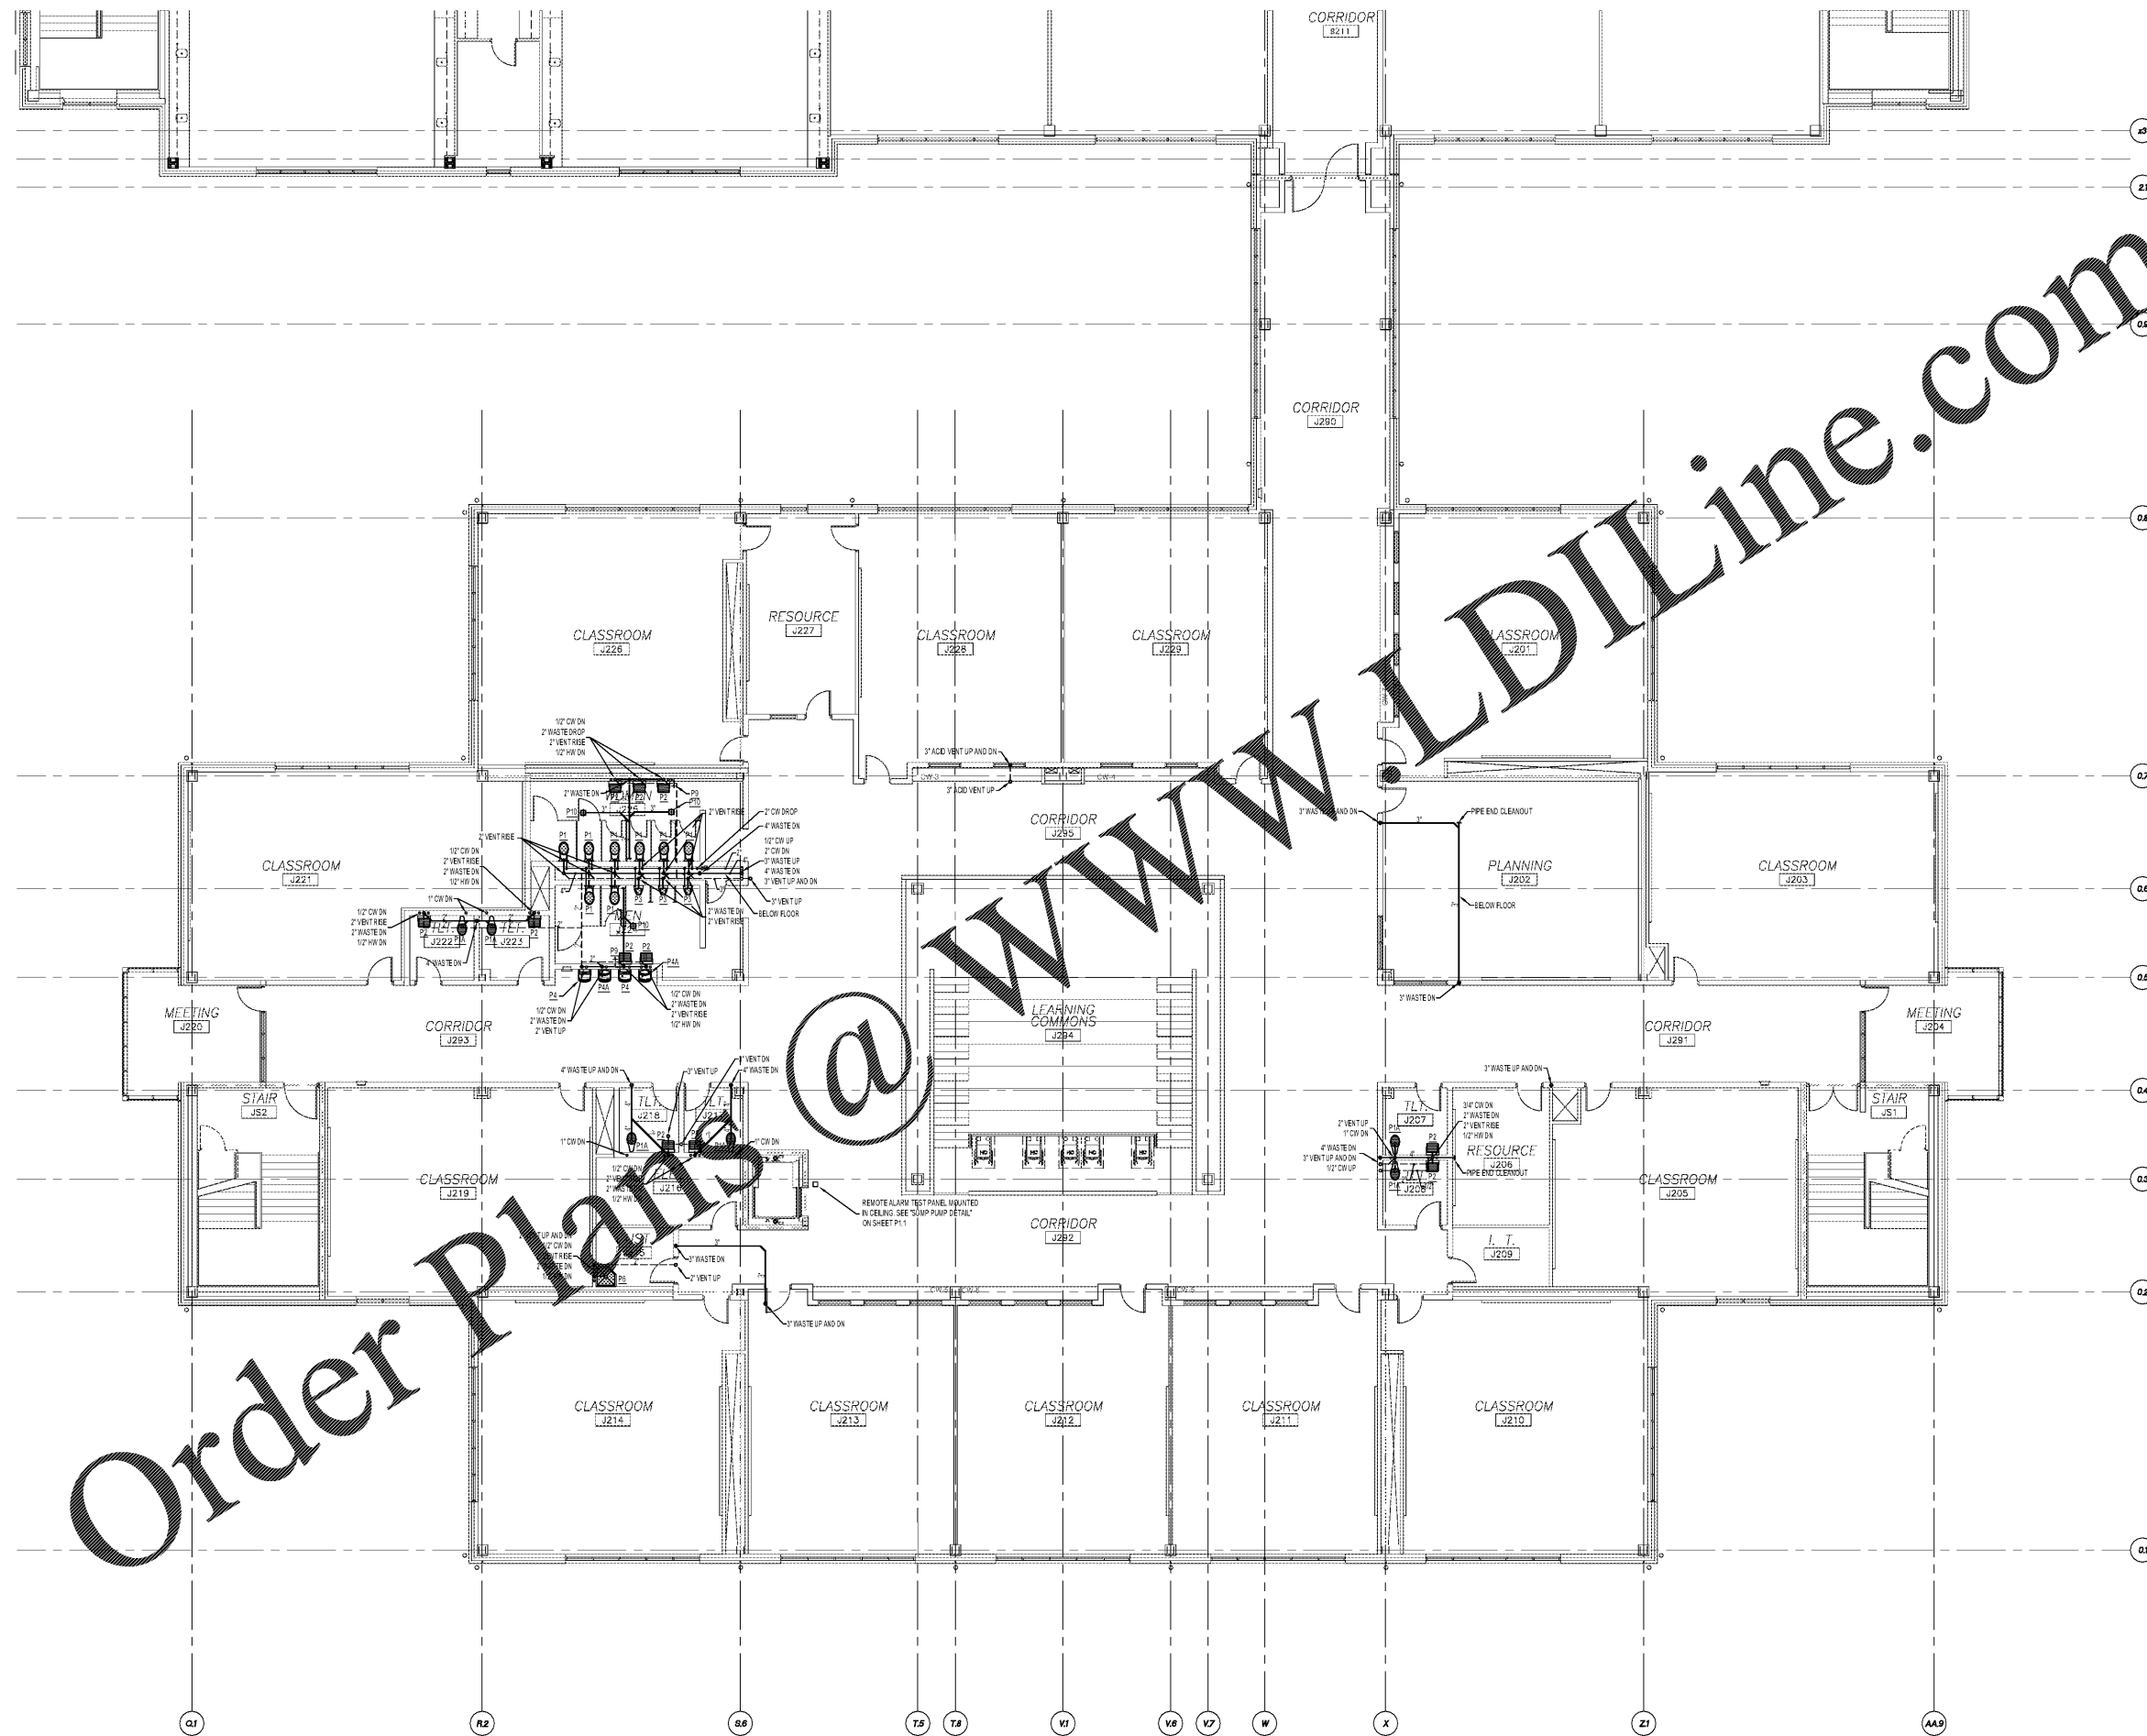

Second Floor Plumbing Plan
 Scale: 1/8" = 1'-0"

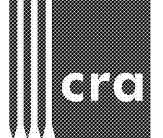


222 cloister court
 chapel hill, nc 27514
 919.401.8586
 www.cra-nc.com



Reece, Noland & McElrath, Inc.
 14 Main Street
 Canton, North Carolina 28716
 PHONE 919.401.8586 FAX 919.401.8587
 WWW.RNME.COM



Cedar Ridge High School
 Classroom Addition
 Orange County Schools
 1125 New Grady Brown School Road
 Hillsborough, North Carolina

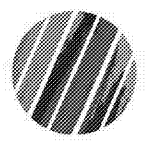

no.	revisions

The user of these plans and specifications shall be responsible for the accuracy of the original after its issue. Any error, omission, or contradiction shall be the responsibility of the user. No liability shall be assumed by the drafter or specifier for any error or omission in these plans and specifications. The user shall be responsible for the accuracy of the original after its issue. Any error, omission, or contradiction shall be the responsibility of the user. No liability shall be assumed by the drafter or specifier for any error or omission in these plans and specifications.

drawn	checked
JRW	JPO

Second Floor
 Plumbing Plan

sheet
P1.2

project no. 1716

date 4/25/19