



GRAPHIC SCALE 1/8"=1'-0"  
 GRAPHIC SCALE 1/16"=1'-0"  
 GRAPHIC SCALE 1/32"=1'-0"

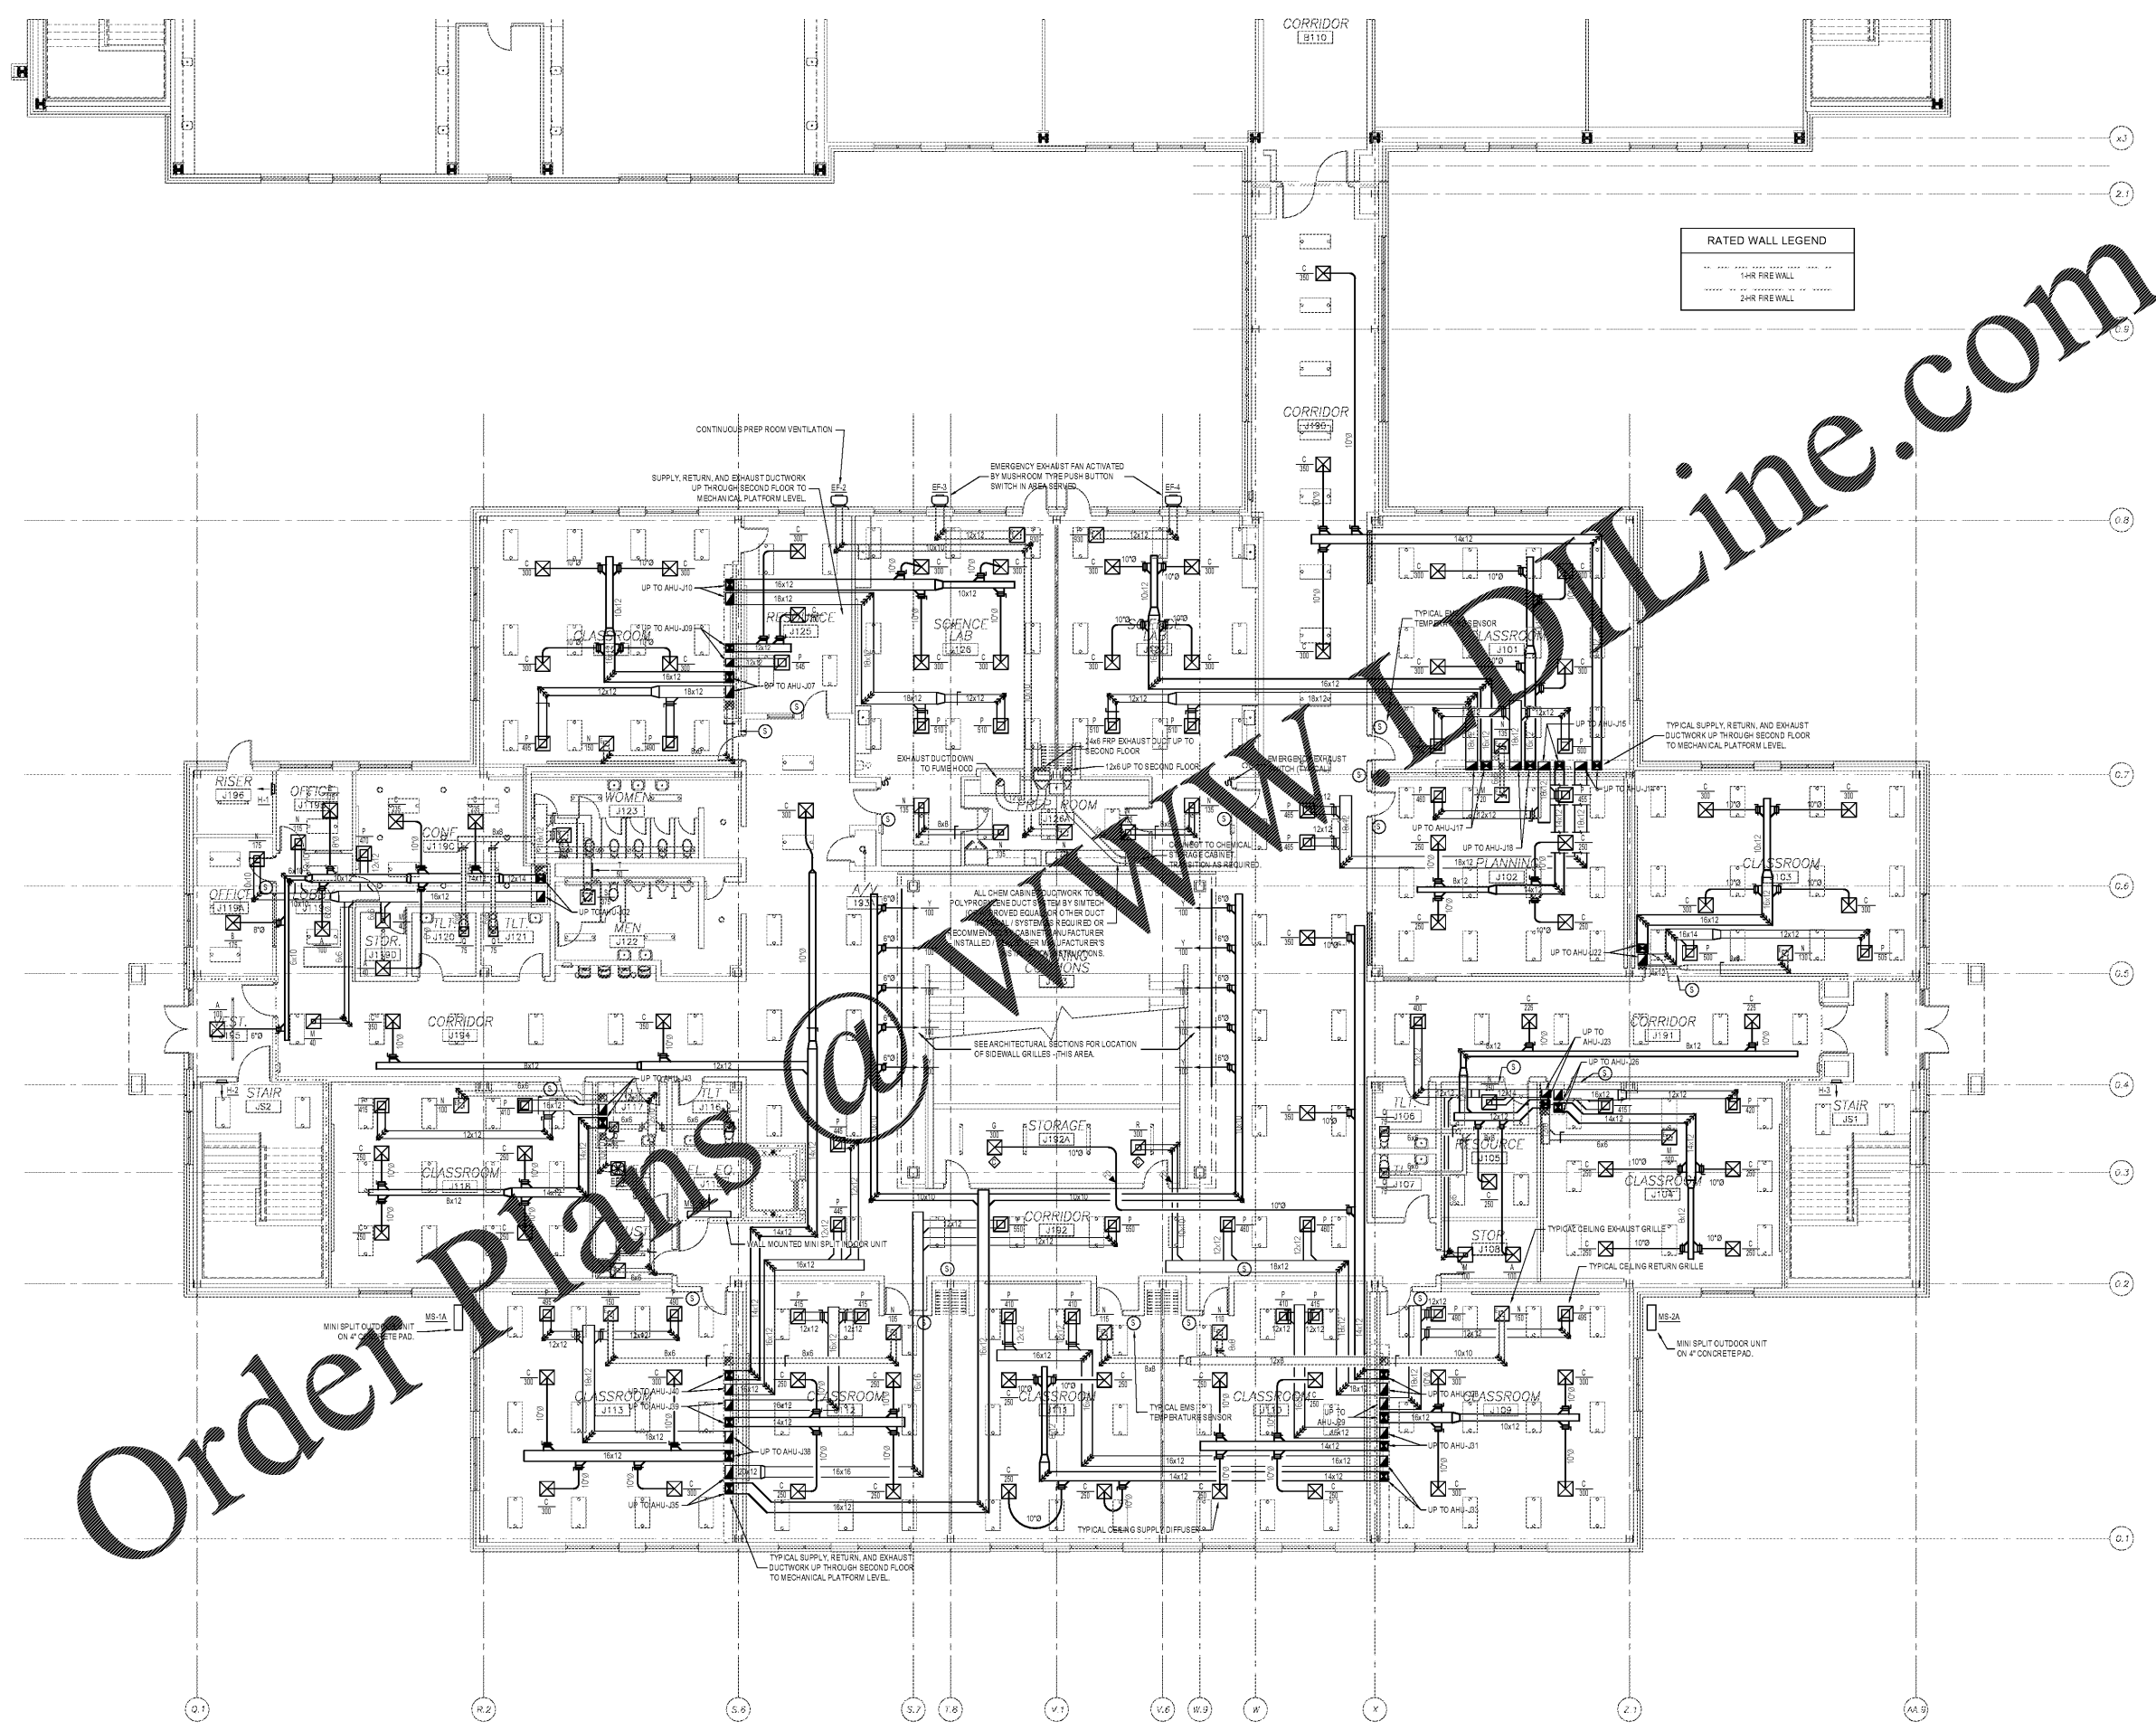

Order Plans @


First Floor Mechanical Ductwork Plan  
 Scale: 1/8" = 1'-0"

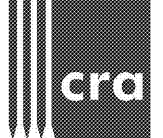

222 cloister court  
 chapel hill, nc 27514  
 919.401.8586  
 www.cra-nc.com



Cedar Ridge High School  
 Classroom Addition  
 Orange County Schools  
 1125 New Grady Brown School Road  
 Hillsborough, North Carolina

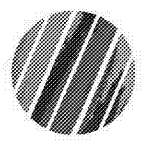

no. revisions

The use of these notes and specifications shall be subject to the extent that the notes and specifications are not in conflict with the contract documents. The contractor shall be responsible for obtaining all necessary permits and approvals for the work. The contractor shall be responsible for obtaining all necessary permits and approvals for the work. The contractor shall be responsible for obtaining all necessary permits and approvals for the work.

drawn	checked
DM	MRM

First Floor  
 Mechanical  
 Ductwork Plan

sheet  
**M1.1**

project no. 1716

date 4/25/19