


GRAPHIC SCALE 1/8"=1'-0"

GRAPHIC SCALE 1/8"=1'-0"


GRAPHIC SCALE 1/8"=1'-0"

THIS DRAWING IS NOT TO BE SCALED FOR CONSTRUCTION PURPOSES. THE SCALE WHEN INDICATED IS FOR GENERAL REFERENCE ONLY.

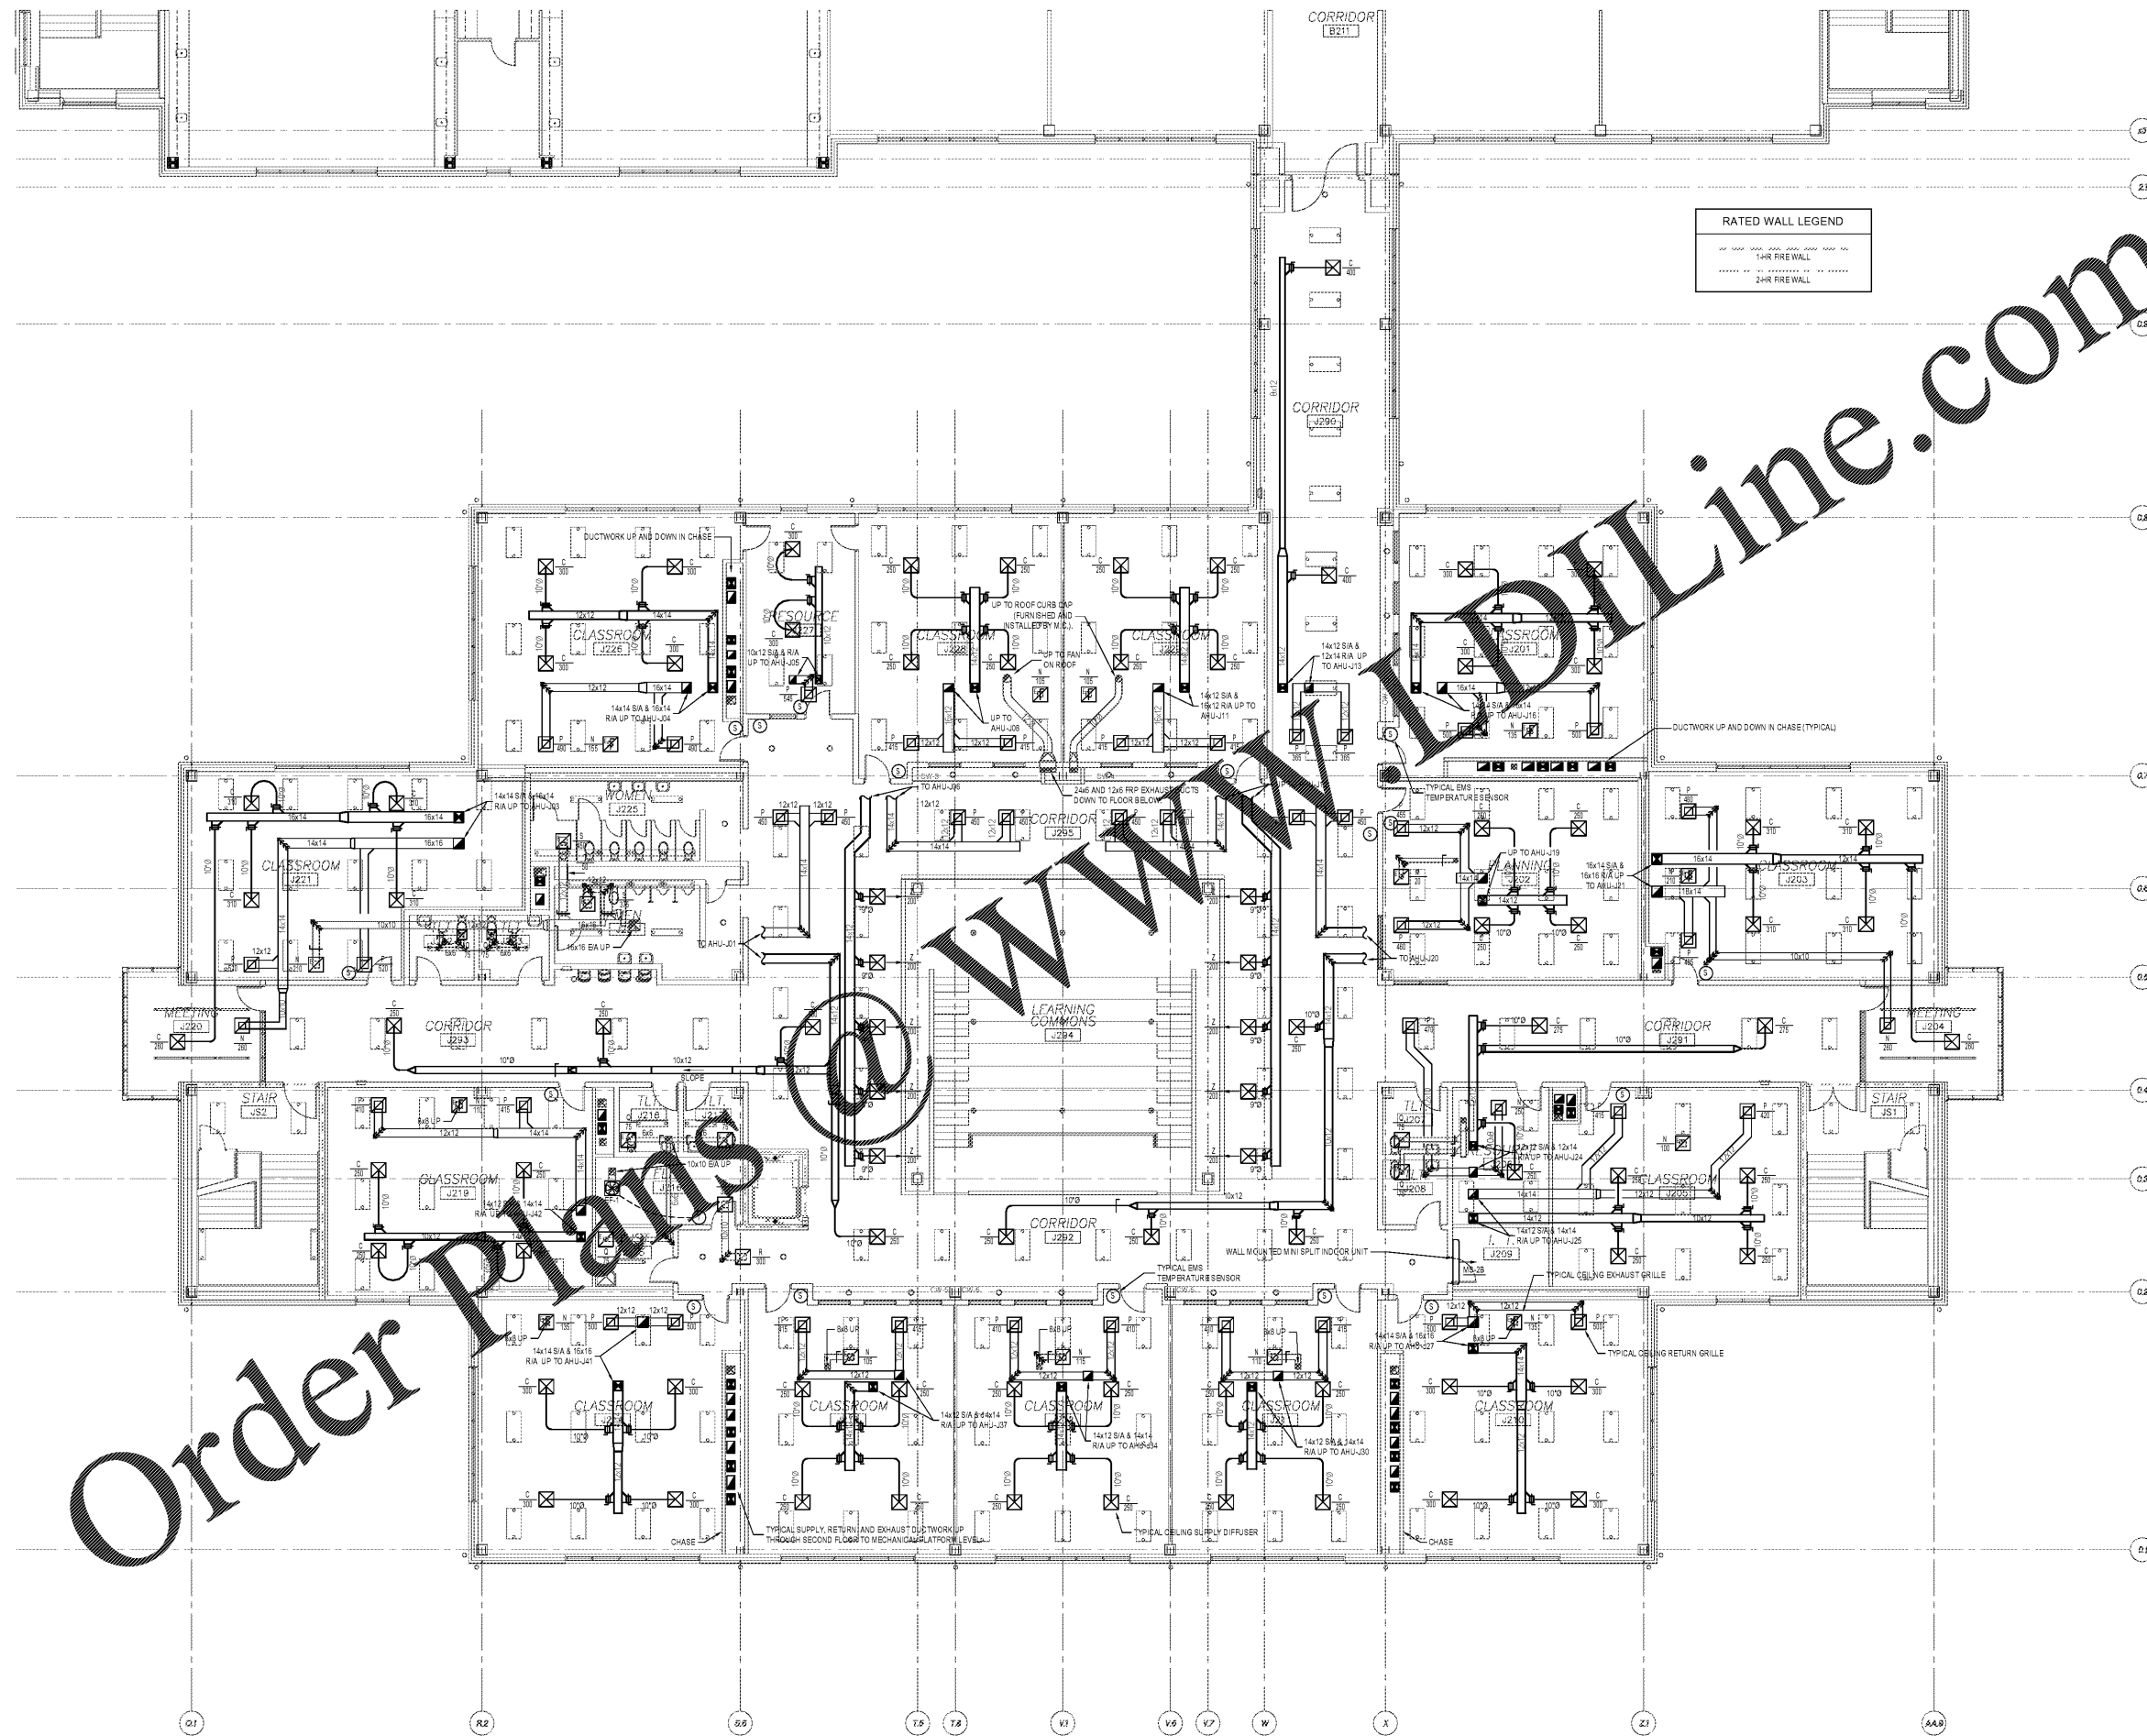

Order plans


Second Floor Mechanical Ductwork Plan
Scale: 1/8" = 1'-0"

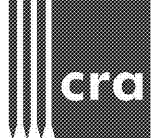

222 cloister court
chapel hill, nc 27514
919.401.8586
www.cra-ae.com



Cedar Ridge High School
Classroom Addition
Orange County Schools
1125 New Grady Brown School Road
Hillsborough, North Carolina

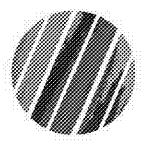

no. revisions

The use of these notes and specifications shall be reviewed by the architect prior to construction. The contractor shall be responsible for obtaining all necessary permits and for obtaining all necessary approvals from the appropriate authorities. The contractor shall be responsible for obtaining all necessary approvals from the appropriate authorities. The contractor shall be responsible for obtaining all necessary approvals from the appropriate authorities.

drawn checked
DIM MRM
Second Floor
Mechanical
Ductwork Plan

sheet
M1.2

project no. 1716

date 4/25/19