



GRAPHIC SCALE 1/8"=1'-0"  
 GRAPHIC SCALE 1/8"=1'-0"  
 GRAPHIC SCALE 1/8"=1'-0"

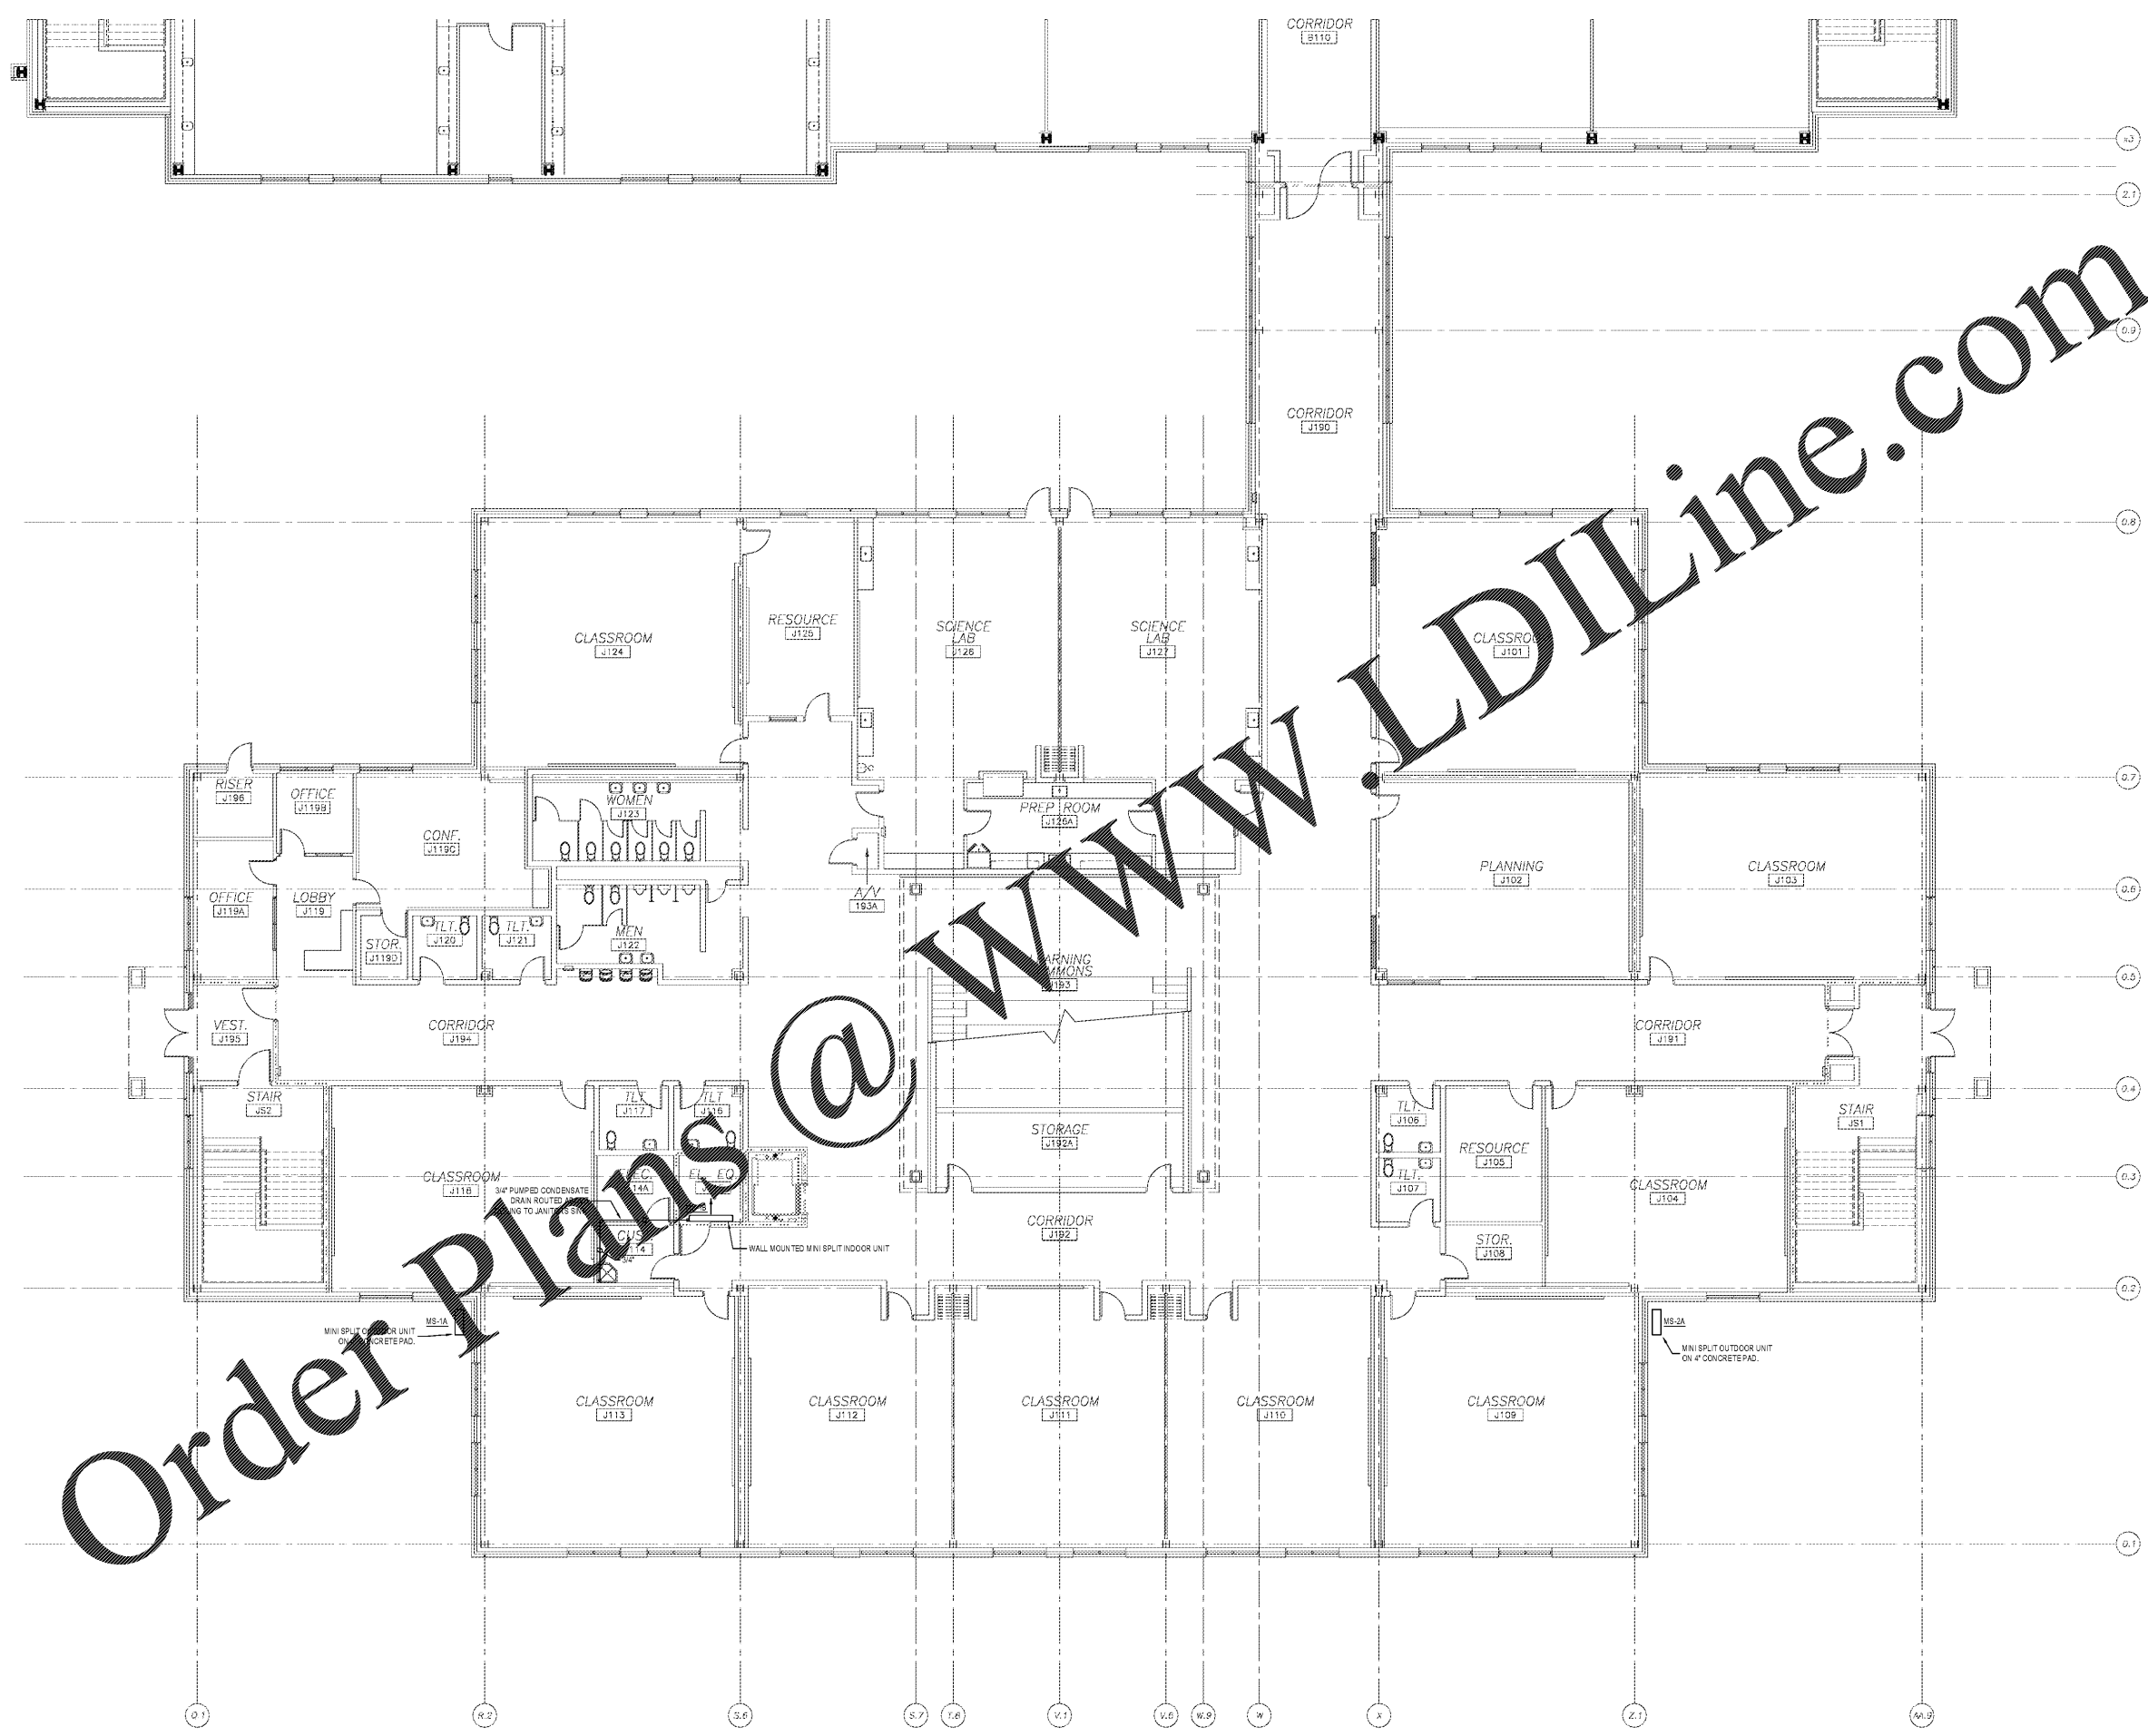

Order Plans @

WWW.LDILine.com


First Floor Mechanical Piping Plan  
 Scale: 1/8" = 1'-0"

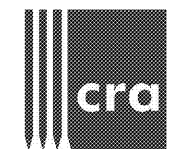

222 cloister court  
 chapel hill, nc 27514  
 919.401.8586  
 www.cra-nc.com



Cedar Ridge High School  
 Classroom Addition  
 Orange County Schools  
 1125 New Grady Brown School Road  
 Hillsborough, North Carolina

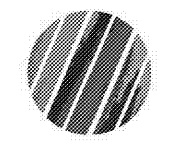

no.	revisions

The use of these plans and specifications shall be restricted to the project and for which they were prepared and no liability shall be assumed for any other use. The user, manufacturer, or distributor of any material used in the project shall be responsible for its proper use. Make certain that these plans and specifications are complete and correct prior to the start of the construction of these structures.

drawn	checked
DM	MRM

First Floor  
 Mechanical  
 Piping Plan

sheet  
**M2.1**

project no. 1716

date 4/25/19