


GRAPHIC SCALE 1/8"=1'-0"


GRAPHIC SCALE 1/8"=1'-0"

GRAPHIC SCALE 1/8"=1'-0"

THIS DRAWING IS NOT TO BE SCALED FOR CONSTRUCTION PURPOSES. THE SCALE WHEN INDICATED IS FOR GENERAL REFERENCE ONLY.

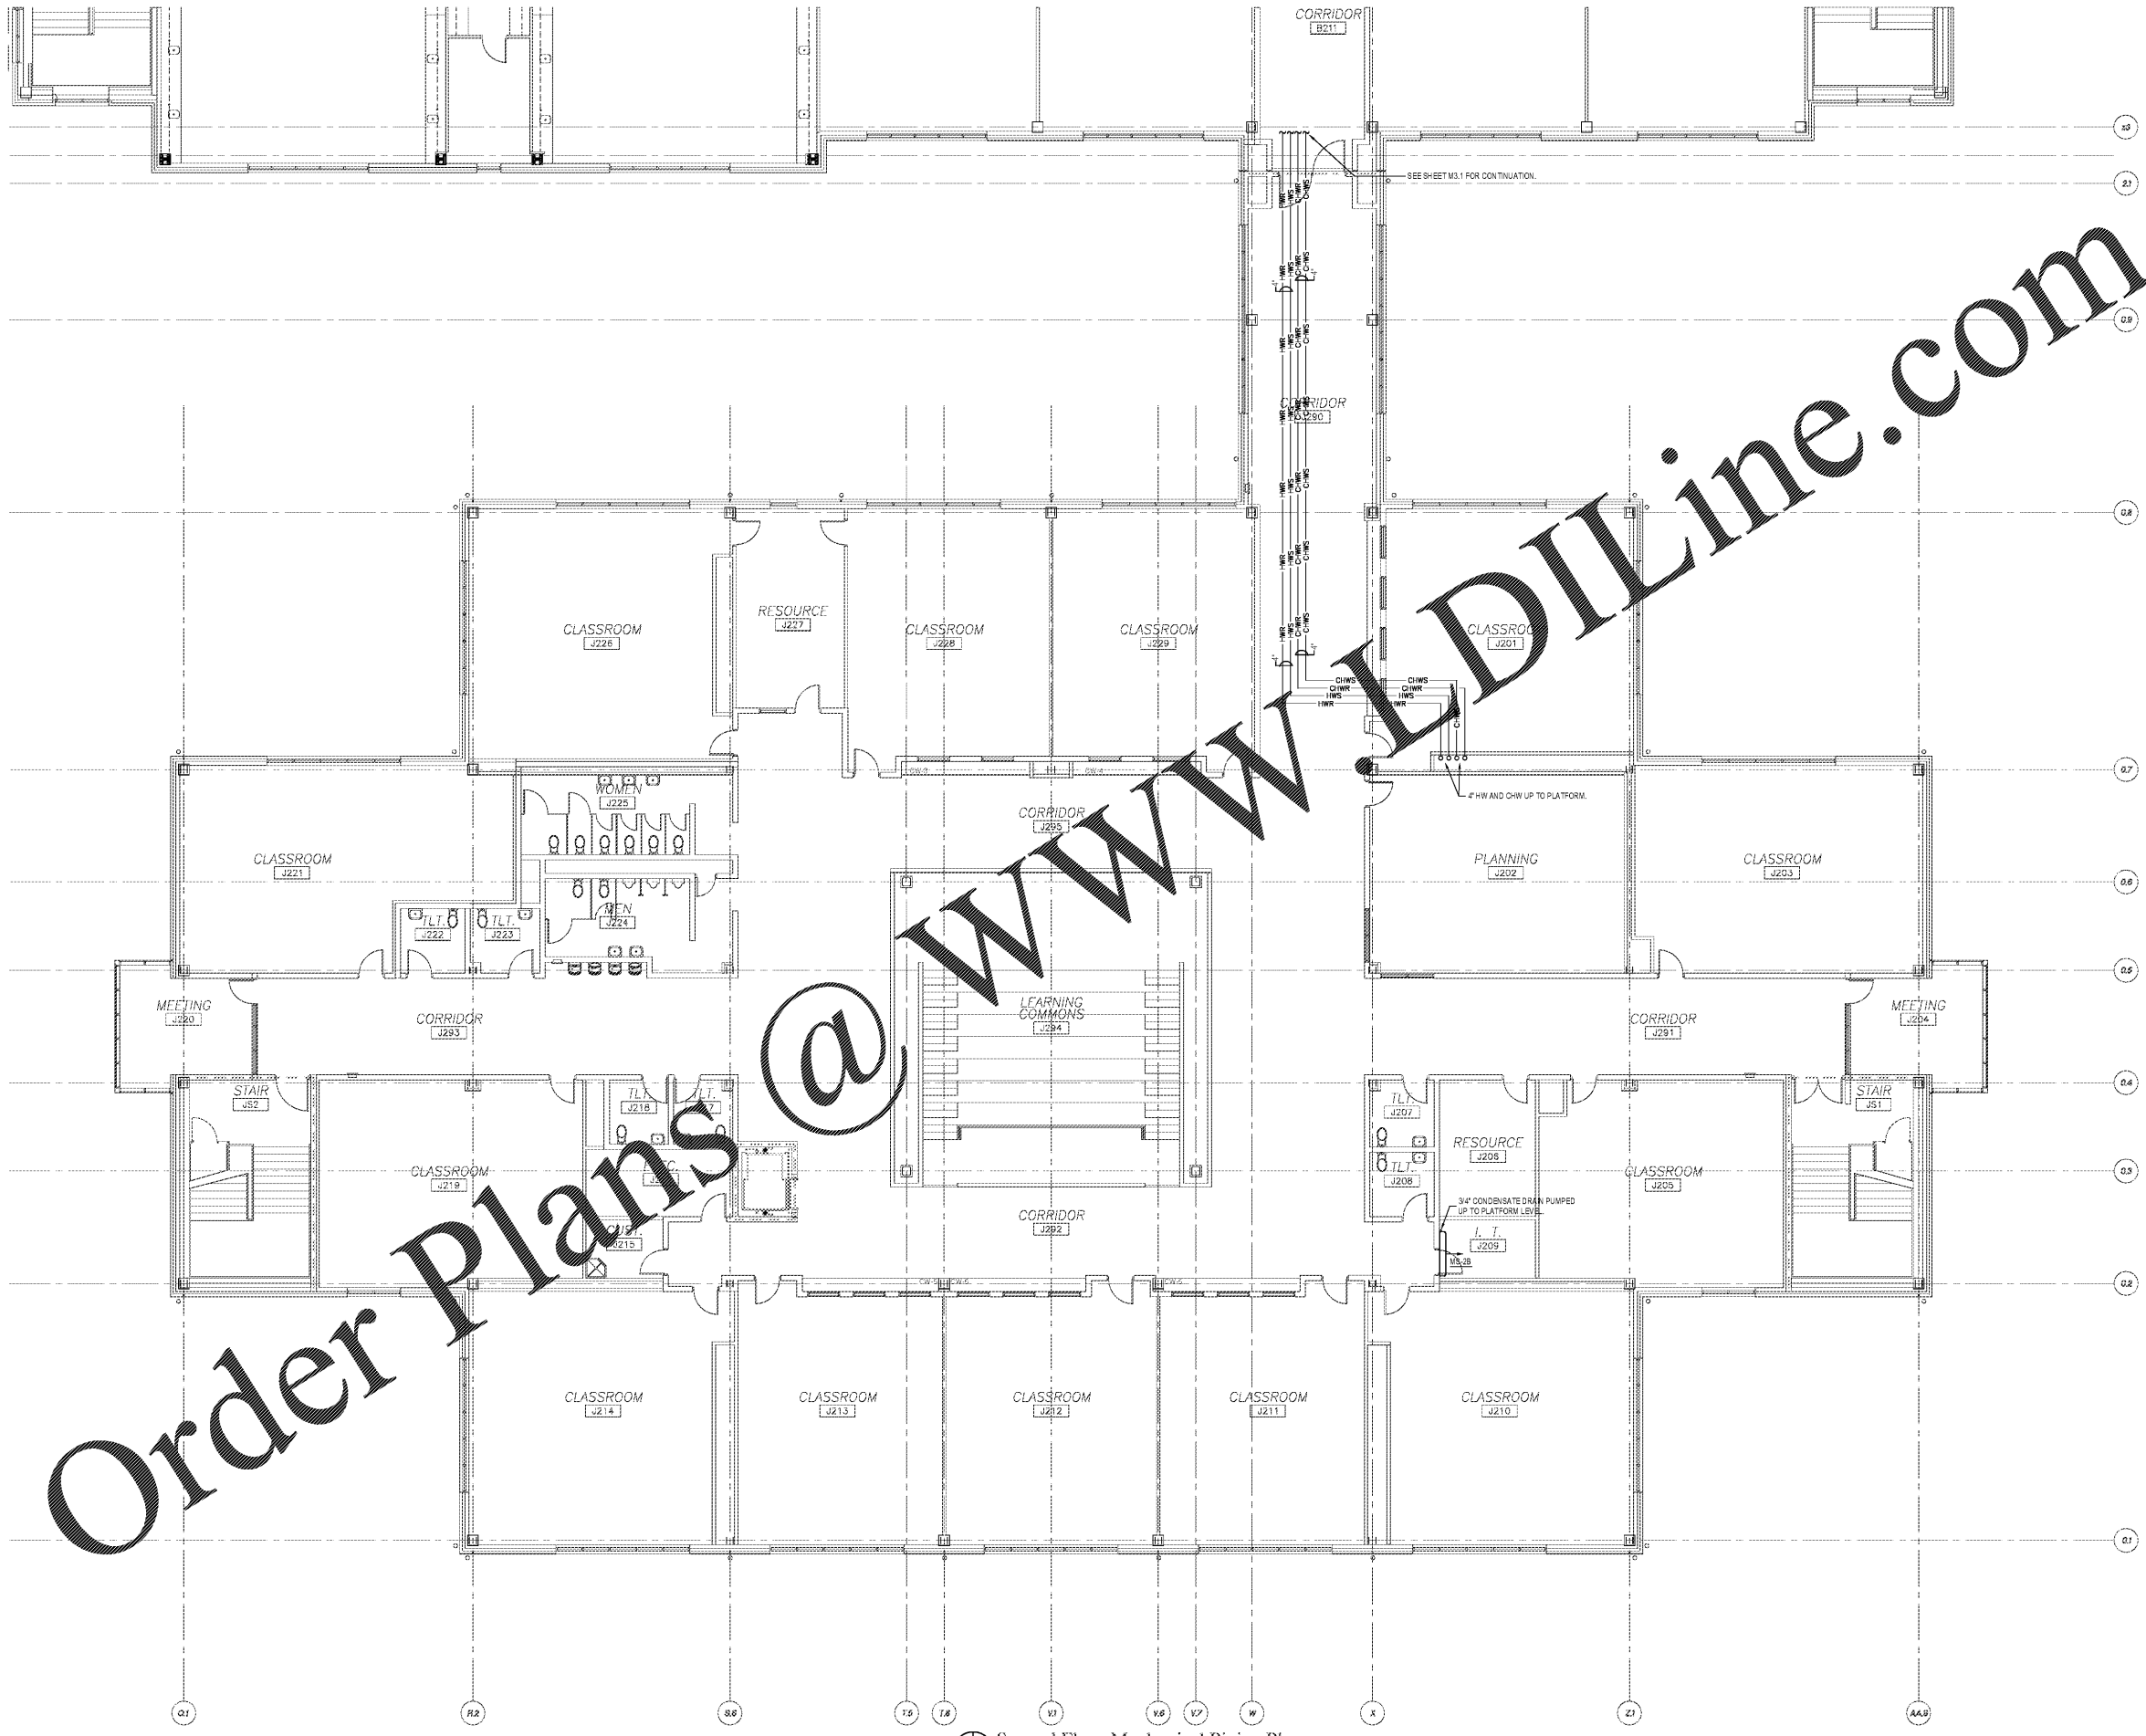


Second Floor Mechanical Piping Plan
Scale: 1/8" = 1'-0"

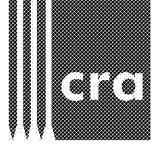

222 cloister court
chapel hill, nc 27514
919.401.8586
www.cra-nc.com



Cedar Ridge High School
Classroom Addition
Orange County Schools
1125 New Grady Brown School Road
Hillsborough, North Carolina

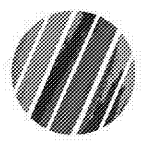

no.	revisions

The use of these notes and specifications shall be governed by the contract and the specifications. The notes and specifications shall be taken in conjunction with the drawings. The contractor shall be responsible for the interpretation of these notes and specifications and shall be held responsible for any errors or omissions.

drawn	checked
DM	MRM
Second Floor Mechanical Piping Plan	

sheet
M2.2

project no. 1716

date 4/25/19