


GRAPHIC SCALE 1/8"=1'-0"

GRAPHIC SCALE 1/8"=1'-0"


GRAPHIC SCALE 1/8"=1'-0"

THIS DRAWING IS NOT TO BE SCALED FOR CONSTRUCTION PURPOSES. THE SCALE WHEN INDICATED IS FOR GENERAL REFERENCE ONLY.

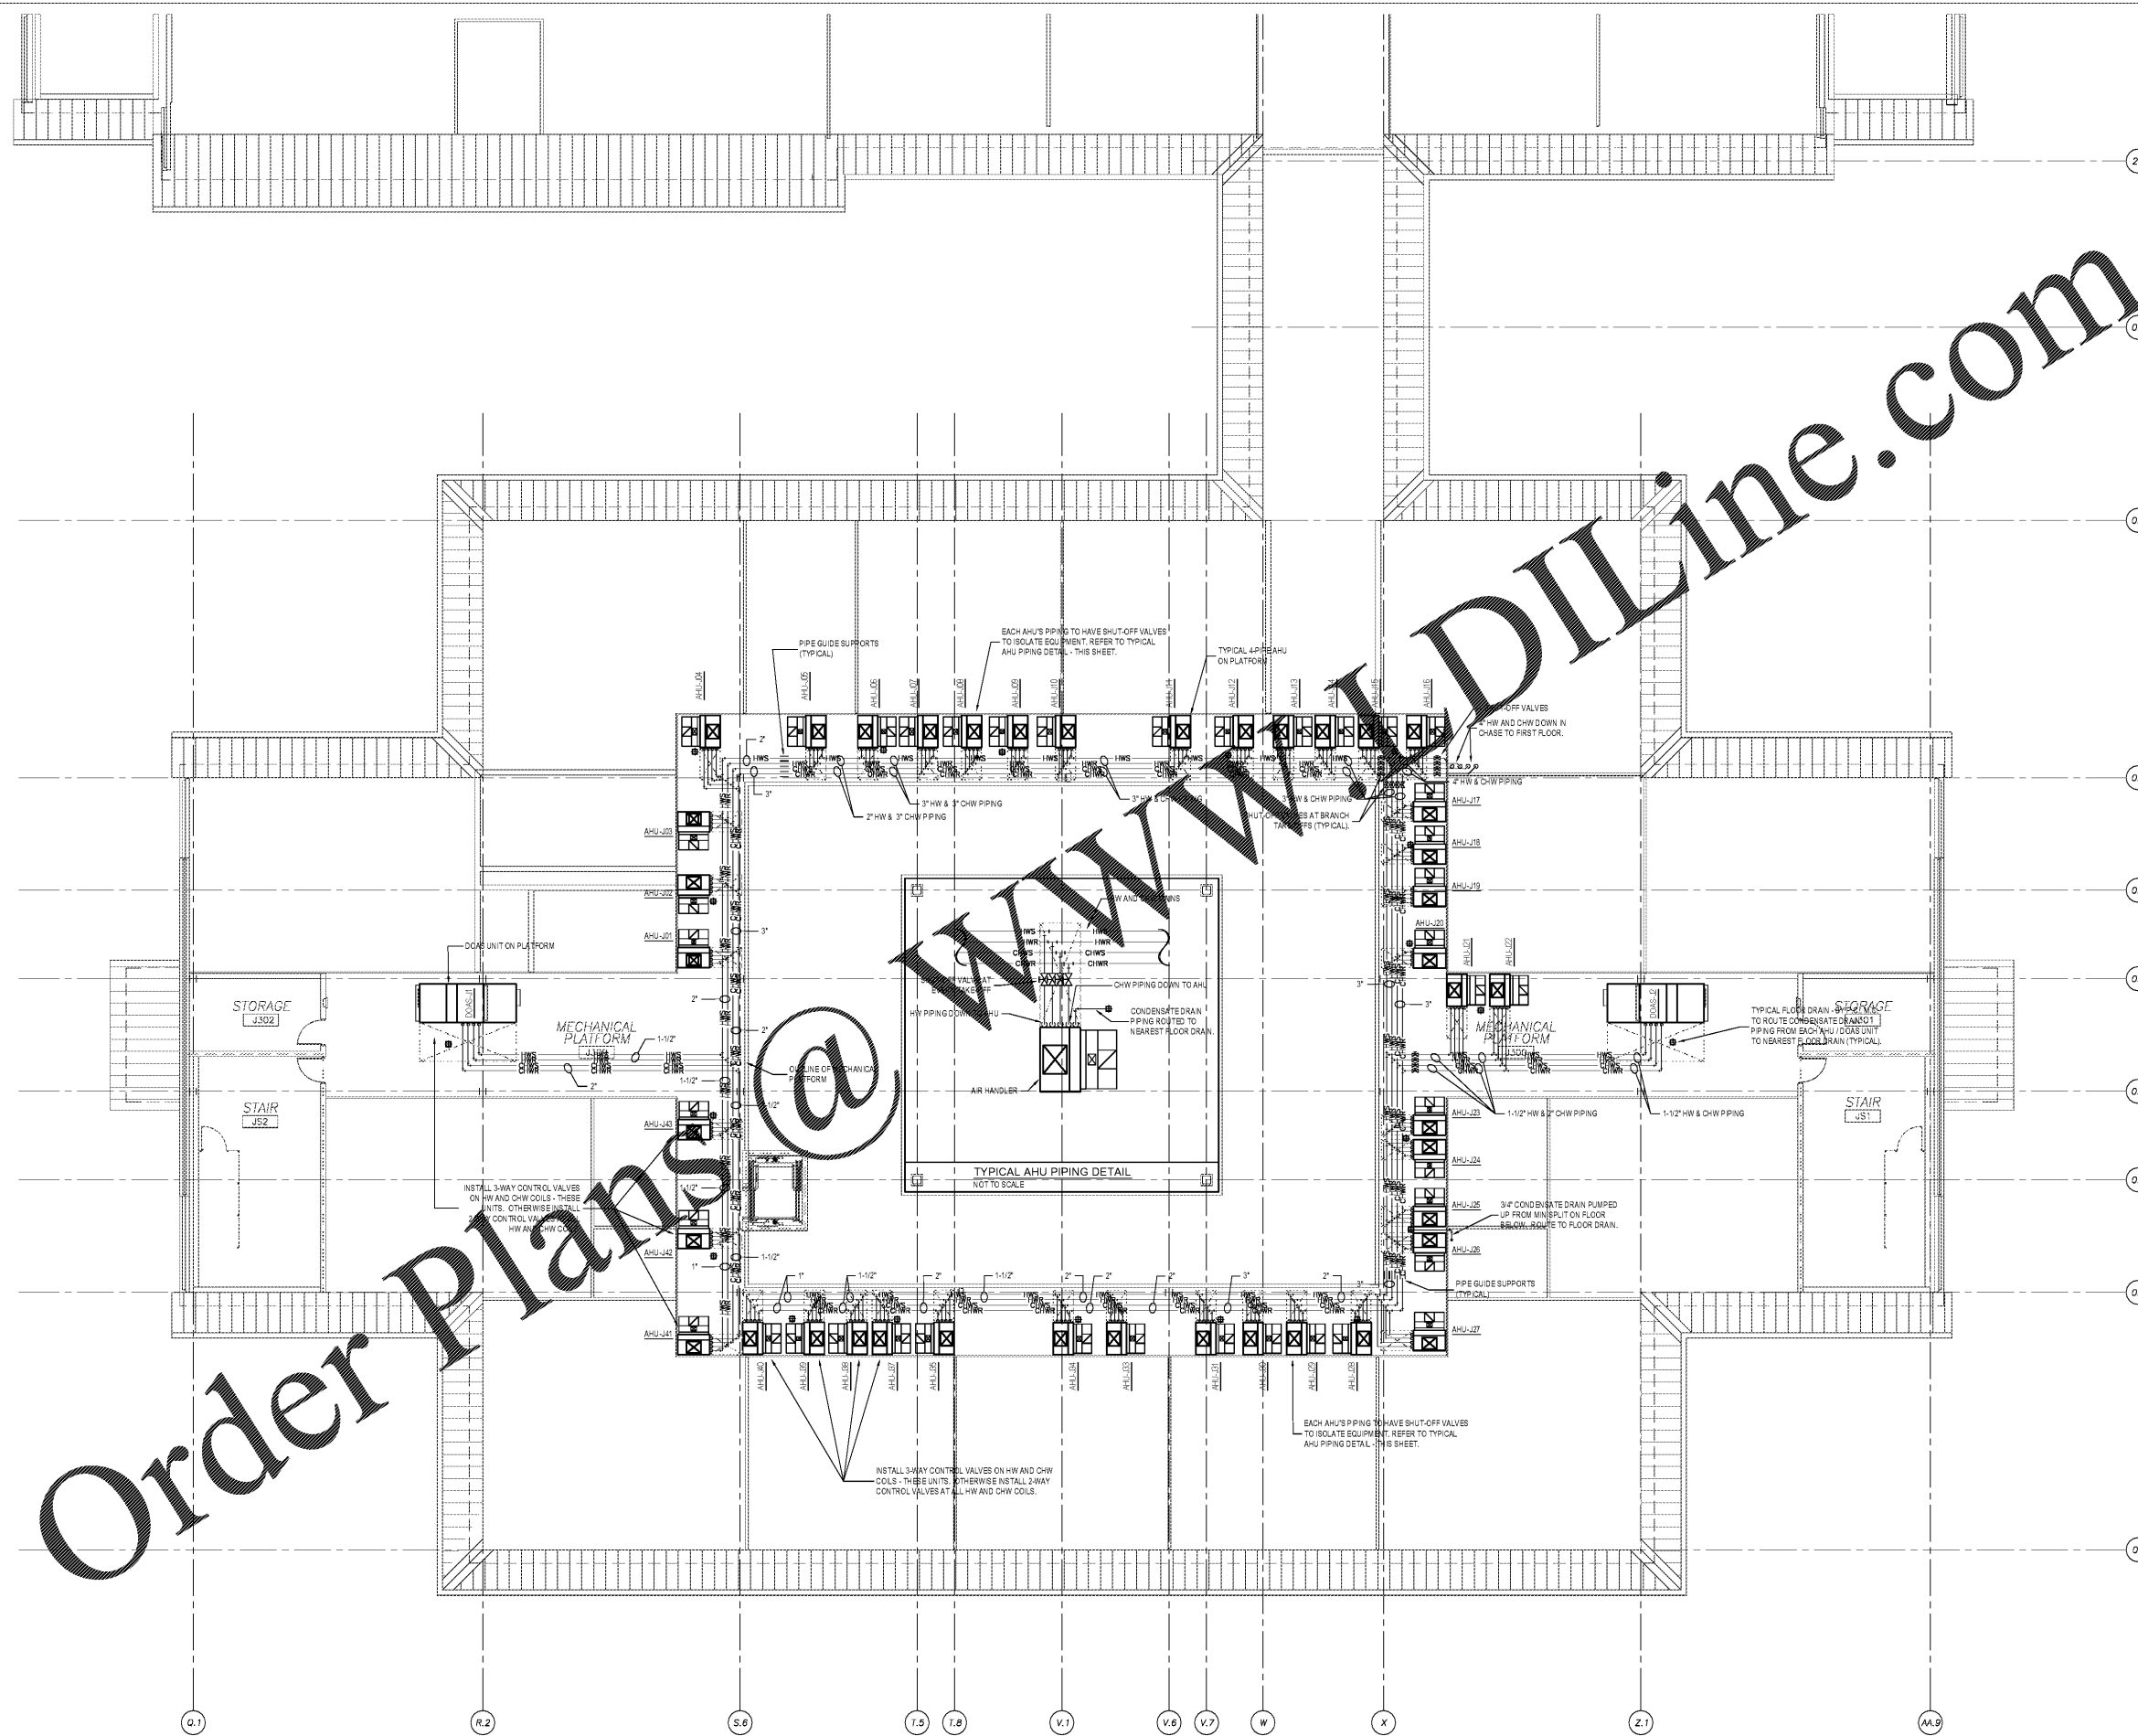

Order Plans @ WWW.DIline.com


Platform Level Mechanical Piping Plan
Scale: 1/8" = 1'-0"

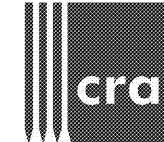

222 cloister court
chapel hill, nc 27514
919.401.8586
www.cra-nc.com



Cedar Ridge High School
Classroom Addition
Orange County Schools
1125 New Grady Brown School Road
Hillsborough, North Carolina

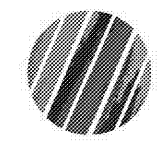

no. revisions

The use of these plans and specifications shall be restricted to the project and for which they were prepared and published. They shall not be used for any other project without the express written consent of the engineer. The engineer shall not be responsible for any errors or omissions in these plans and specifications and shall not be liable for any damages or losses resulting from their use or the construction of these structures.

drawn checked
DIM MRM
Platform Level
Mechanical
Piping Plan

sheet
M2.3

project no. 1716

date 4/25/19