


GRAPHIC SCALE 1/4" = 1'-0"


GRAPHIC SCALE 1/8" = 1'-0"

GRAPHIC SCALE 1/8" = 1'-0"

THIS DRAWING IS NOT TO BE SCALED FOR CONSTRUCTION PURPOSES. THE SCALE WHEN INDICATED IS FOR GENERAL REFERENCE ONLY.

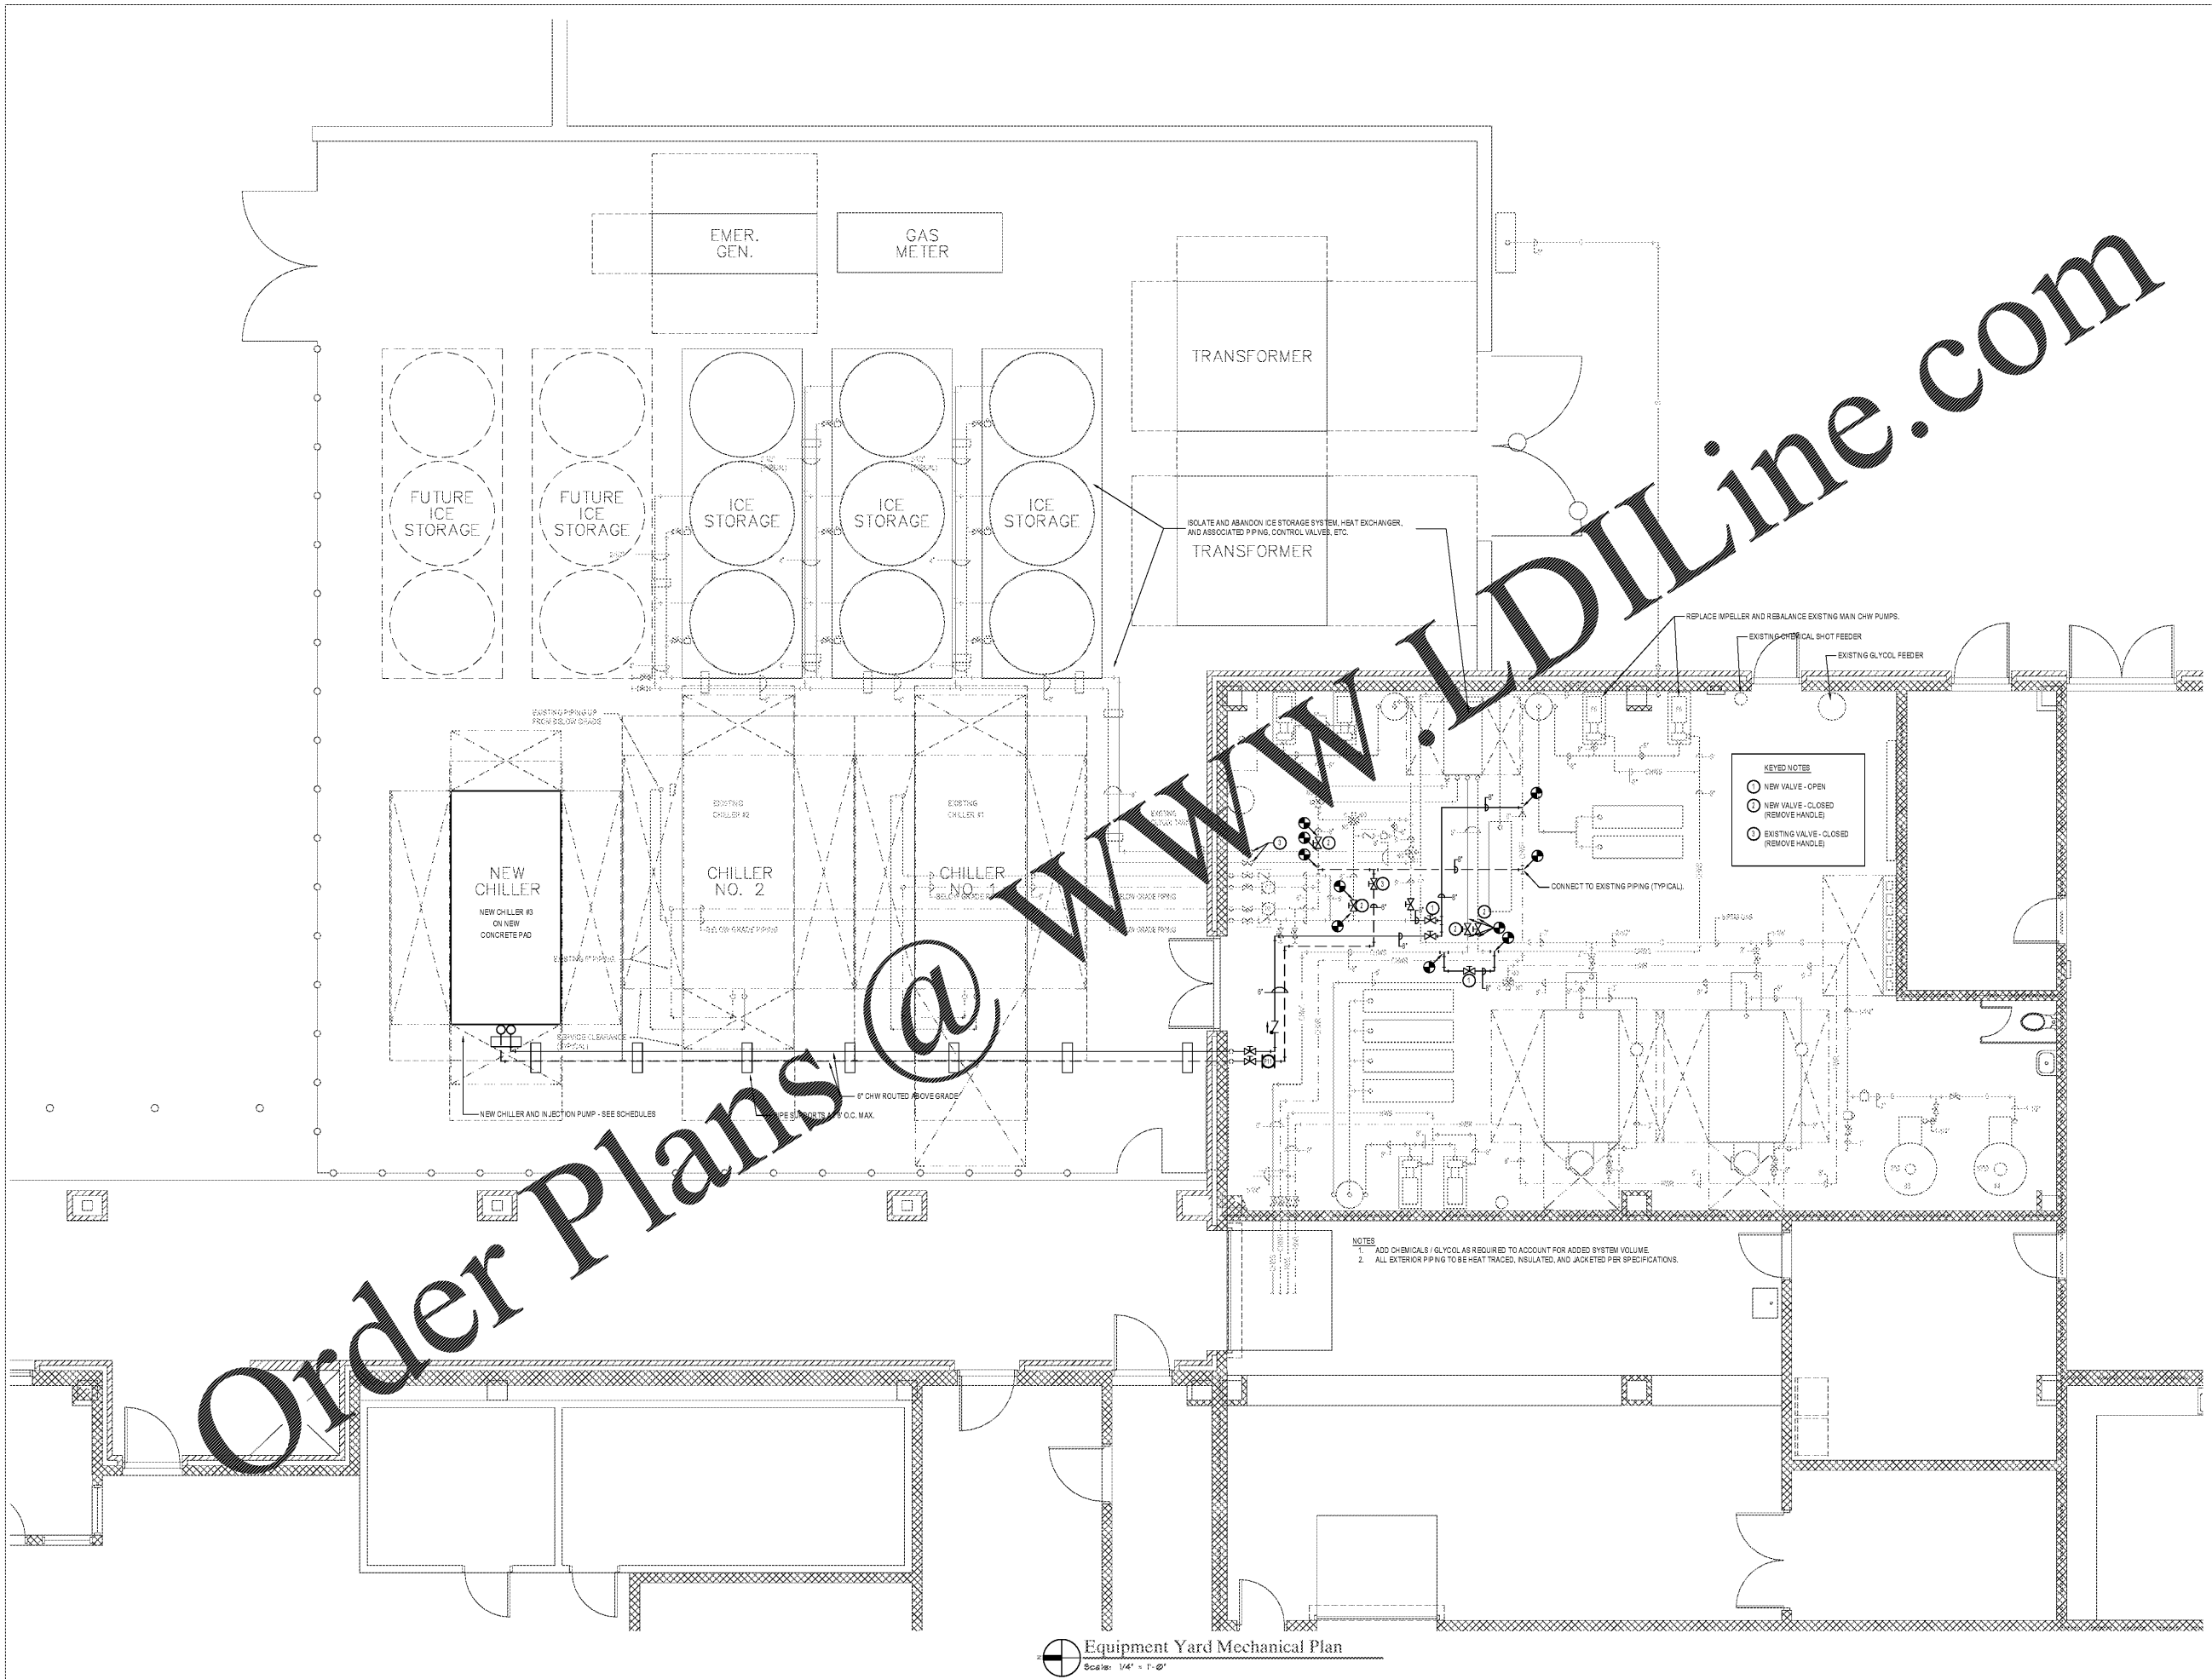


Order Plans @ WWW.DILine.com

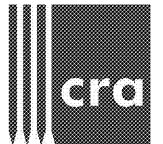

222 cloister court  
chapel hill, nc 27514  
919.401.8586  
www.cra-nc.com



Cedar Ridge High School  
Classroom Addition  
Orange County Schools  
1125 New Grady Brown School Road  
Hillsborough, North Carolina

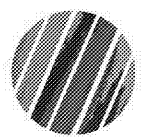

no.	revisions

The use of these notes and specifications shall be restricted to the project and shall not be used for any other project without the express written consent of the engineer. The engineer shall not be responsible for any errors or omissions in these specifications and shall not be held liable for any damages or losses resulting from the use of these specifications.

drawn	checked
DM	MRM
Equipment Yard Mechanical Plan	

sheet  
**M3.2**

project no. 1716

date 4/25/19