



GRAPHIC SCALE 1/8"=1'-0"  
 GRAPHIC SCALE 1/16"=1'-0"  
 GRAPHIC SCALE 1/16"=1'-0"

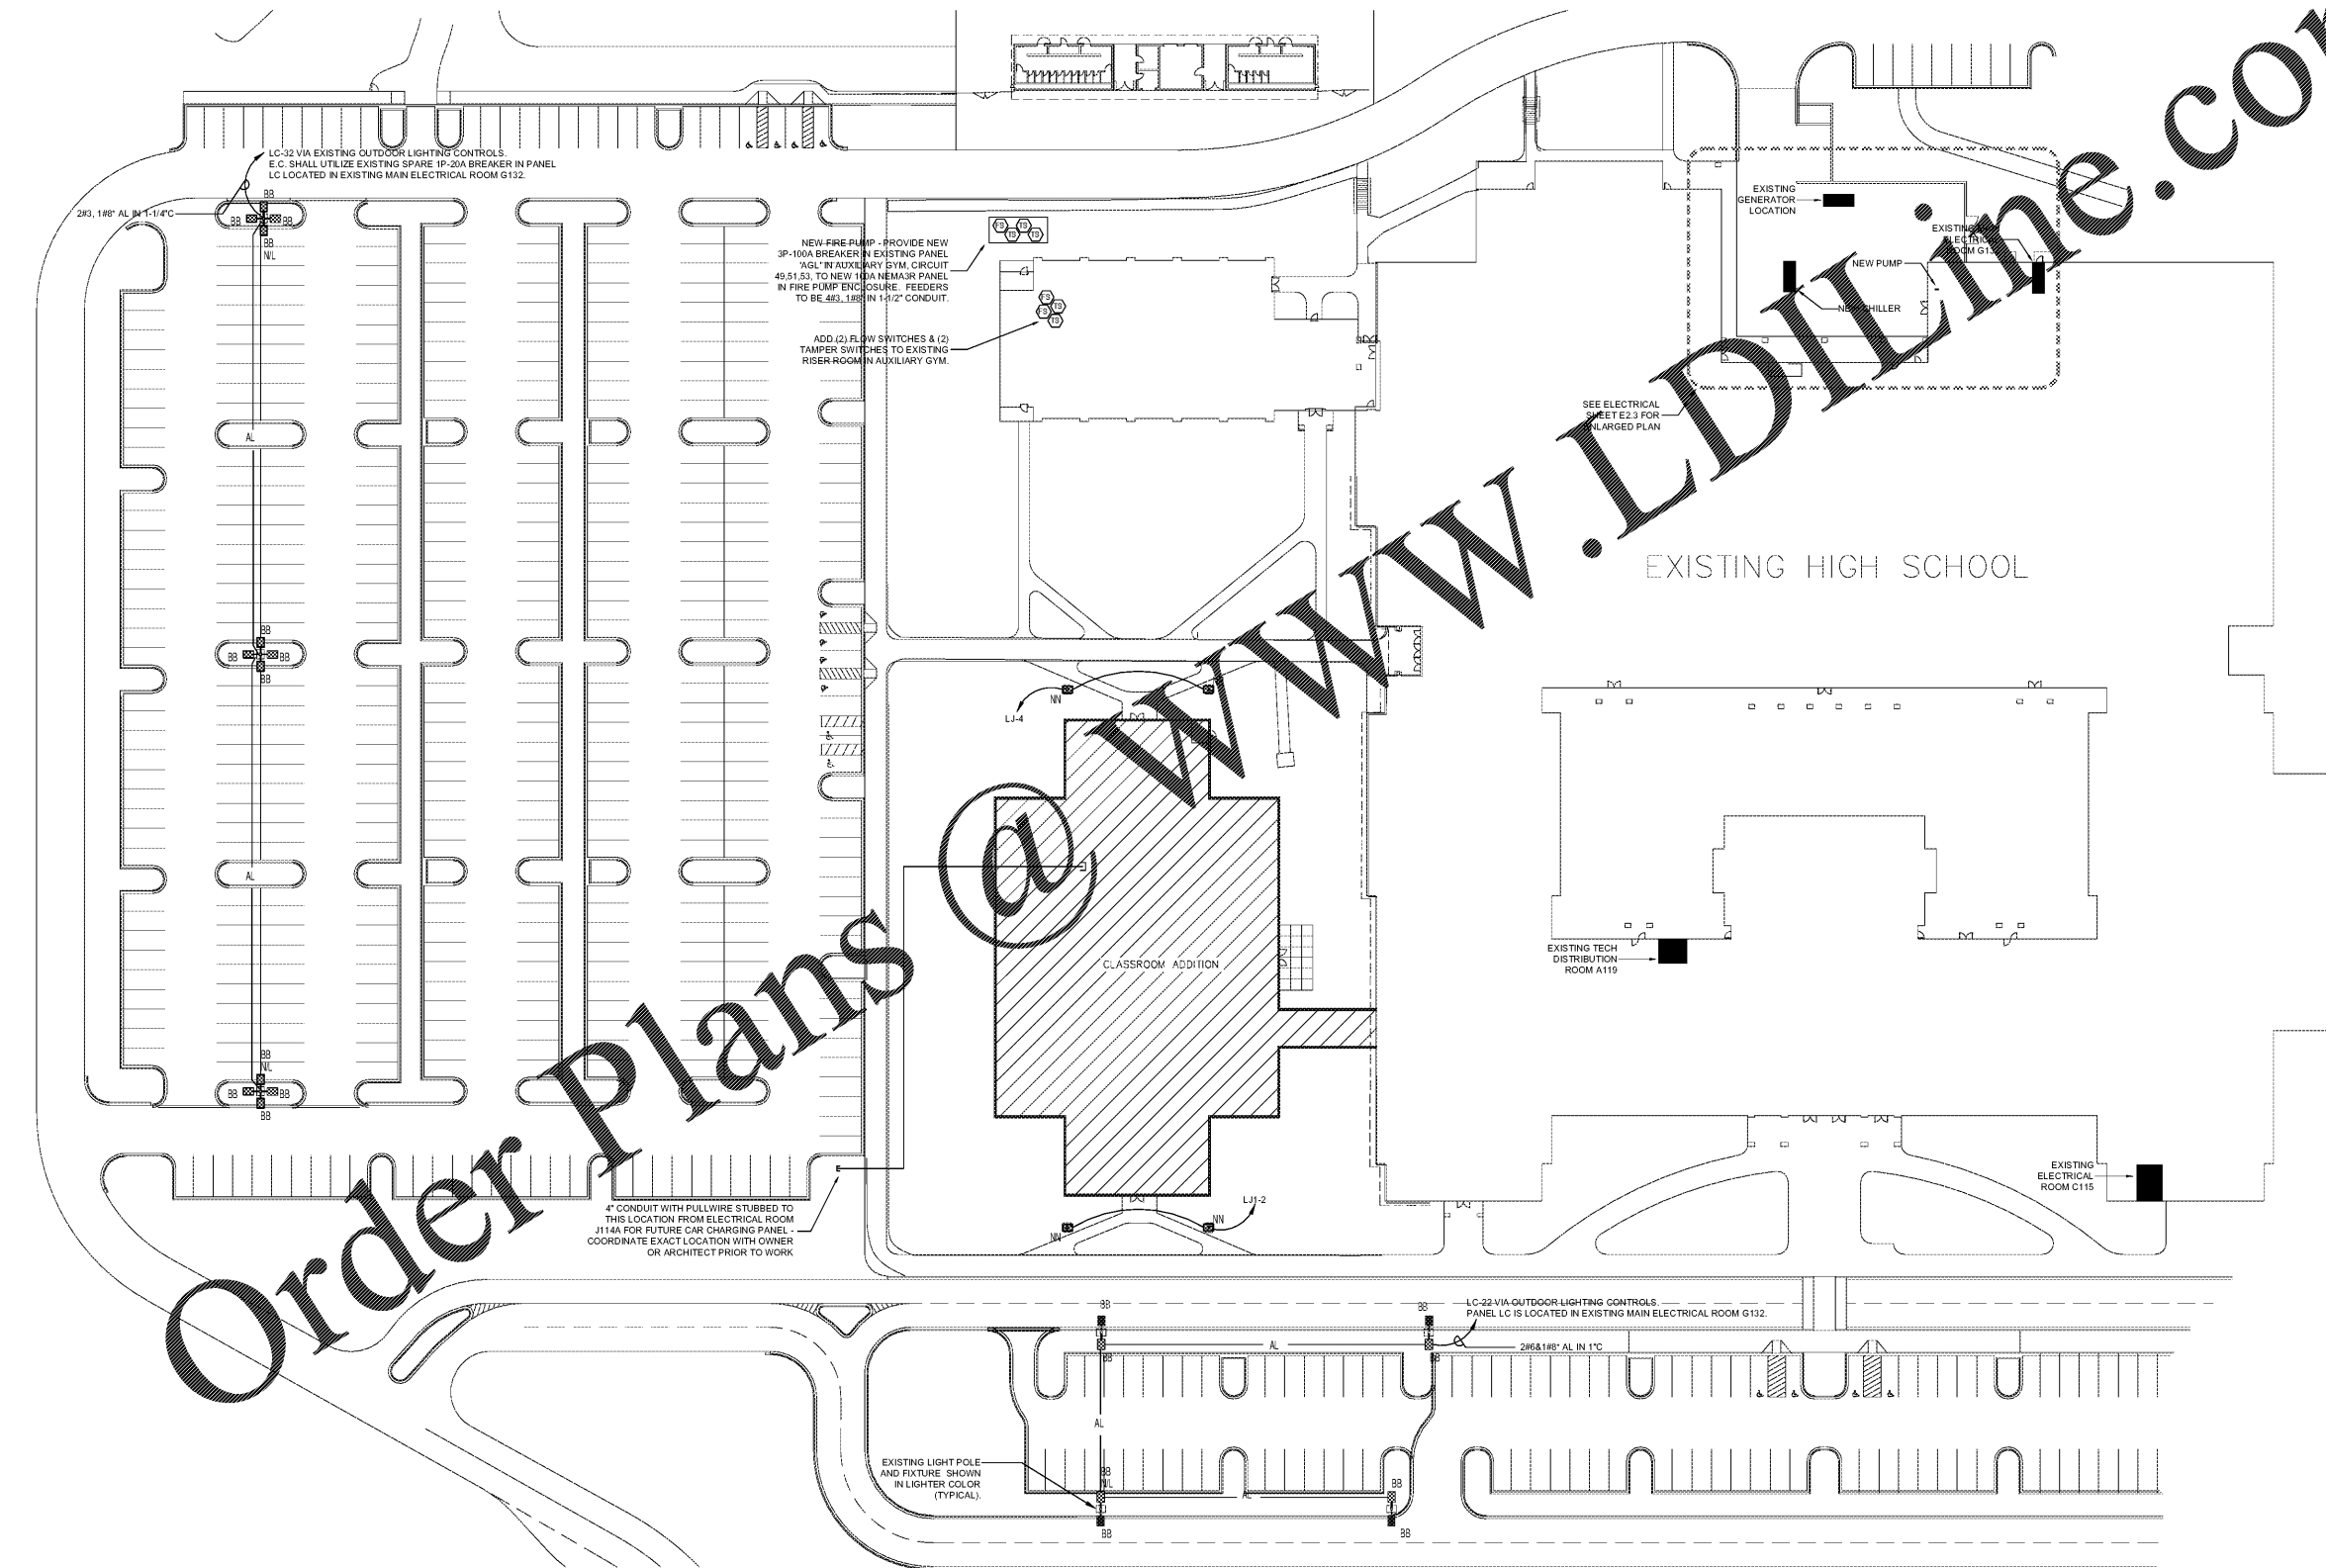

Order Plans @

THIS DRAWING IS NOT TO BE SCALED FOR CONSTRUCTION PURPOSES. THE SCALE WHEN INDICATED IS FOR GENERAL REFERENCE ONLY.


Electrical Site Plan  
 Scale: 1/32" = 1'-0"

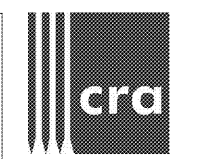

222 cloister court  
 chapel hill, nc 27514  
 919.401.8586  
 www.cra-ae.com



Cedar Ridge High School  
 Classroom Addition  
 Orange County Schools  
 1125 New Grady Brown School Road  
 Hillsborough, North Carolina

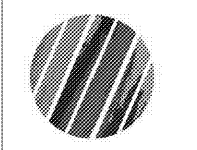

no.	revisions

The use of these plans and specifications shall be restricted to the project for which they were prepared and shall not be used for any other project without the prior written consent of the engineer. The engineer shall not be responsible for any errors or omissions in these plans and specifications, nor for any consequences arising from their use. The contractor shall be responsible for the interpretation and application of these plans and specifications.

drawn checked  
 JWC JSD  
 Electrical  
 Site Plan

sheet  
**E1.1**

project no. 1716

date 4/25/19