



GRAPHIC SCALE 1/4"=1'-0"
 GRAPHIC SCALE 1/8"=1'-0"
 GRAPHIC SCALE 1/16"=1'-0"

Order Plans @ www.DILine.com

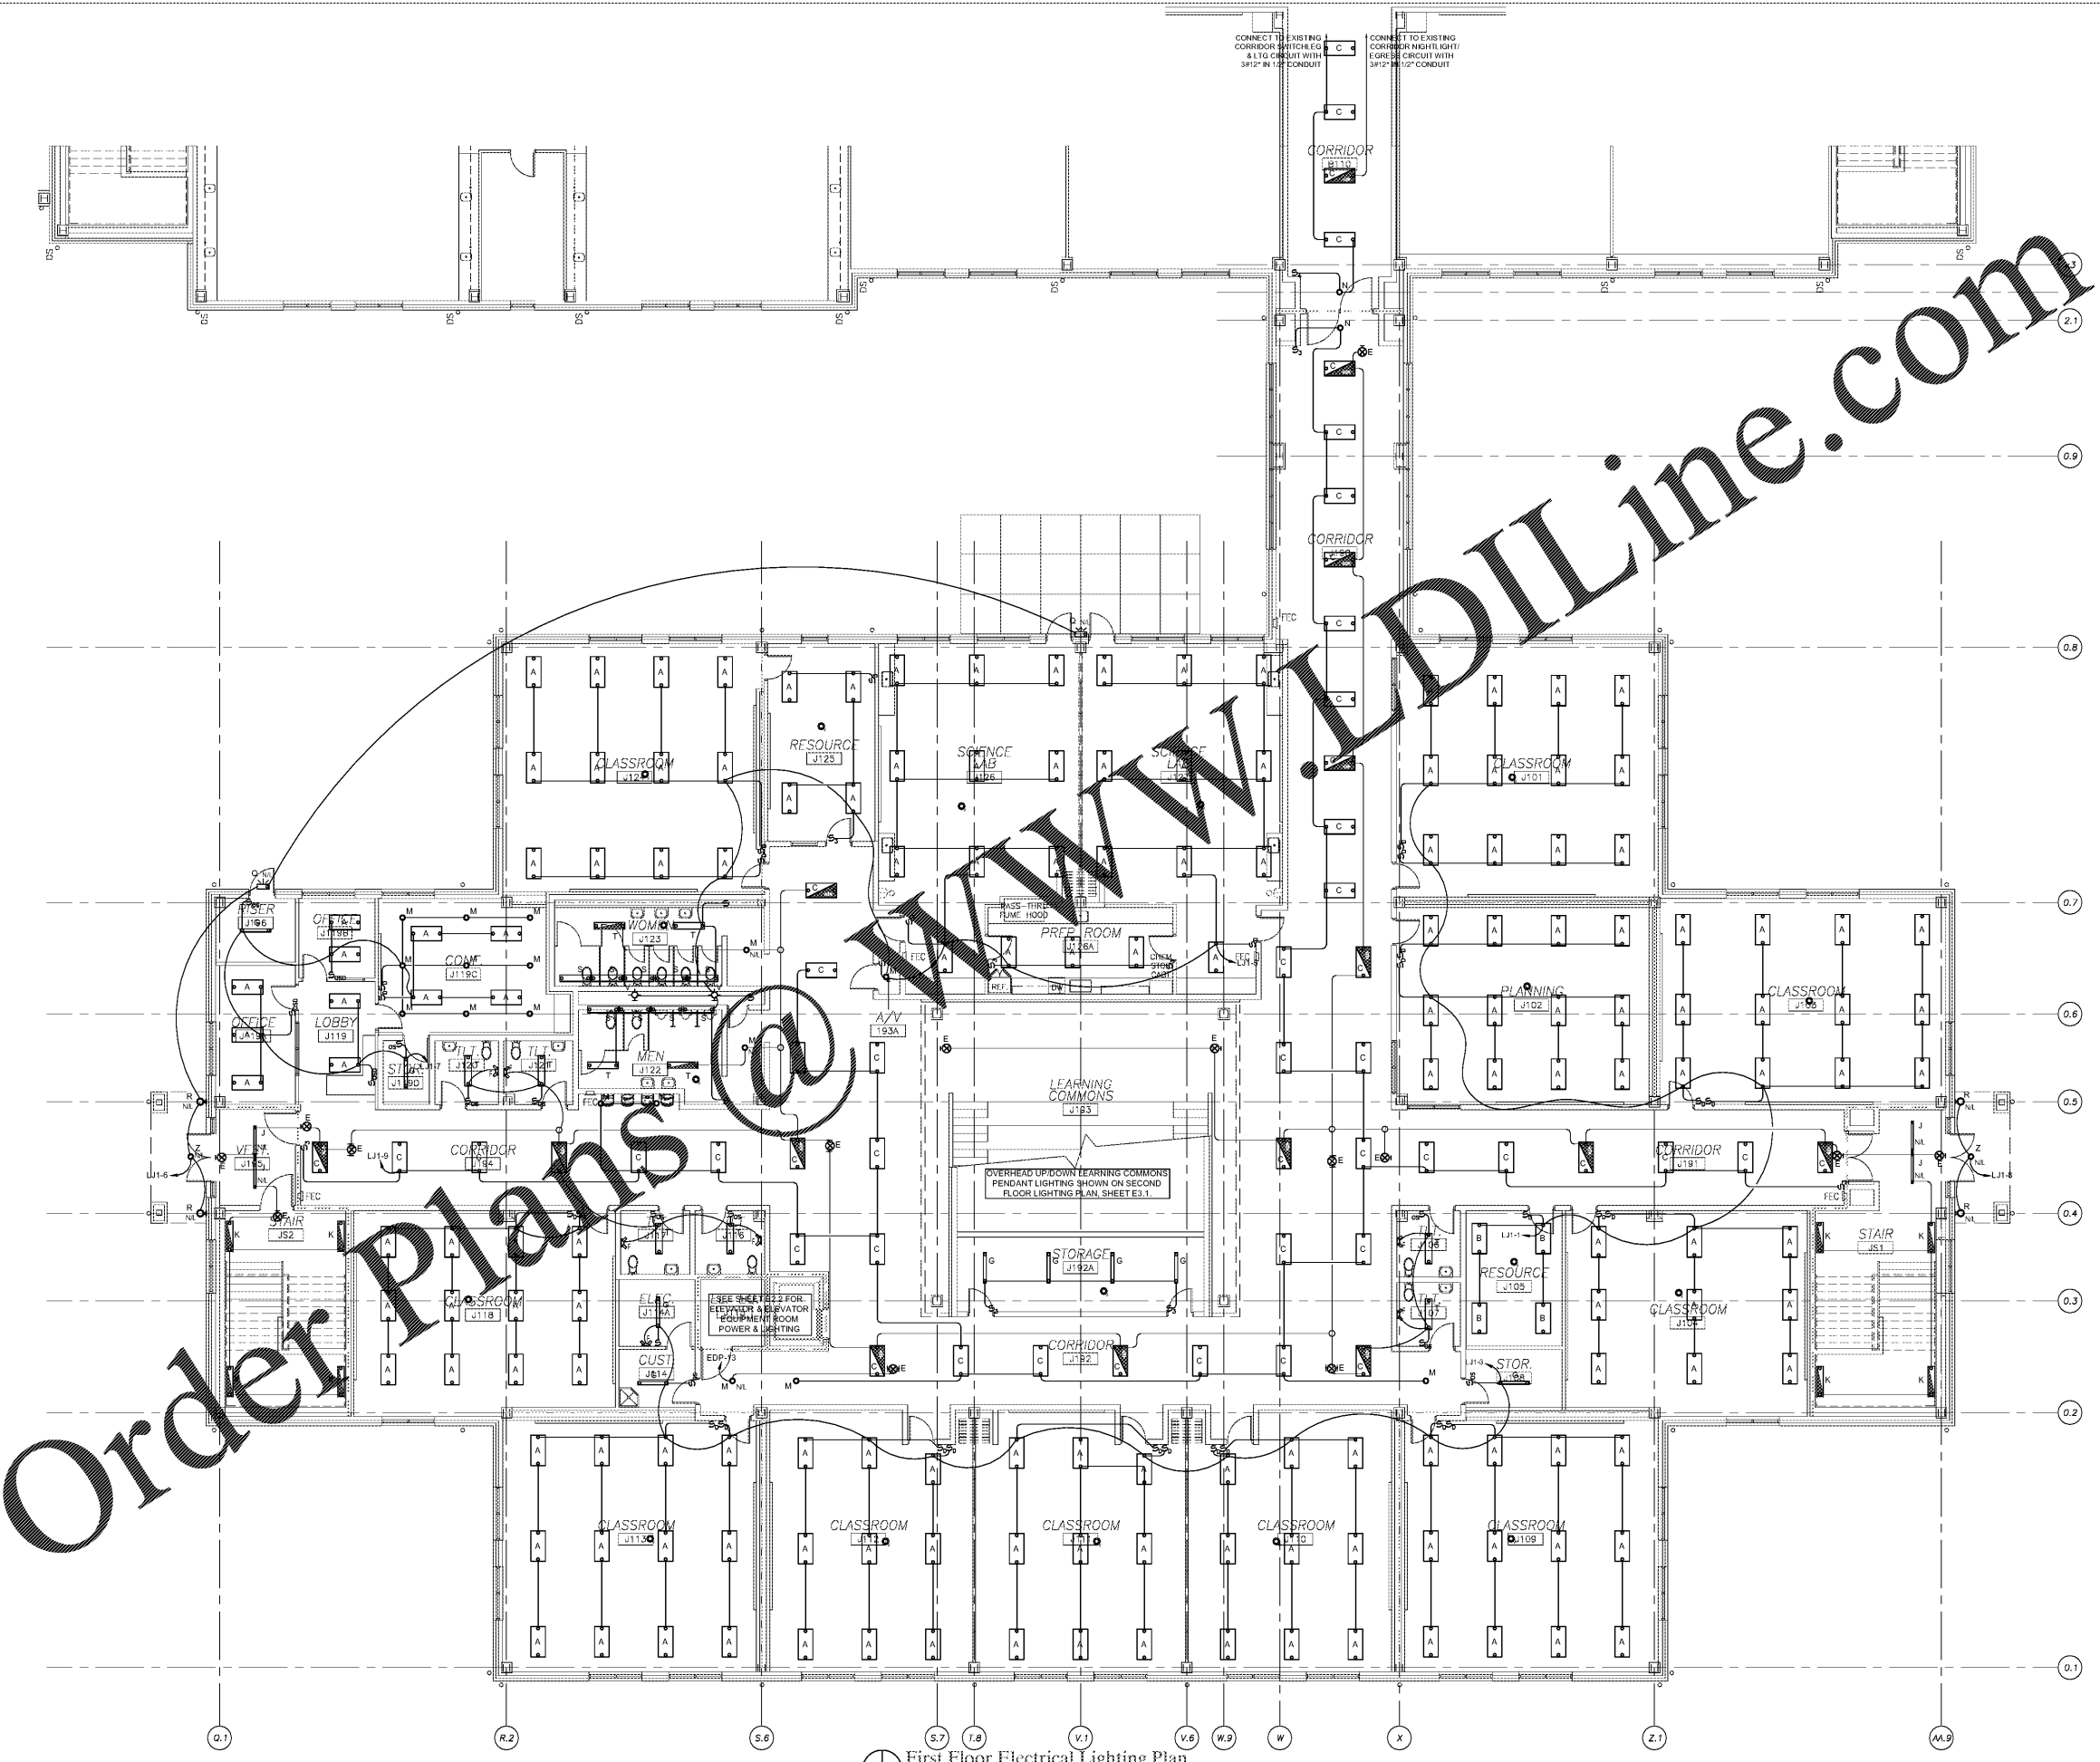

First Floor Electrical Lighting Plan
 Scale: 1/8" = 1'-0"


THIS DRAWING IS NOT TO BE SCALED FOR CONSTRUCTION PURPOSES. THE SCALE WHEN INDICATED IS FOR GENERAL REFERENCE ONLY.

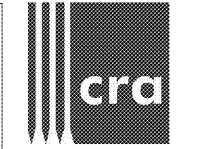

222 cloister court
 chapel hill, nc 27514
 919.401.8586
 www.cra-ae.com



Cedar Ridge High School
 Classroom Addition
 Orange County Schools
 1125 New Grady Brown School Road
 Hillsborough, North Carolina

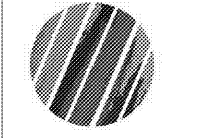

no.	revisions

The use of these plans and specifications shall be restricted to the project for which they were prepared and shall not be used for any other project without the prior written consent of the architect. The contractor shall be responsible for the accuracy of the information provided on these plans and specifications. The contractor shall verify the accuracy of the information provided on these plans and specifications. The contractor shall be responsible for the accuracy of the information provided on these plans and specifications.

drawn checked
 FWC JSD
 First Floor
 Electrical
 Lighting Plan
 sheet

E2.1

project no. 1716

date 4/25/19