


222 cloister court  
 chapel hill, nc 27514  
 919.401.8586  
 www.cra-ae.com

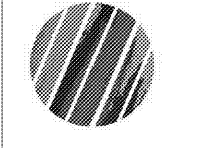

Cedar Ridge High School  
 Classroom Addition  
 Orange County Schools  
 1125 New Grady Brown School Road  
 Hillsborough, North Carolina



no.	revisions


The use of these sheets and specifications shall be restricted to the project for which they were prepared and shall not be used for any other project without the written consent of the architect, engineer, or contractor. The contractor shall be responsible for the accuracy of the information provided on these sheets and shall verify the existence of the conditions of these sheets.

drawn checked  
 JWC JSD  
 1st Floor Electrical  
 Power, Receptacle &  
 Fire Alarm Plan


sheet  
**E2.2**

project no. 1716

date 4/25/19

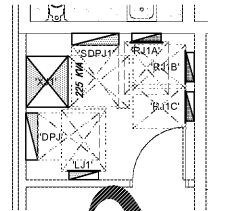

Enlarged Electrical Floor Plan  
 Electrical Room J114

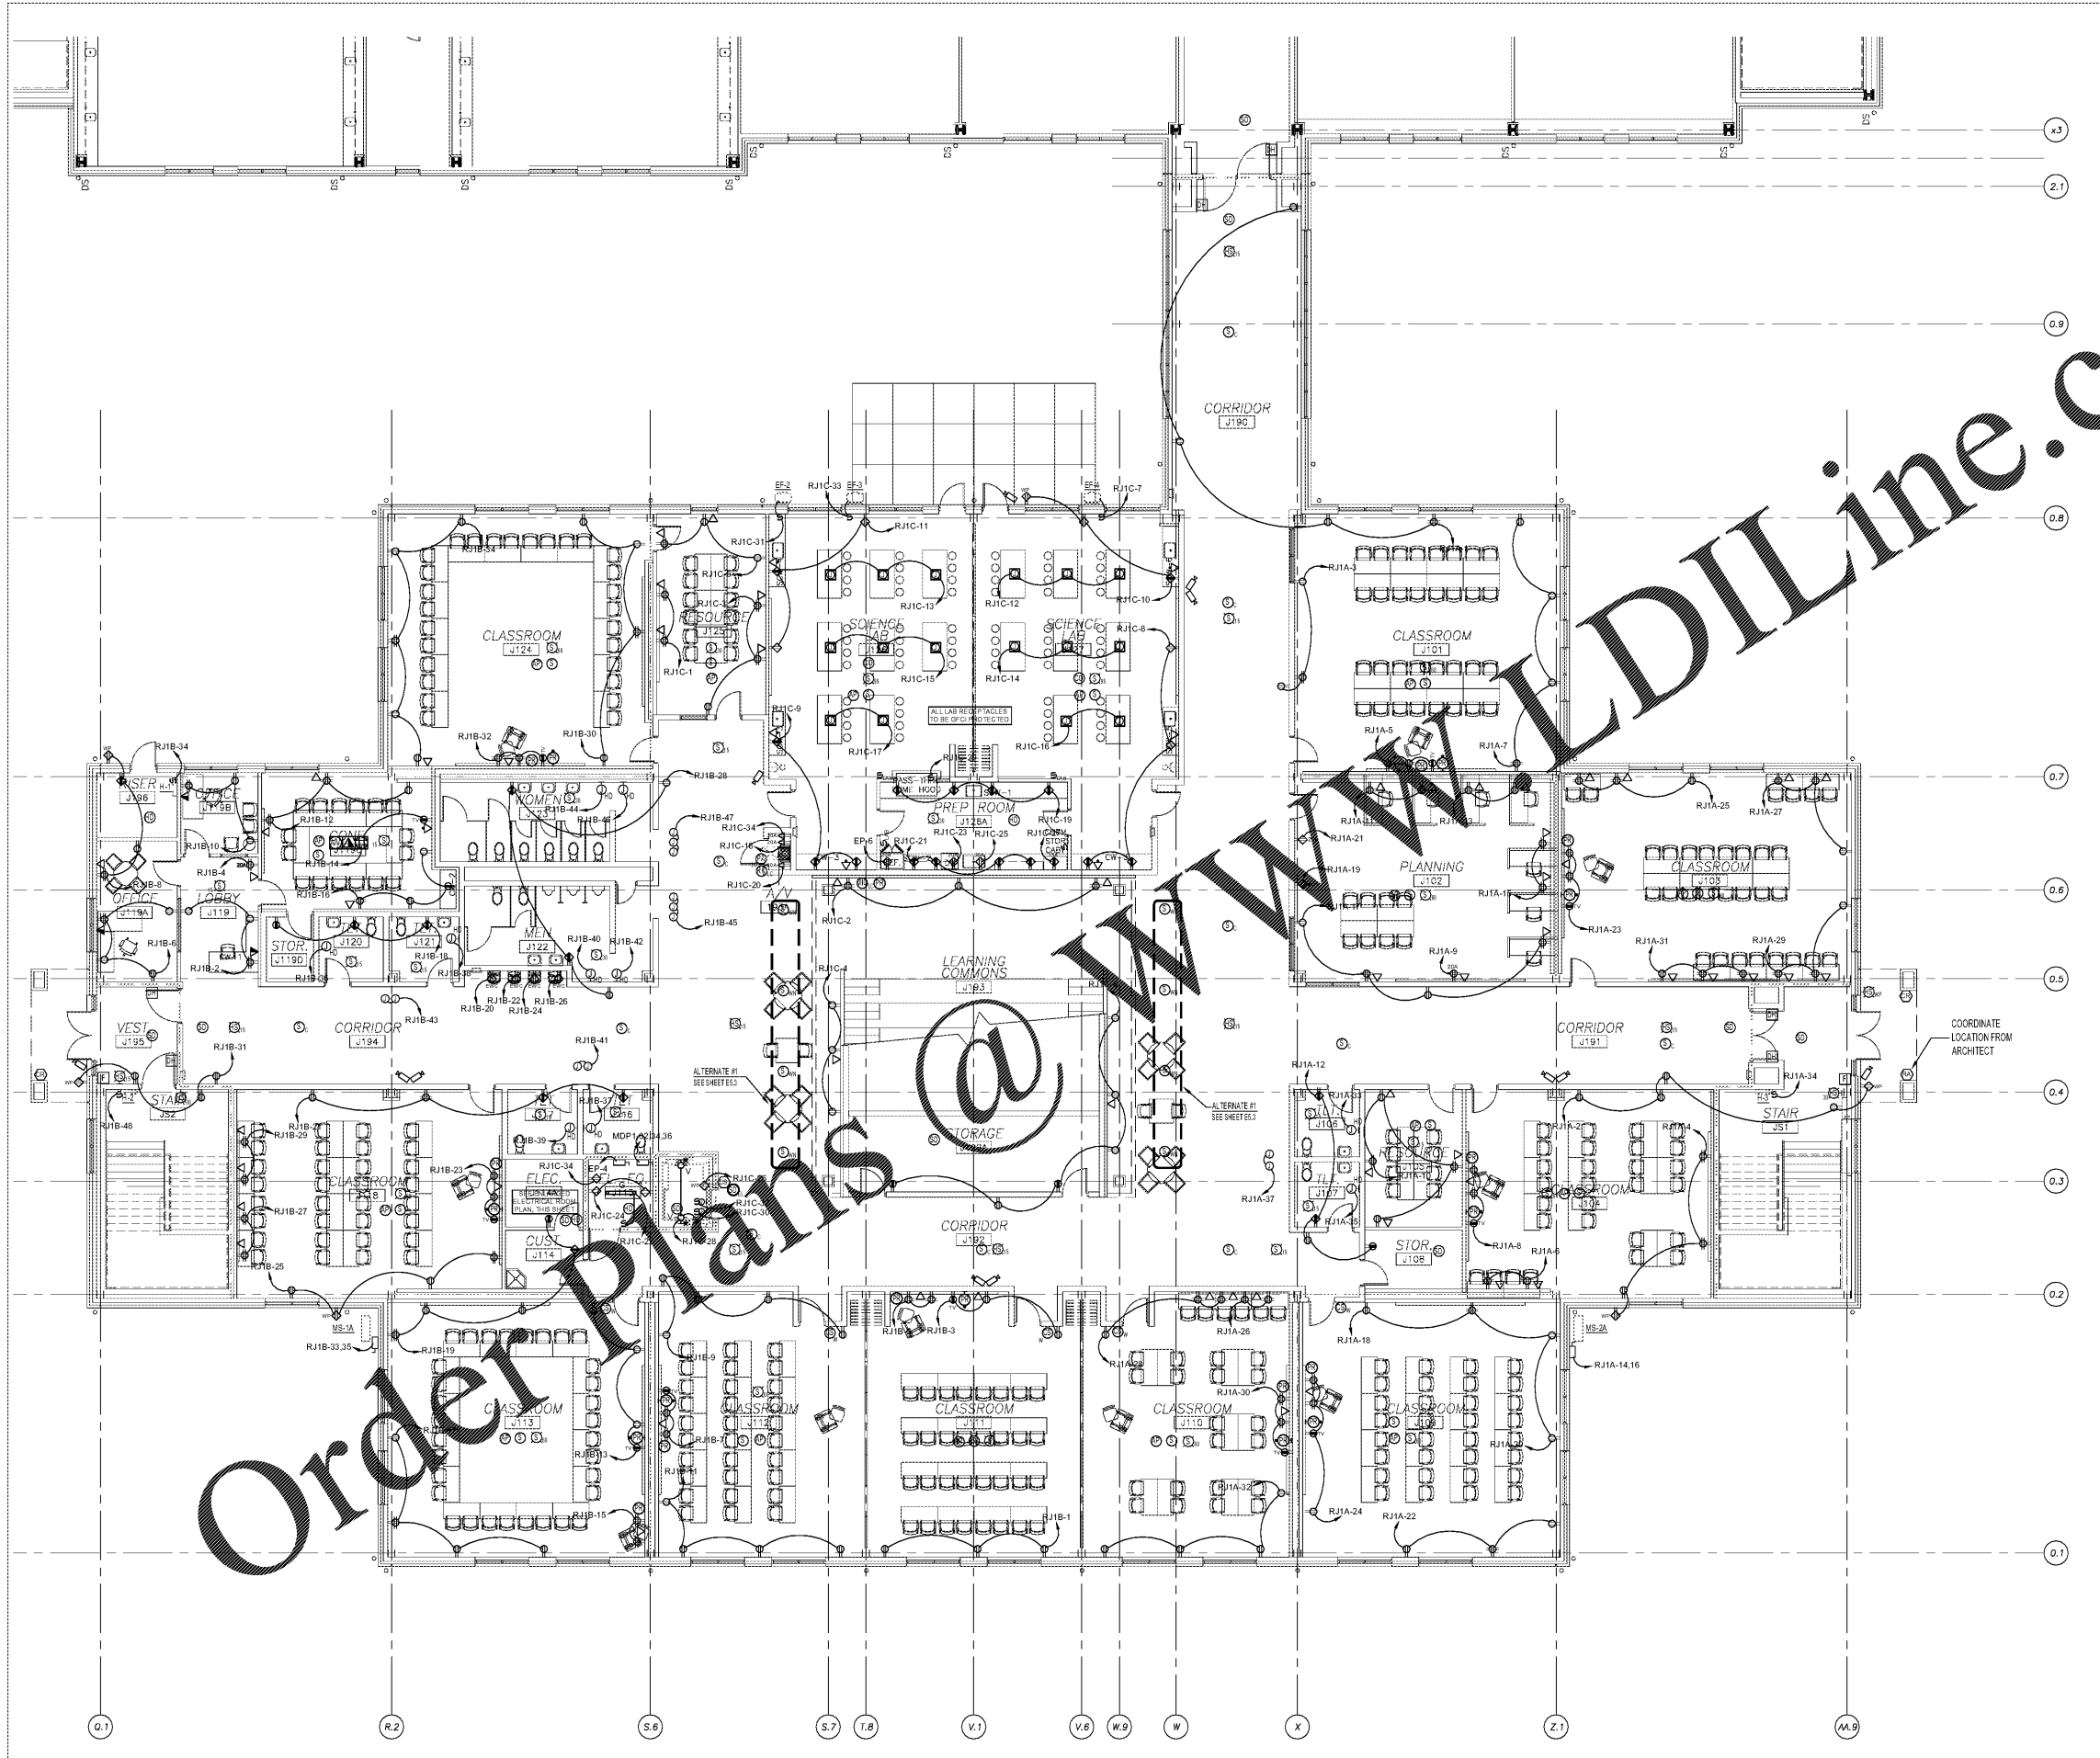

First Floor Electrical Power, Receptacle & Fire Alarm Plan  
 Scale: 1/8" = 1'-0"

THIS DRAWING IS NOT TO BE SCALED FOR CONSTRUCTION PURPOSES. THE SCALE WHEN INDICATED IS FOR GENERAL REFERENCE ONLY.