


GRAPHIC SCALE 1/4"=1'-0"
 GRAPHIC SCALE 1/8"=1'-0"
 GRAPHIC SCALE 1/16"=1'-0"

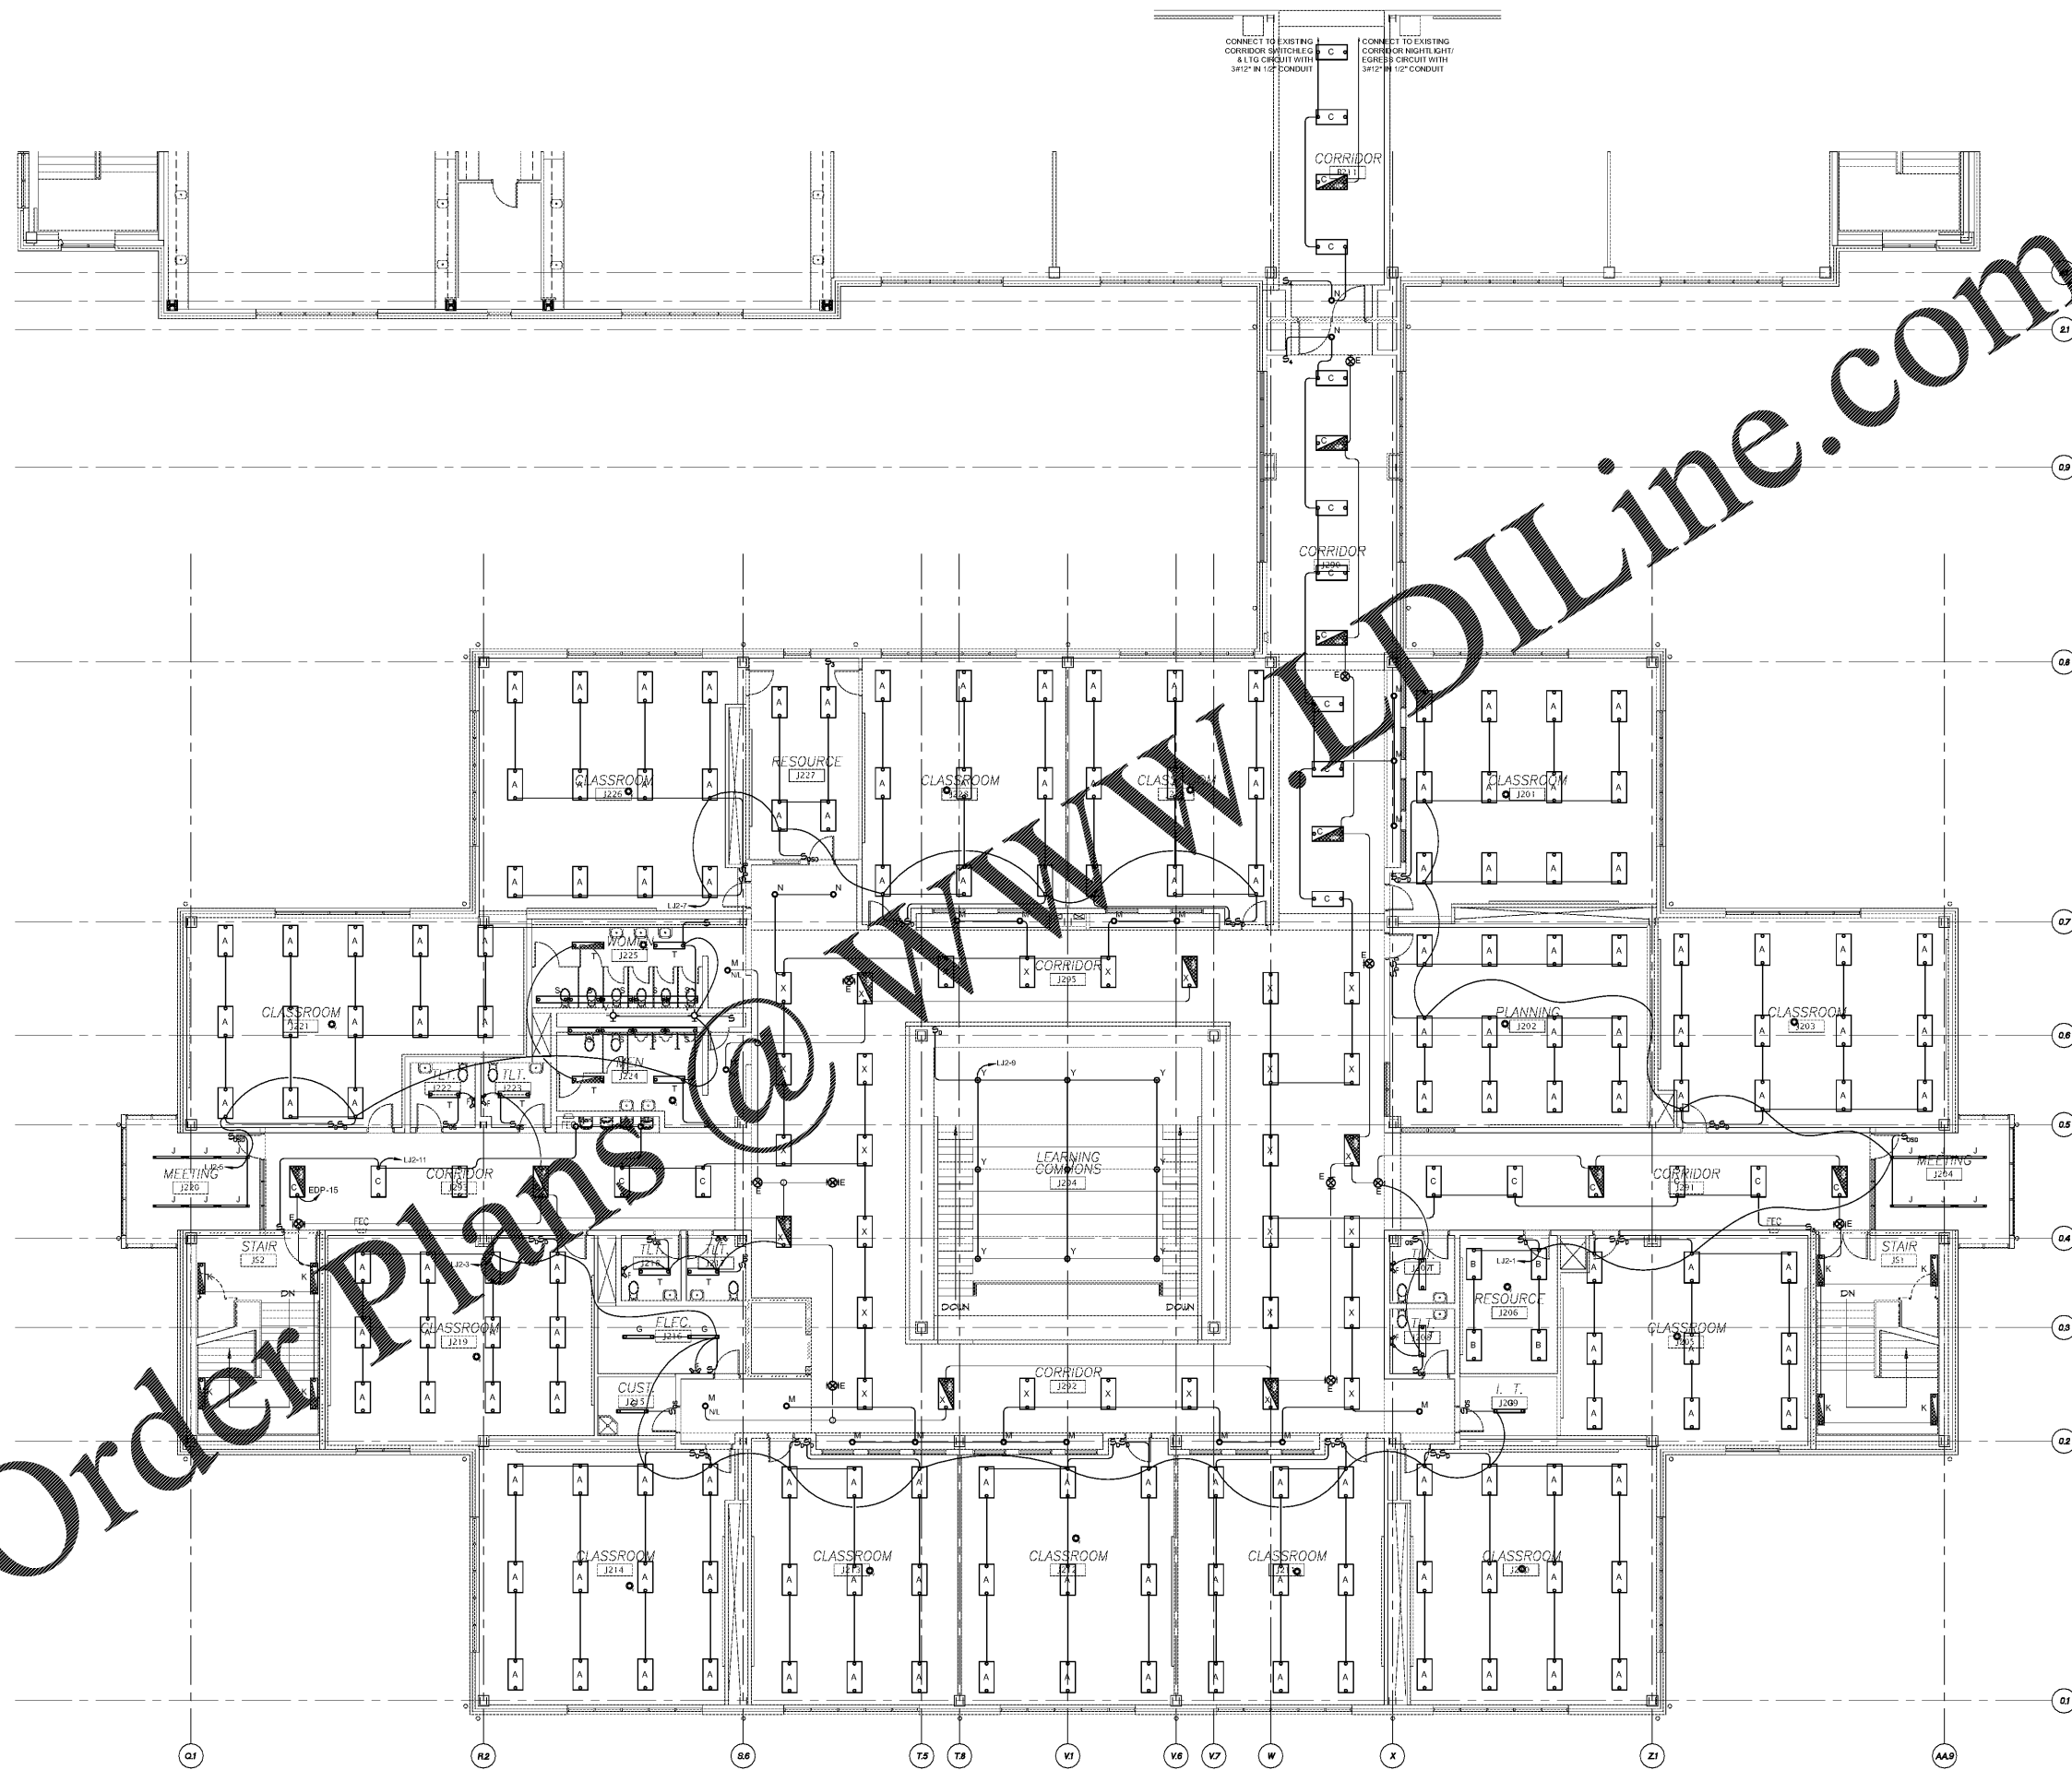

Order Plans @ www.DILine.com

Second Floor Electrical Lighting Plan
 Scale: 1/8" = 1'-0"


THIS DRAWING IS NOT TO BE SCALED FOR CONSTRUCTION PURPOSES. THE SCALE WHEN INDICATED IS FOR GENERAL REFERENCE ONLY.

cra
 222 cloister court
 chapel hill, nc 27514
 919.401.8586
 www.cra-ae.com

ARM & M
ENGINEERS
 Reece, Noland & McElrath, Inc.
 94 Main Street
 Canton, North Carolina 28716
 PHONE: 919.401.8586 FAX: 919.401.8587
 WWW: www.armm.com



Cedar Ridge High School
 Classroom Addition
 Orange County Schools
 1125 New Grady Brown School Road
 Hillsborough, North Carolina

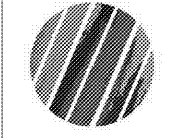

no.	revisions

The use of these plans and specifications shall be restricted to the project for which they were prepared and shall not be used for any other project without the written consent of the architect, engineer, or contractor. The contractor shall be responsible for obtaining all necessary permits and for the installation of these fixtures.

drawn	checked
RWC	JSD
Second Floor Electrical Lighting Plan	
sheet	

E3.1

project no. 1716

date 4/25/19