


THIS DRAWING IS NOT TO BE SCALED FOR CONSTRUCTION PURPOSES. THE SCALE WHEN INDICATED IS FOR GENERAL REFERENCE ONLY.


GRAPHIC SCALE 1/4"=1'-0"
GRAPHIC SCALE 1/8"=1'-0"
GRAPHIC SCALE 1/16"=1'-0"

Order Plans @

WWW.LDILine.com

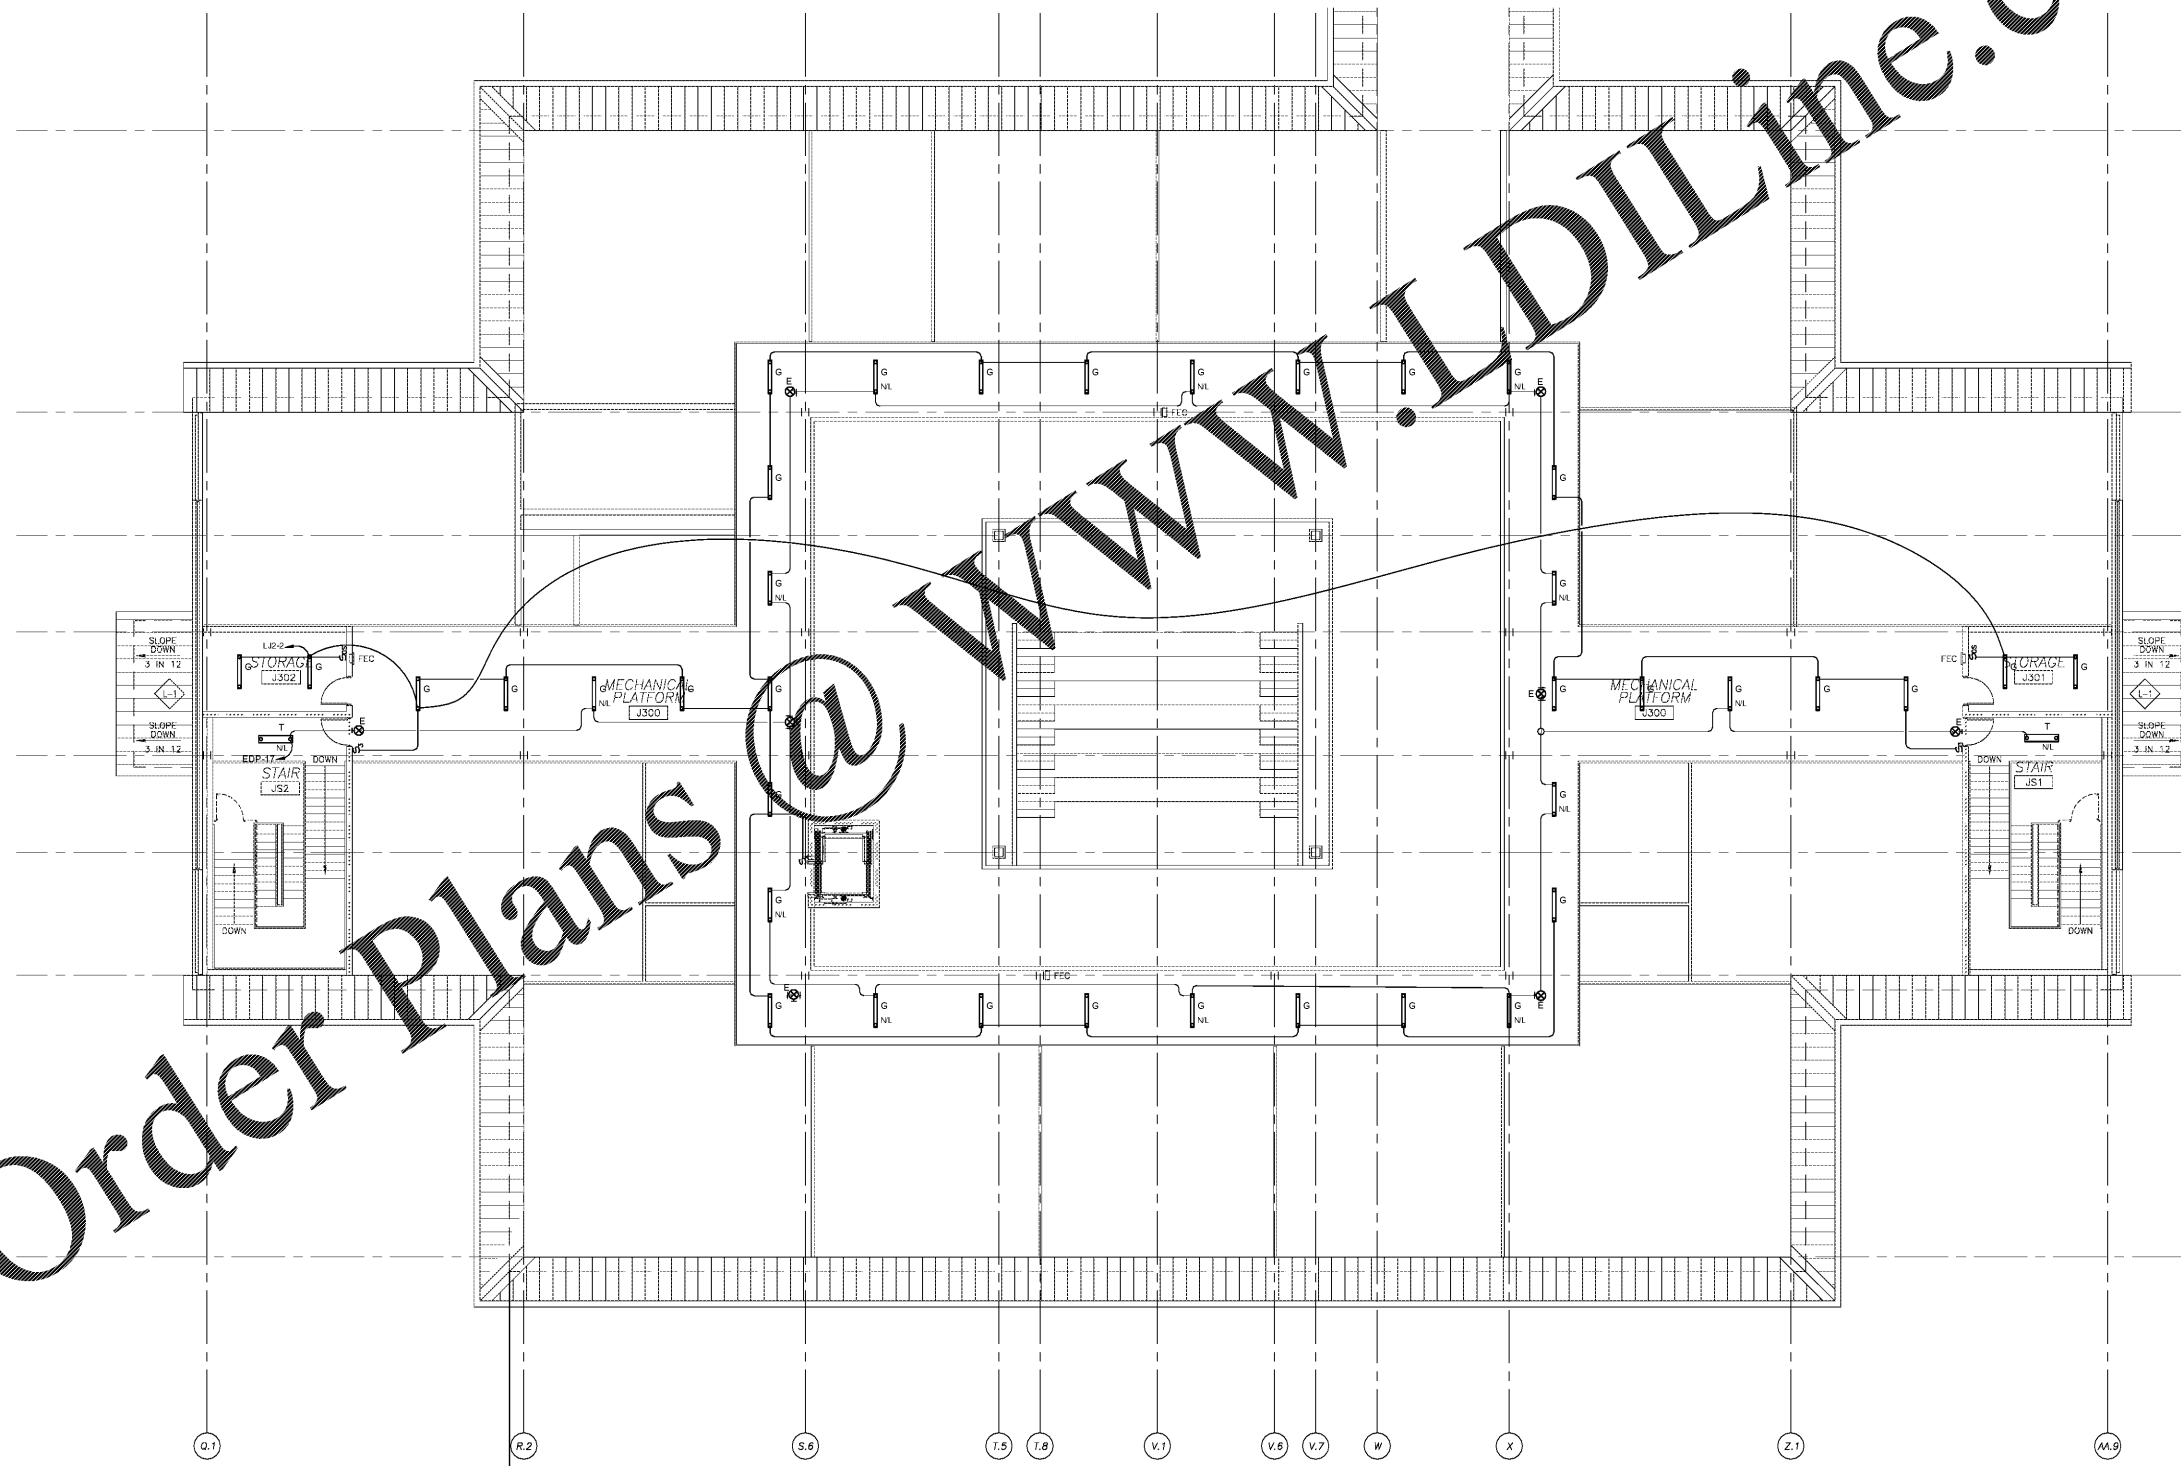


Mechanical Mezzanine Electrical Lighting Plan
Scale: 1/8" = 1'-0"

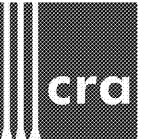

222 cloister court
chapel hill, nc 27514
919.401.8586
www.cra-ae.com



Cedar Ridge High School
Classroom Addition
Orange County Schools
1125 New Grady Brown School Road
Hillsborough, North Carolina

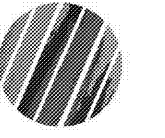

no.	revisions
0.1	

The use of these plans and specifications shall be restricted to the project for which they were prepared and shall not be used for any other project without the written approval of the architect. The use of these plans and specifications shall be restricted to the project for which they were prepared and shall not be used for any other project without the written approval of the architect.

drawn	checked
JWC	JSD
Mechanical Mezz. Electrical Lighting Plan	

sheet
E4.1

project no. 1716

date 4/25/19