


GRAPHIC SCALE 1/4"=1'-0"
 GRAPHIC SCALE 1/8"=1'-0"
 GRAPHIC SCALE 1/16"=1'-0"


THIS DRAWING IS NOT TO BE SCALED FOR CONSTRUCTION PURPOSES. THE SCALE WHEN INDICATED IS FOR GENERAL REFERENCE ONLY.

Order Plans @

WWW.DIYline.com

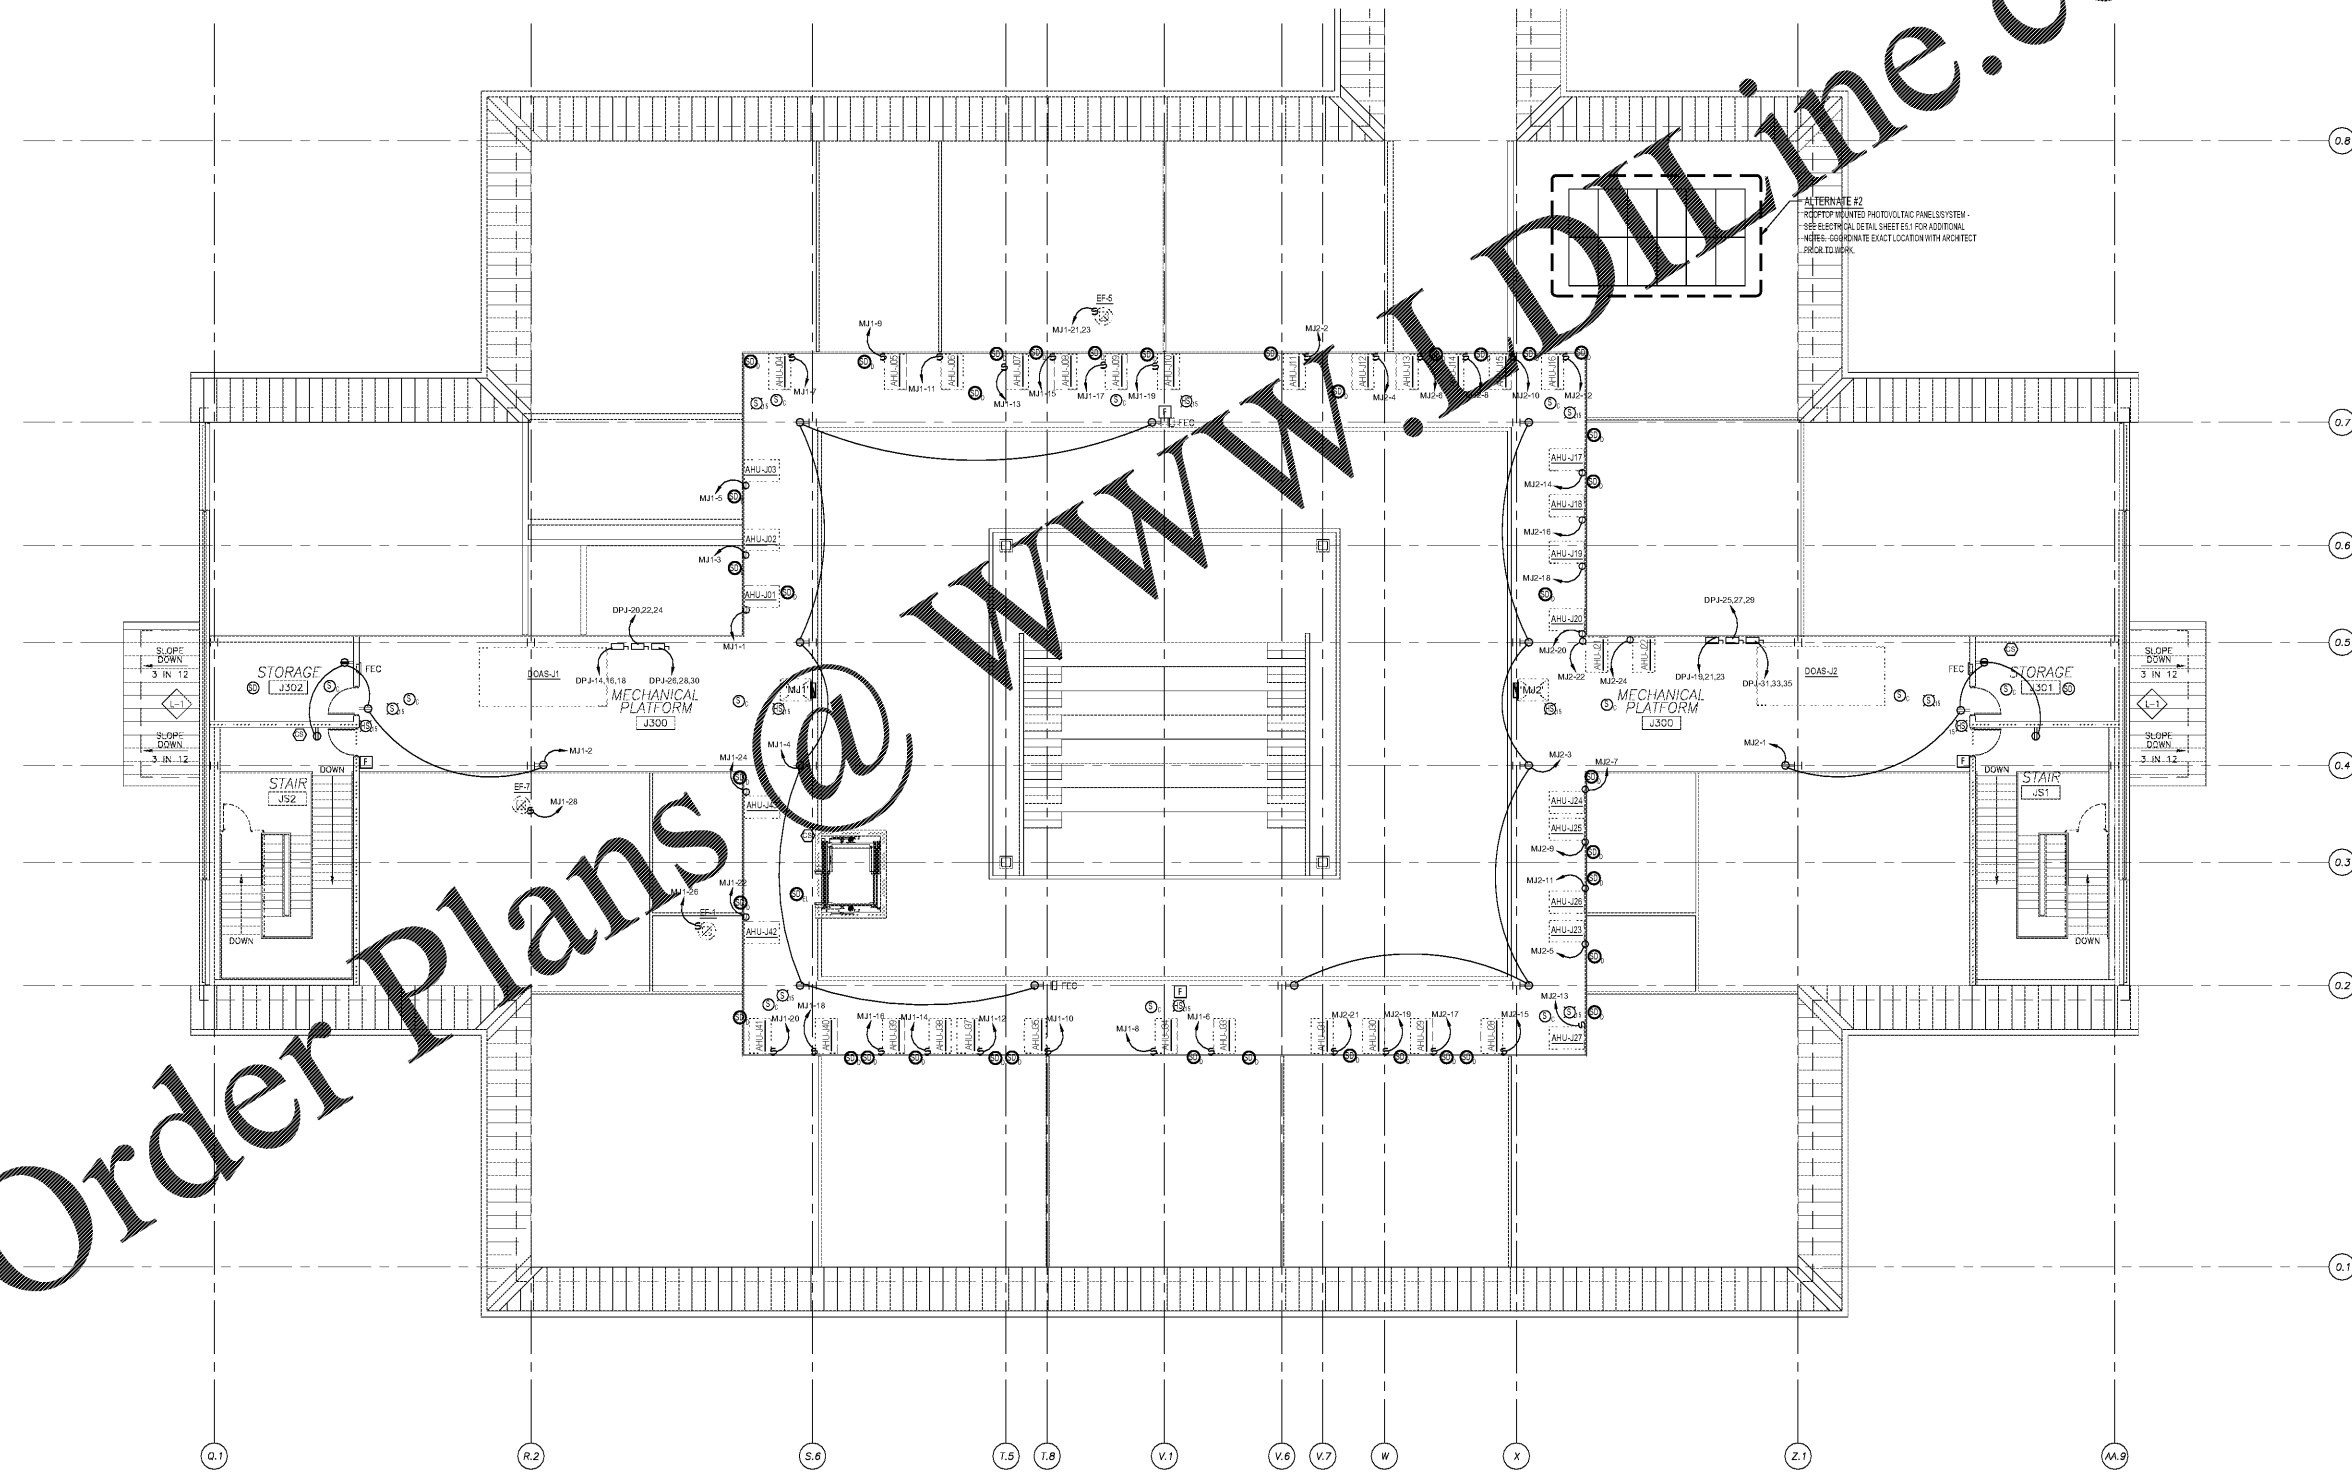


ALTERNATE #2
 SEE ELECTRICAL SHEET FOR ADDITIONAL
 NOTES: COORDINATE EXACT LOCATION WITH ARCHITECT
 PRIOR TO WORK.

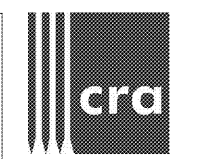

222 cloister court
 chapel hill, nc 27514
 919.401.8586
 www.cra-ae.com



Cedar Ridge High School
 Classroom Addition
 Orange County Schools
 1125 New Grady Brown School Road
 Hillsborough, North Carolina

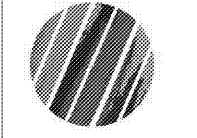

no.	revisions

The use of these plans and specifications shall be restricted to the project for which they were prepared and shall not be used for any other project without the written consent of the engineer. The engineer shall not be responsible for any errors or omissions in these plans and specifications, nor for any consequences resulting from their use. The contractor shall verify all dimensions and conditions of the site prior to construction.

drawn	checked
FWC	JSD

Mechanical Mezz.
 Elec. Power & Rept.
 Fire Alarm Plan

sheet
E4.2

project no. 1716
 date 4/25/19

Mechanical Mezzanine Electrical Power, Receptacle & Fire Alarm Plan
 Scale: 1/8" = 1'-0"