

COPYRIGHT NOTICE:
This drawing is the property of the above
mentioned Professional and it will be used
for any purpose other than the specific
project and site named herein, and cannot
be reproduced in any manner without the
express written permission from the Professional.

ISSUE/REVISION RECORD	
DATE	DESCRIPTION
07/26/19	COORDINATION SET
02/20/19	HEALTH SUBMITTAL
04/24/19	HEALTH RESPONSE
05/03/19	PERMIT/BD SET

PROFESSIONAL SEAL

PROFESSIONAL IN CHARGE
S. KOUGHS
PROJECT MANAGER
E. ARELLANO
QUALITY CONTROL
S. KOUGHS
DRAWN BY
E. ARELLANO

PROJECT NAME
BUBBA'S 33


**GASTONIA
NORTH CAROLINA**
3287 E. FRANKLIN BLVD.



PROJECT NUMBER
20181046.0

SHEET TITLE
**REFLECTED
CEILING
FRAMING PLAN**

SHEET NUMBER
A11.1

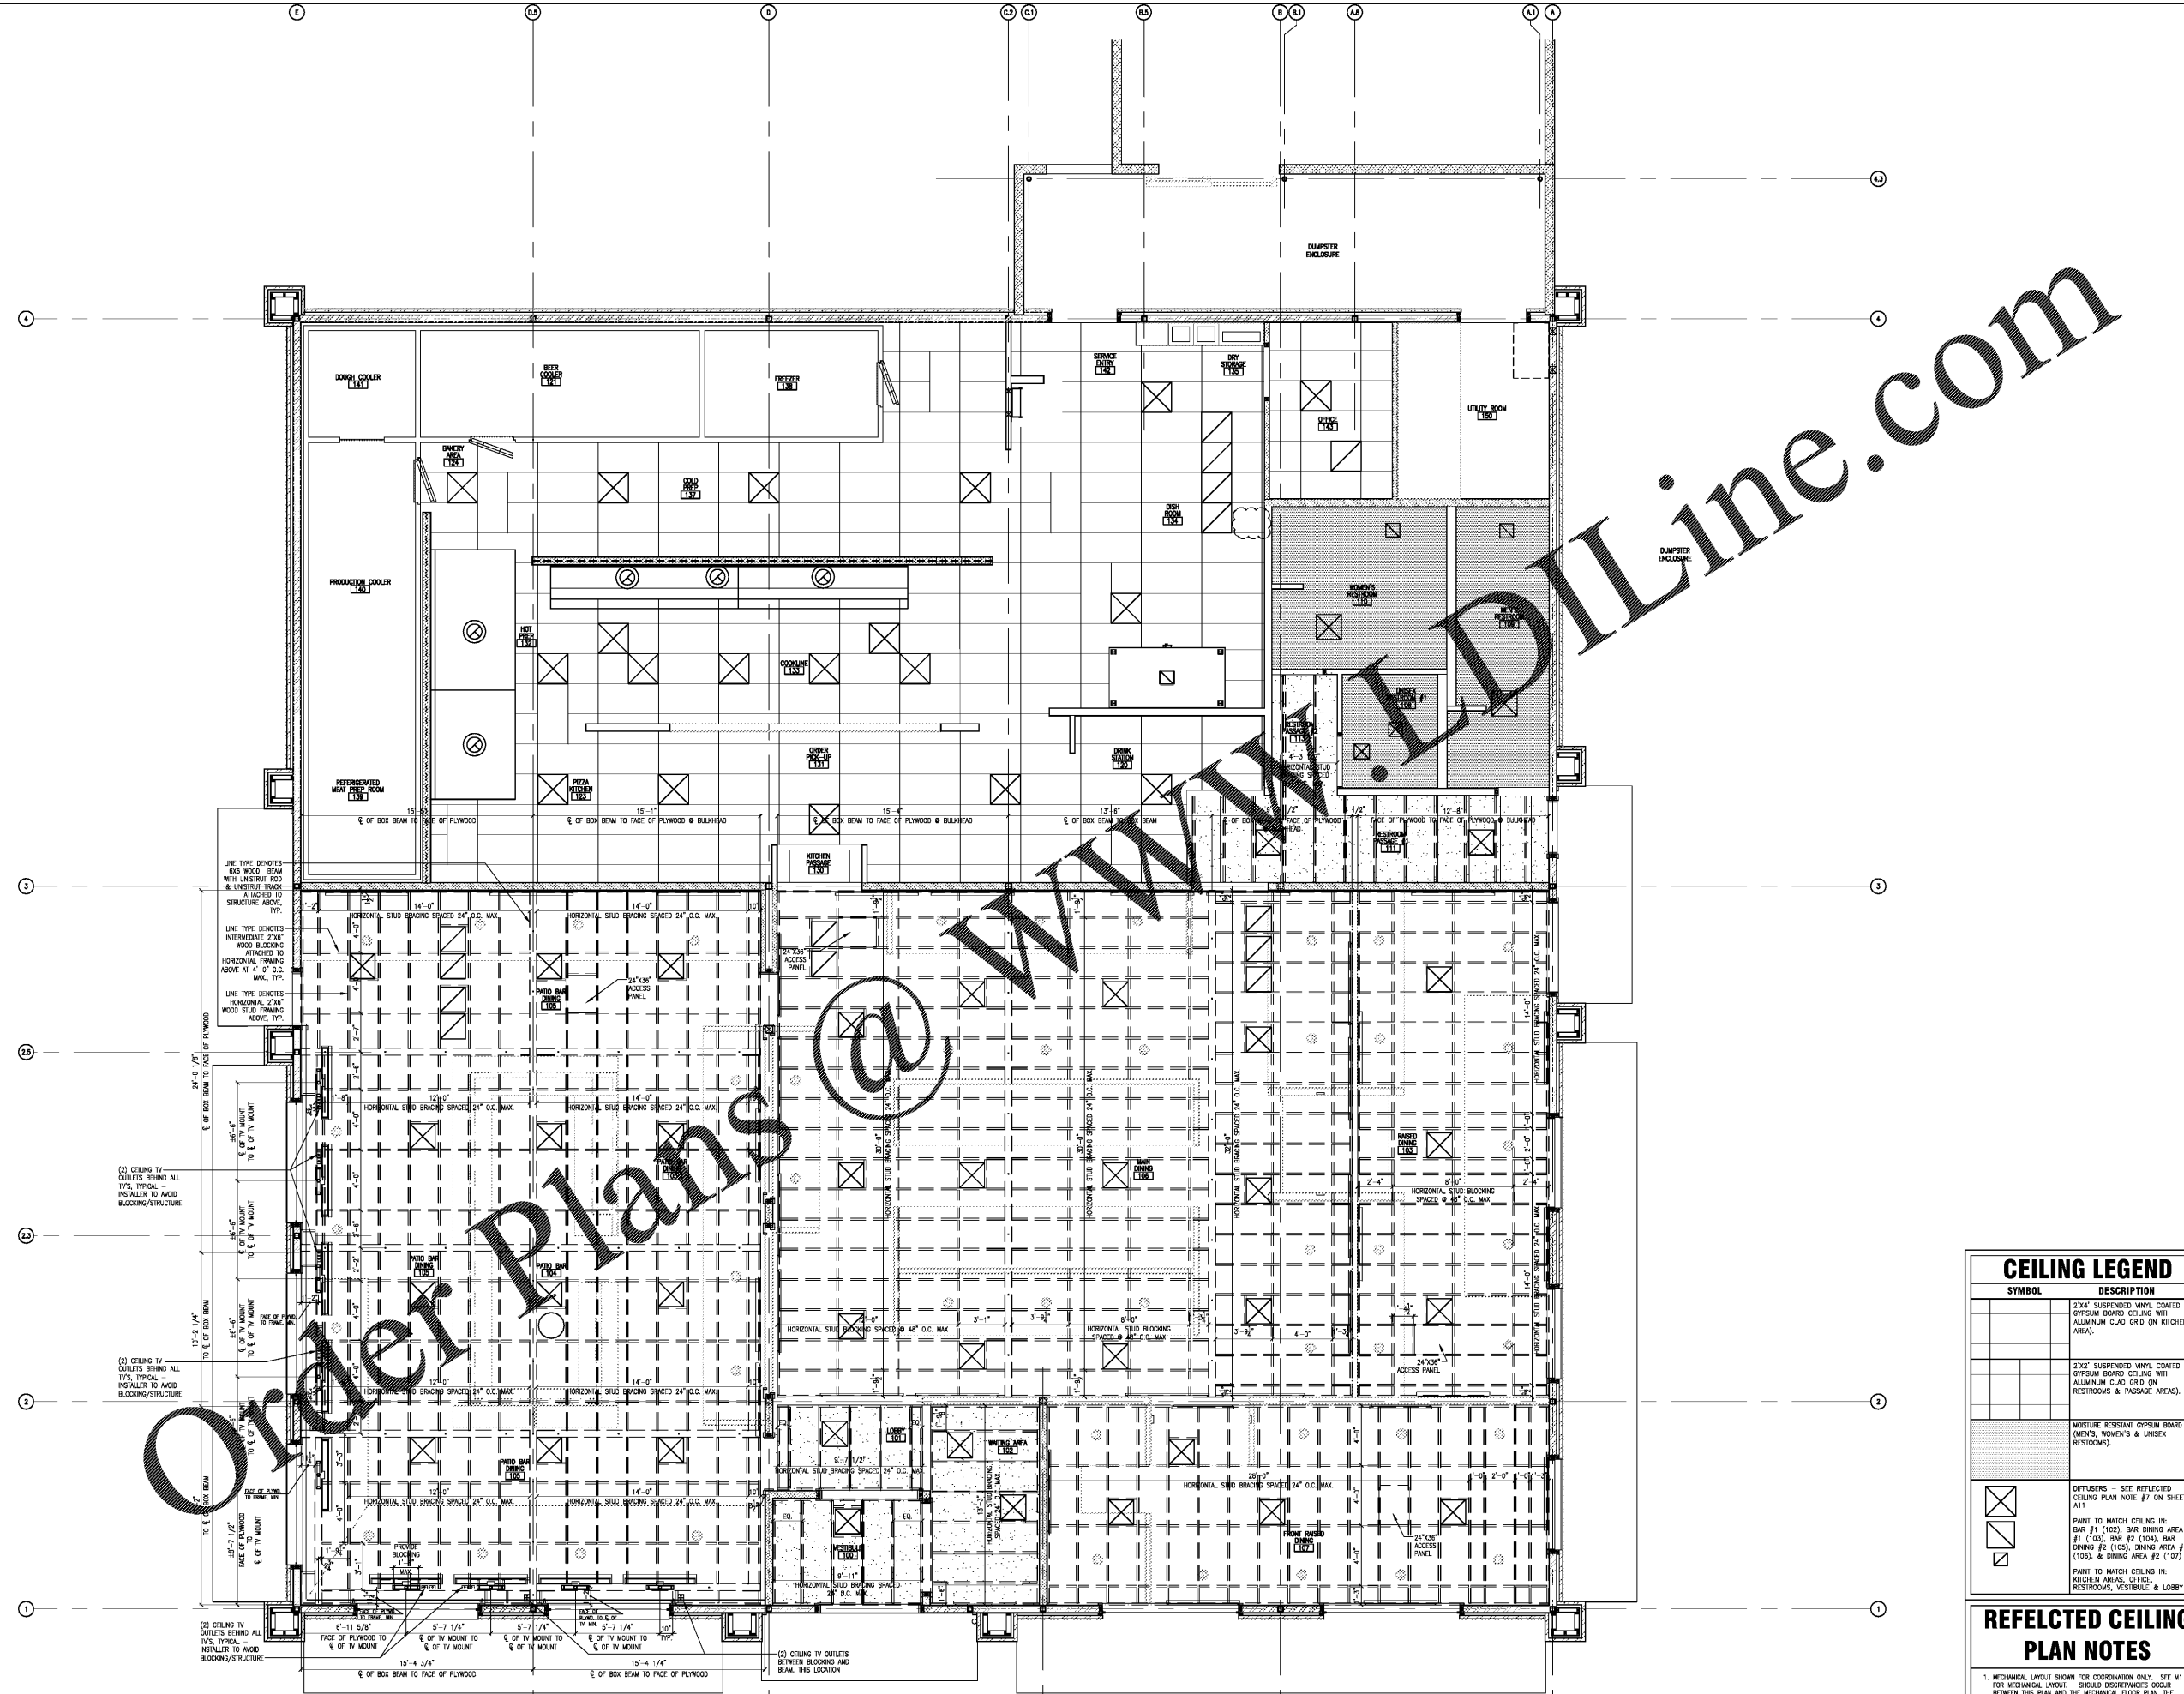

CEILING LEGEND	
SYMBOL	DESCRIPTION
[Symbol]	2'x4' SUSPENDED VINYL COATED GYPSUM BOARD CEILING WITH ALUMINUM CLAD GRID (IN KITCHEN AREA).
[Symbol]	2'x2' SUSPENDED VINYL COATED GYPSUM BOARD CEILING WITH ALUMINUM CLAD GRID (IN RESTROOMS & PASSAGE AREAS).
[Symbol]	MOISTURE RESISTANT GYPSUM BOARD (MEN'S, WOMEN'S & UNISEX RESTROOMS).
[Symbol]	DIFFUSERS - SET, REFLECTED CEILING PLAN NOTE #7 ON SHEET A11.
[Symbol]	PAINT TO MATCH CEILING IN: BAR #1 (102), BAR DINING AREA #1 (103), BAR #2 (104), BAR DINING #2 (105), DINING AREA #1 (106), & DINING AREA #2 (107).
[Symbol]	PAINT TO MATCH CEILING IN: KITCHEN AREAS, OFFICE, RESTROOMS, VESTIBULE & LOBBY.

- REFLECTED CEILING PLAN NOTES**
- MECHANICAL LAYOUT SHOWN FOR COORDINATION ONLY. SEE M1 FOR MECHANICAL LAYOUT. SHOULD DISCREPANCIES OCCUR BETWEEN THIS PLAN AND THE MECHANICAL FLOOR PLAN, THE MECHANICAL PLAN SHALL TAKE PRECEDENCE.
 - ALL DIFFUSERS TO MATCH ADJACENT MATERIAL IN COLOR.
 - FRAMING GRID TO AVOID LOCATION OF FA FIXTURES CENTERED ABOVE TABLE.

1 REFLECTED FRAMING CEILING PLAN
A11.1 SCALE: 1/4" = 1'-0" NORTH