


COPYRIGHT NOTICE  
This drawing is the property of the above referenced Professional and is not to be used for any purpose other than the specific project and site named herein, and cannot be reproduced in any manner without the express written permission from the Professional.

DATE	DESCRIPTION
01/29/19	COORDINATION SET
02/25/19	HEALTH SUBMITTAL
04/24/19	HEALTH RESPONSE
05/03/19	PERMIT/BD SET

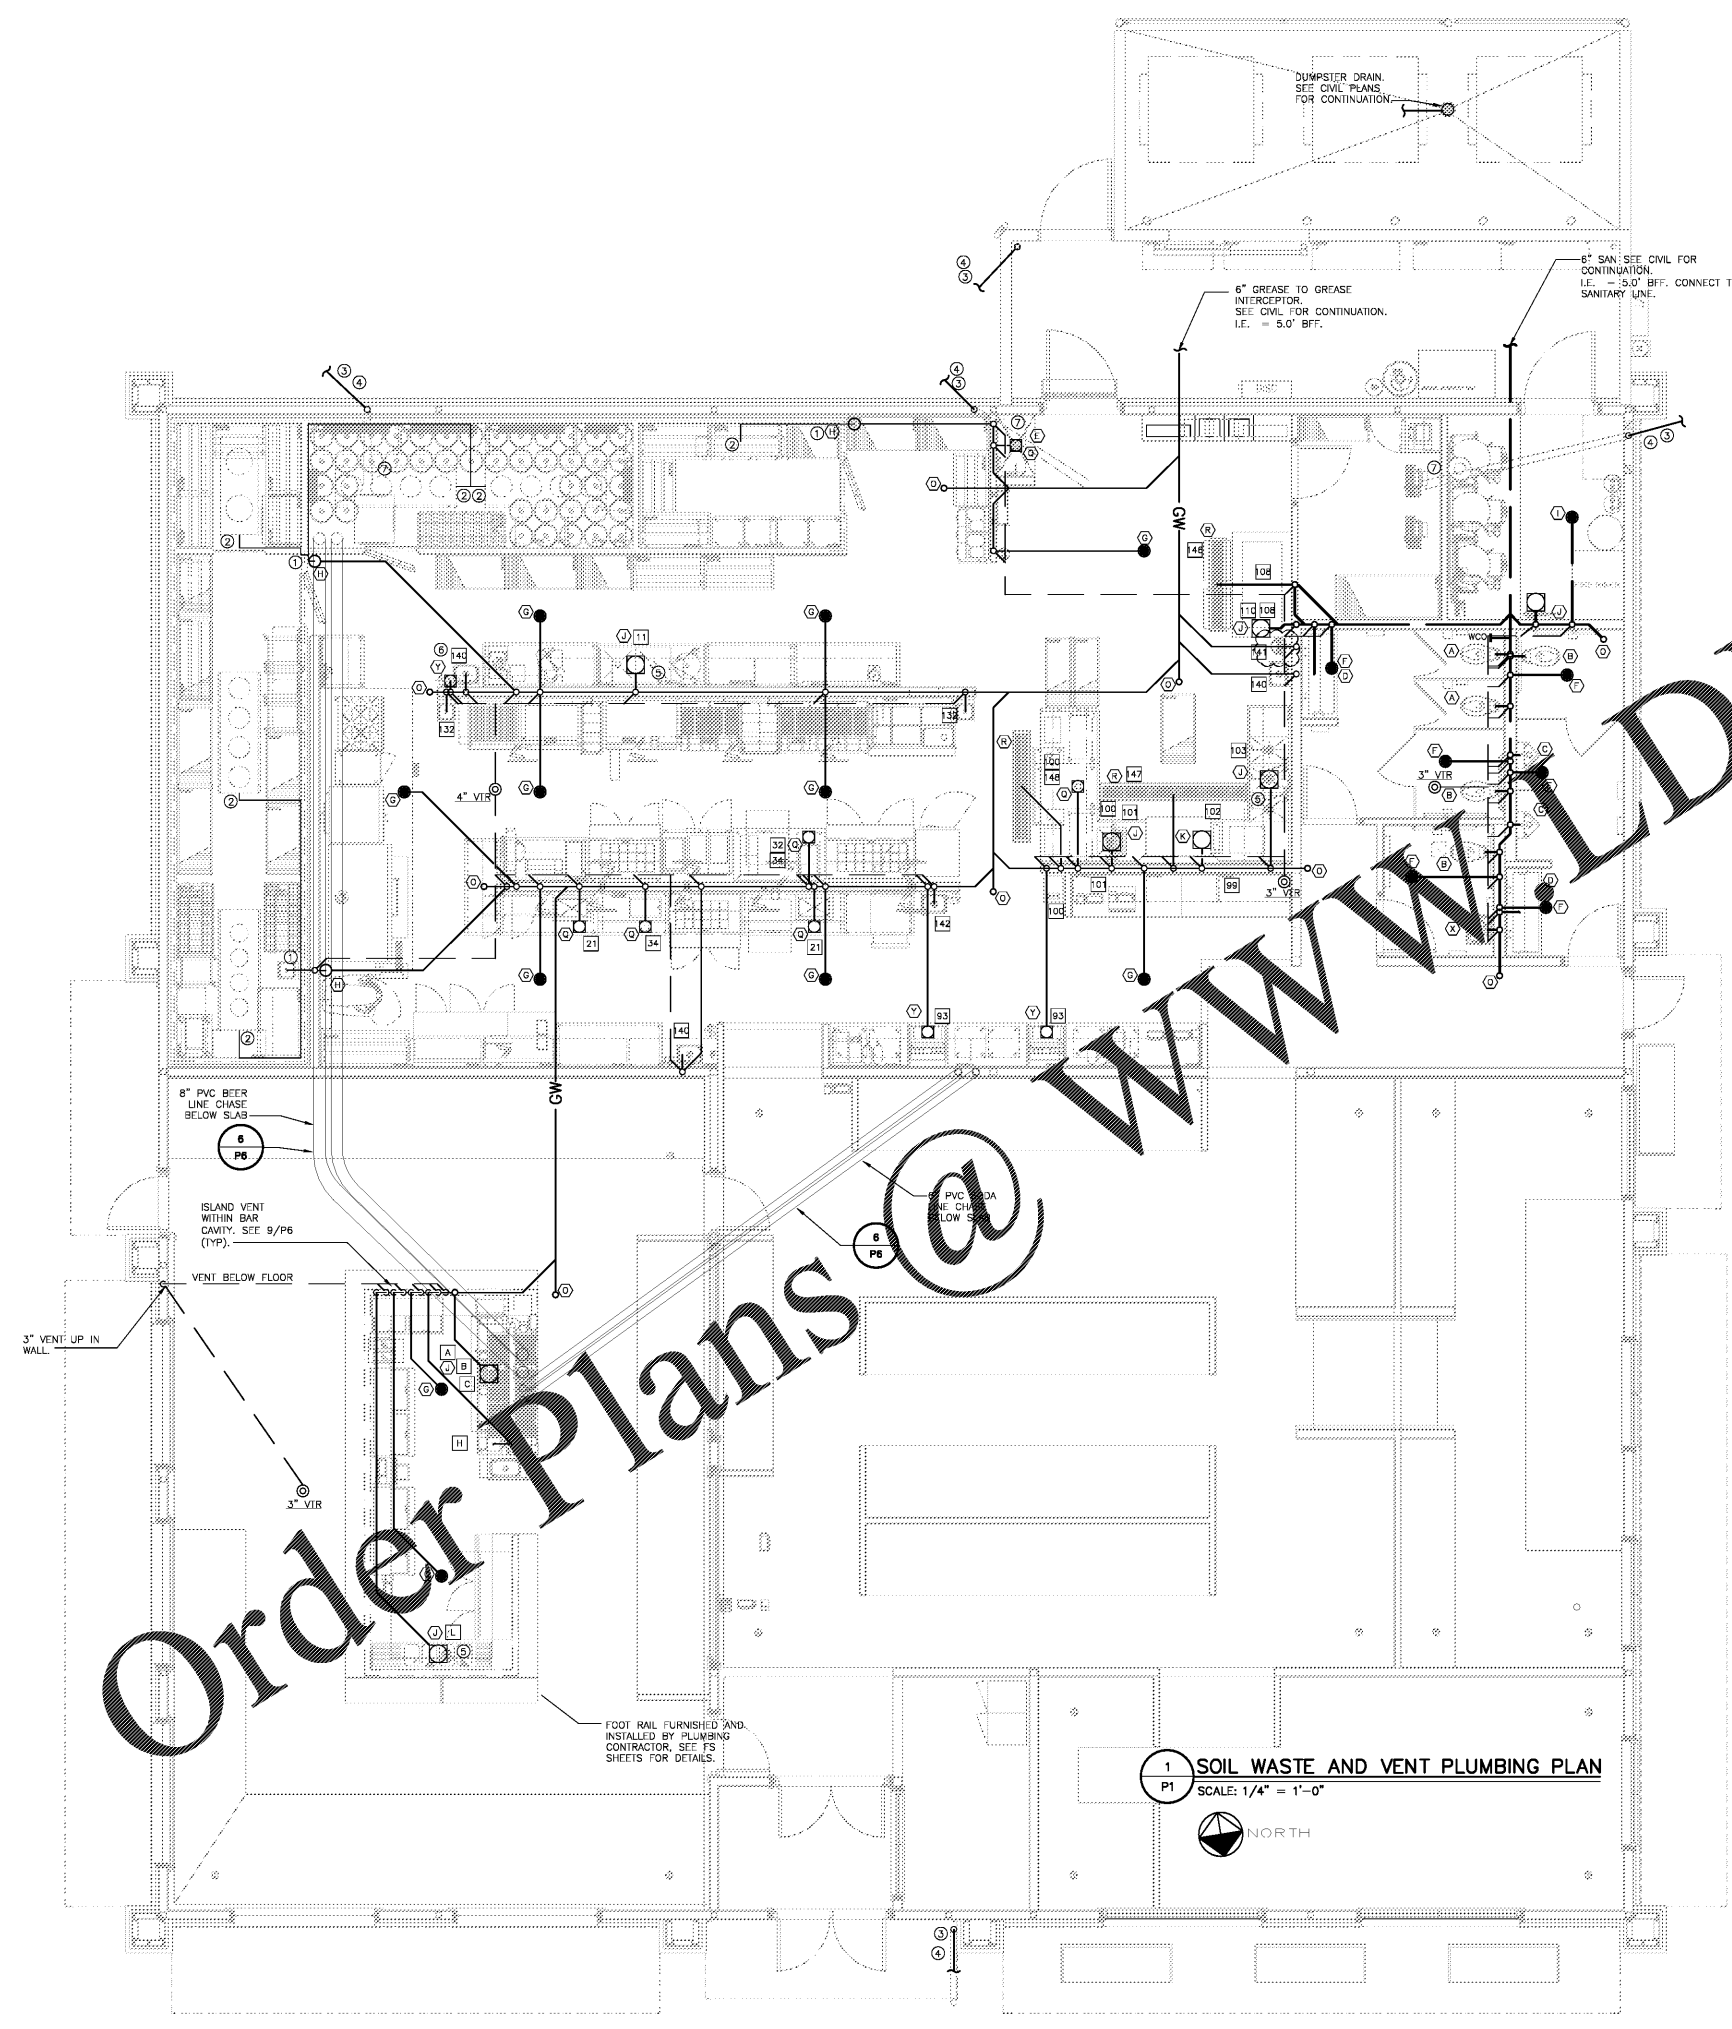

**KEYED NOTES**

- 1 SLEEVE AND SEAL THROUGH COOLER/ FREEZER WALL, TURN DOWN ABOVE DRAIN W/REQUIRED AIR GAP (TYP.)
  - 2 1" COPPER, TRAPPED CONDENSATE PIPING FROM EVAPORATIVE COILS IN COOLERS/FREEZER (TYP.) WRAP WITH INSULATED, SELF-LIMITING HEAT TRACE TAPE IN FREEZER (10W/LIN. FT.)
  - 3 4" STORM DRAIN FROM ROOF. PROVIDE CLEANOUT IN STORM RISER AS REQUIRED BY CODE.
  - 4 DISCHARGE BELOW GRADE. SEE CIVIL PLANS FOR CONTINUATION.
  - 5 DRAIN EACH COMPARTMENT INDEPENDENTLY TO FLOOR SINK. PROVIDE AIR GAP IF NO LESS THAN 6"
  - 6 PLUMBER CONTRACTOR TO INSTALL 1" COPPER DRAIN LINE CONNECTING GREASE DRAINS ON HOOD ACCEPTABLE ON KITCHEN FLOOR BESIDE STOVE, HOOD, REFER TO LCS.
- NOTE: DISCHARGE PIPING FROM A "K"/"Q" FLOOR SINK FROM DISHWASHER, TILT SKILLET, OR STEAM TABLE SHALL BE CAST IRON 10'-0" (MIN.) DOWNSTREAM OF THE DRAIN.

**PLUMBING FIXTURE ROUGH-IN SCHEDULE**

MARK	ITEM	QTY.	CONN. SIZE SCH.	CONN. SIZE IHW	WASTE
1	WATER CLOSET	2	1"	-	4" DIRECT
2	WATER CLOSET (HANDICAP)	3	1"	-	4" DIRECT
3	URNAL	2	3/4"	-	4" DIRECT
4	LAUNDRY (ROUGH SINK)	2	1/2"	1/2"	1-1/2" DIRECT
5	MOP BASIN DRAIN	1	-	-	3" DIRECT
6	FLOOR DRAIN (RESTROOM)	6	-	-	3" DIRECT
7	FLOOR DRAIN (KITCHEN)	10	-	-	4" DIRECT
8	FLOOR DRAIN (FUNNEL)	3	-	-	4" DIRECT
9	FLOOR DRAIN (UTILITY)	1	-	-	4" DIRECT
10	FLOOR SINK (GENERAL)	10	-	-	4" DIRECT
11	FLOOR SINK (DISHWASHER/KETTLE)	4	-	-	4" DIRECT
12	SERVICE FAUCET	1	1/2"	1/2"	-
13	WALL HYDRANT	2	1/2"	1/2"	-
14	ITEM TO BE FURNISHED	1	-	-	ITEM TO BE FURNISHED BY OWNER OR SUPPLIER
15	CLEANOUT	11	-	-	-
16	FLOOR SINK	8	-	-	4" DIRECT
17	FLOOR TROUGH	4	-	-	4" DIRECT
18	THERMOSTATIC MIXING VALVE	14	3/4"	3/4"	-
19	LAUNDRY (WALL MOUNTED)	1	1/2"	1/2"	1-1/2" DIRECT
20	ROOF HYDRANT	1	3/4"	-	-
21	COOLER/FREEZER	5	-	-	1-1/2" INDIRECT TO FLOOR SINK/FLOOR DRAIN
22	S/S PREP SINK	1	1/2"	1/2"	INDIRECT TO FLOOR SINK/FLOOR DRAIN
23	24" GAS GRIDDLE	1	-	-	-
24	CHARBROILER	1	-	-	-
25	DROP IN ICED COLD WELL	1	-	-	INDIRECT TO FLOOR SINK/FLOOR DRAIN
26	18" DEEP FRYER	5	-	-	-
27	CHEF'S/STEAM TABLE	1	-	-	1-1/2" INDIRECT TO FLOOR SINK
28	DROP IN HOT WELL	1	-	-	1/2" INDIRECT TO FLOOR SINK
29	CONVECTION OVEN	1	-	-	-
30	8 BURNER RANGE	1	-	-	-
31	WATER FILTER ASSEMBLY	1	1/2"	-	-
32	POT FILLER FAUCET	1	-	1/2" (1107)	-
33	PIZZA OVEN	2	-	-	-
34	ICED TEA BREWER	1	1/2" (7)	-	-
35	COFFEE BREWER	1	1/2" (7)	-	-
36	SODA DISPENSER	1	-	-	INDIRECT TO FLOOR SINK
37	BOOSTER HEATER	1	-	3/4"	-
38	DRY DISH TABLE	1	-	1/2" (1107)	INDIRECT TO FLOOR SINK
39	PRE-RINSE SPRAY ASSEMBLY	1	1/2"	1/2"	INDIRECT TO FLOOR SINK
40	DISH MACHINE	1	-	3/4" (1807)	INDIRECT TO FLOOR SINK
41	CLEAN DISH RAMP/3 COMP SINK	1	1/2"	1/2"	INDIRECT TO FLOOR SINK
42	ICE MACHINE HEAD UNIT	1	1/2" (5)	-	INDIRECT TO FLOOR SINK
43	ICE BIN	1	-	3/4"	INDIRECT TO FLOOR SINK/TROUGH
44	WATER FILTRATION SYSTEM	1	-	3/4"	-
45	CARBONATOR/PUMP DECK	1	1/2" (7)	-	-
46	SINKLINE HANDSINK	1	1/2"	1/2"	1-1/2" IPS
47	HAND SINK	5	1/2"	1/2"	1-1/2" IPS
48	EYE WASH ATTACHMENT	1	-	-	-
49	KNEE PEDAL HAND SINK	1	1/2"	1/2"	1-1/2" IPS
50	5' FLOOR TROUGH	1	-	-	4" OD
51	6' FLOOR TROUGH	1	-	-	4" OD
52	6' FLOOR TROUGH	1	-	-	4" OD
53	HOT PREP EXHAUST HOOD	1	-	-	-
54	COOKLINE EXHAUST HOOD	1	-	-	-
55	DISHWASHING EXHAUST HOOD	1	-	-	-
56	24" DRAB BOARD	1	-	-	INDIRECT TO FLOOR SINK
57	36" ICE BIN	1	-	-	INDIRECT TO FLOOR SINK
58	S/S SERVICE BAR	1	-	-	INDIRECT TO FLOOR SINK
59	BAR HAND SINK	1	1/2"	1/2"	1-1/2" IPS
60	4 COMPARTMENT BAR SINK	1	1/2"	1/2"	INDIRECT TO FLOOR SINK

Order Plans @ [www.welding.com](http://www.welding.com)

**1 SOIL WASTE AND VENT PLUMBING PLAN**  
SCALE: 1/4" = 1'-0"



PROFESSIONAL SEAL

PROFESSIONAL IN CHARGE  
R. SMITH  
PROJECT MANAGER  
A. HAGLOW  
QUALITY CONTROL  
A. HAGLOW  
DRAWN BY  
Y. YANG

PROJECT NAME  
**BUBBA'S 33**

**GASTONIA**  
**NORTH CAROLINA**

3287 E. FRANKLIN BLVD.



PROJECT NUMBER  
20181046.0

SHEET TITLE  
**SOIL WASTE AND VENT PLUMBING PLAN**

SHEET NUMBER

**P1**