


COPYRIGHT NOTICE:  
This drawing is the property of the above  
mentioned Professional and is not to be used  
for any purpose other than the specific  
project and site named herein, and cannot  
be reproduced in any manner without the  
express written permission from the Professional.

ISSUE/REVISION RECORD	
DATE	DESCRIPTION
07/29/19	COORDINATION SET
02/20/19	HEALTH SUBMITTAL
04/24/19	HEALTH RESPONSE
05/03/19	PERMIT/BD SET

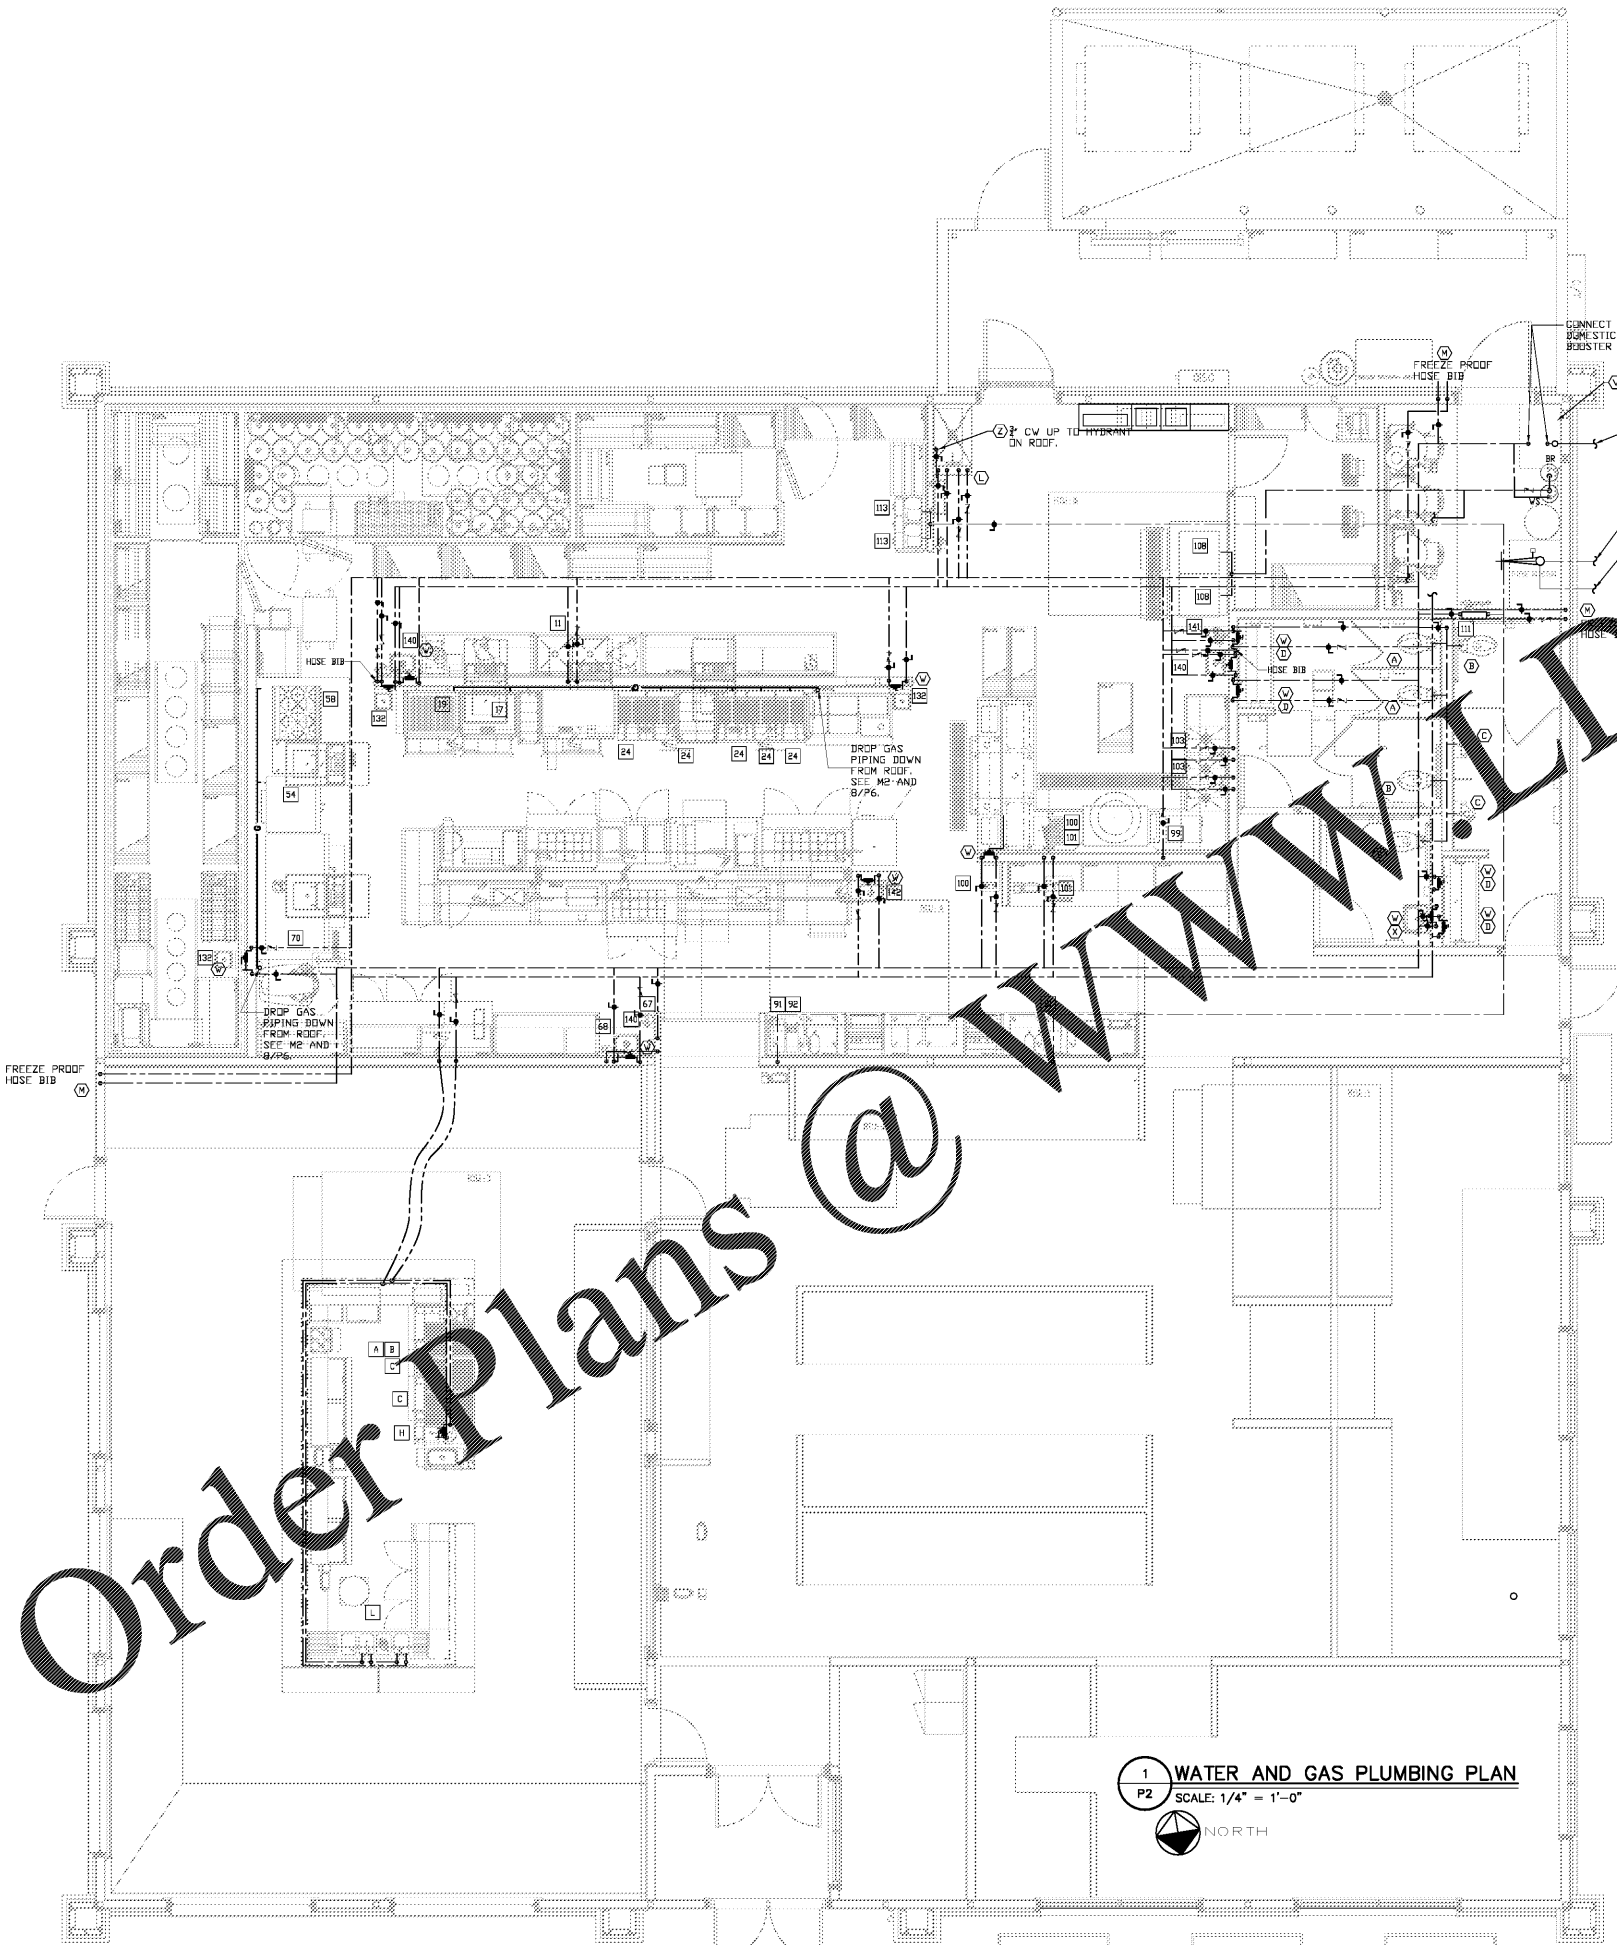

WWW.DILine.com

Order Plans @

**PLUMBING FIXTURE ROUGH-IN SCHEDULE**

MARK	ITEM	QTY.	CONN. SIZE	CONN. SIZE	WASTE
			DN	UP	
WC	WATER CLOSET	2	1"	-	4" DIRECT
WC	WATER CLOSET (HANDCAP)	3	1"	-	4" DIRECT
UR	URINAL	2	3/4"	-	4" DIRECT
LAV	LAVATORY (TROUGH SINK)	2	1/2"	1/2"	1-1/2" DIRECT
MOP	MOP BASIN DRAIN	1	-	-	3" DIRECT
FDR	FLOOR DRAIN (RESTROOM)	6	-	-	3" DIRECT
FDR	FLOOR DRAIN (KITCHEN)	10	-	-	4" DIRECT
FDR	FLOOR DRAIN (FUNNEL)	3	-	-	4" DIRECT
FDR	FLOOR DRAIN (UTILITY)	1	-	-	4" DIRECT
FDR	FLOOR SINK (GENERAL)	10	-	-	4" DIRECT
FDR	FLOOR SINK (DISHWASHER/KETTLE)	4	-	-	4" DIRECT
SF	SERVICE FAUCET	1	1/2"	1/2"	-
WH	WALL HYDRANT	2	1/2"	1/2"	-
IF	ITEM TO BE FURNISHED BY OWNER OR SUPPLIER	1	-	-	-
CL	CLEANOUT	11	-	-	-
FDR	FLOOR SINK	8	-	-	4" DIRECT
FDR	FLOOR TROUGH	4	-	-	4" DIRECT
TMV	THERMOSTATIC MIXING VALVE	14	3/4"	3/4"	-
LAV	LAVATORY (WALL MOUNTED)	1	1/2"	1/2"	1-1/2" DIRECT
RH	ROOF HYDRANT	1	3/4"	-	-
CF	COOLER/FREEZER	5	-	-	1-1/2" INDIRECT TO FLOOR SINK/FLOOR DRAIN
S/S	S/S PREP SINK	1	1/2"	1/2"	INDIRECT TO FLOOR SINK/FLOOR DRAIN
GR	24" GAS GRIDDLE	1	-	-	-
CR	CHARBROILER	1	-	-	-
ICW	DROP IN ICED COLD WELL	1	-	-	INDIRECT TO FLOOR SINK/FLOOR DRAIN
DF	18" DEEP FRYER	5	-	-	-
ST	CHIEF'S/STEAM TABLE	1	-	-	1-1/2" INDIRECT TO FLOOR SINK
HW	DROP IN HOT WELL	1	-	-	1/2" INDIRECT TO FLOOR SINK
CO	CONVECTION OVEN	1	-	-	-
BS	6 BURNER RANGE	1	-	-	-
WA	WATER FILTER ASSEMBLY	1	1/2"	-	-
PF	POT FILLER FAUCET	1	-	1/2" (110)	-
PO	PIZZA OVEN	2	-	-	-
ITB	ICED TEA BREWER	1	1/2" (7)	-	-
CB	COFFEE BREWER	1	1/2" (7)	-	-
SD	SODA DISPENSER	1	-	-	INDIRECT TO FLOOR SINK
BH	BOOSTER HEATER	1	-	3/4"	-
DT	DIRTY DISH TABLE	1	-	1/2" (110)	INDIRECT TO FLOOR SINK
RS	PRE-RINSE SPRAY ASSEMBLY	1	1/2"	1/2"	INDIRECT TO FLOOR SINK
DM	DISH MACHINE	1	-	3/4" (180)	INDIRECT TO FLOOR SINK
CR	CLEAN DISH RAMP/3 COMP SINK	1	1/2"	1/2"	INDIRECT TO FLOOR SINK
IC	ICE MACHINE HEAD UNIT	1	1/2" (S)	-	INDIRECT TO FLOOR SINK
IB	ICE BIN	1	-	-	INDIRECT TO FLOOR SINK/TROUGH
WF	WATER FILTRATION SYSTEM	1	3/4"	-	-
CP	CARBONATOR/PUMP DECK	1	1/2" (7)	-	-
HS	SUMLINE HANDSINK	1	1/2"	1/2"	1-1/2" IPS
HS	HAND SINK	5	1/2"	1/2"	1-1/2" IPS
EA	EYE WASH ATTACHMENT	1	-	-	-
KH	KNEE PEDAL HAND SINK	1	1/2"	1/2"	1-1/2" IPS
FT	5' FLOOR TROUGH	1	-	-	4" OD
FT	8' FLOOR TROUGH	1	-	-	4" OD
FT	6' FLOOR TROUGH	1	-	-	4" OD
HE	HOT PREP EXHAUST HOOD	1	-	-	-
CE	COOKLINE EXHAUST HOOD	1	-	-	-
DE	DISHWASHING EXHAUST HOOD	1	-	-	-
DB	24" DRIN BOARD	1	-	-	INDIRECT TO FLOOR SINK
IB	36" ICE BIN	1	-	-	INDIRECT TO FLOOR SINK
SB	S/S SERVICE BAR	1	-	-	INDIRECT TO FLOOR SINK
HB	BAR HAND SINK	1	1/2"	1/2"	1-1/2" IPS
CS	4 COMPARTMENT BAR SINK	1	1/2"	1/2"	INDIRECT TO FLOOR SINK

1 WATER AND GAS PLUMBING PLAN  
P2  
SCALE: 1/4" = 1'-0"  
NORTH

PROFESSIONAL SEAL

PROFESSIONAL IN CHARGE  
R. SMITH  
PROJECT MANAGER  
A. HADLOW  
QUALITY CONTROL  
A. HADLOW  
DRAWN BY  
Y. YANG

PROJECT NAME  
**BUBBA'S 33**

**GASTONIA  
NORTH CAROLINA**

3287 E. FRANKLIN BLVD.



PROJECT NUMBER  
20181046.0

SHEET TITLE  
**WATER AND GAS  
PLUMBING PLAN**

SHEET NUMBER  
**P2**