

COPYRIGHT NOTICE:
This drawing is the property of the above
mentioned professional and is not to be used
for any purpose other than the specific
project and site named herein, and cannot
be reproduced in any manner without the
express written permission from the professional.

ISSUE/REVISION RECORD


DATE	DESCRIPTION
01/29/19	COORDINATION SET
02/20/19	HEALTH SUBMITTAL
04/24/19	HEALTH RESPONSE
05/03/19	PERMIT/BD SET

GENERAL NOTES

REFER TO ARCHITECTURAL AND CIVIL DRAWINGS FOR GUTTER AND EXTERNAL DOWNSPOUT SYSTEM.

SHEET NOTES

- ① ROOF DRAIN, REFER TO SHEET P7 FOR SPECIFICATION AND REFER SHEET P1 FOR CONTINUATION.
- ② REFER TO SHEET M2 FOR GAS PIPING ROUTED ON ROOF AND VENT THROUGH ROOF LOCATIONS. SEE SHEET P7 FOR GAS PIPING DRAWING.
- ③ SCUPPER THROUGH PARTIAL WALL, BOTTOM OF SCUPPER ABOVE LOWEST PART OF ROOF. RE: ARCHITECTURAL DRAWINGS.

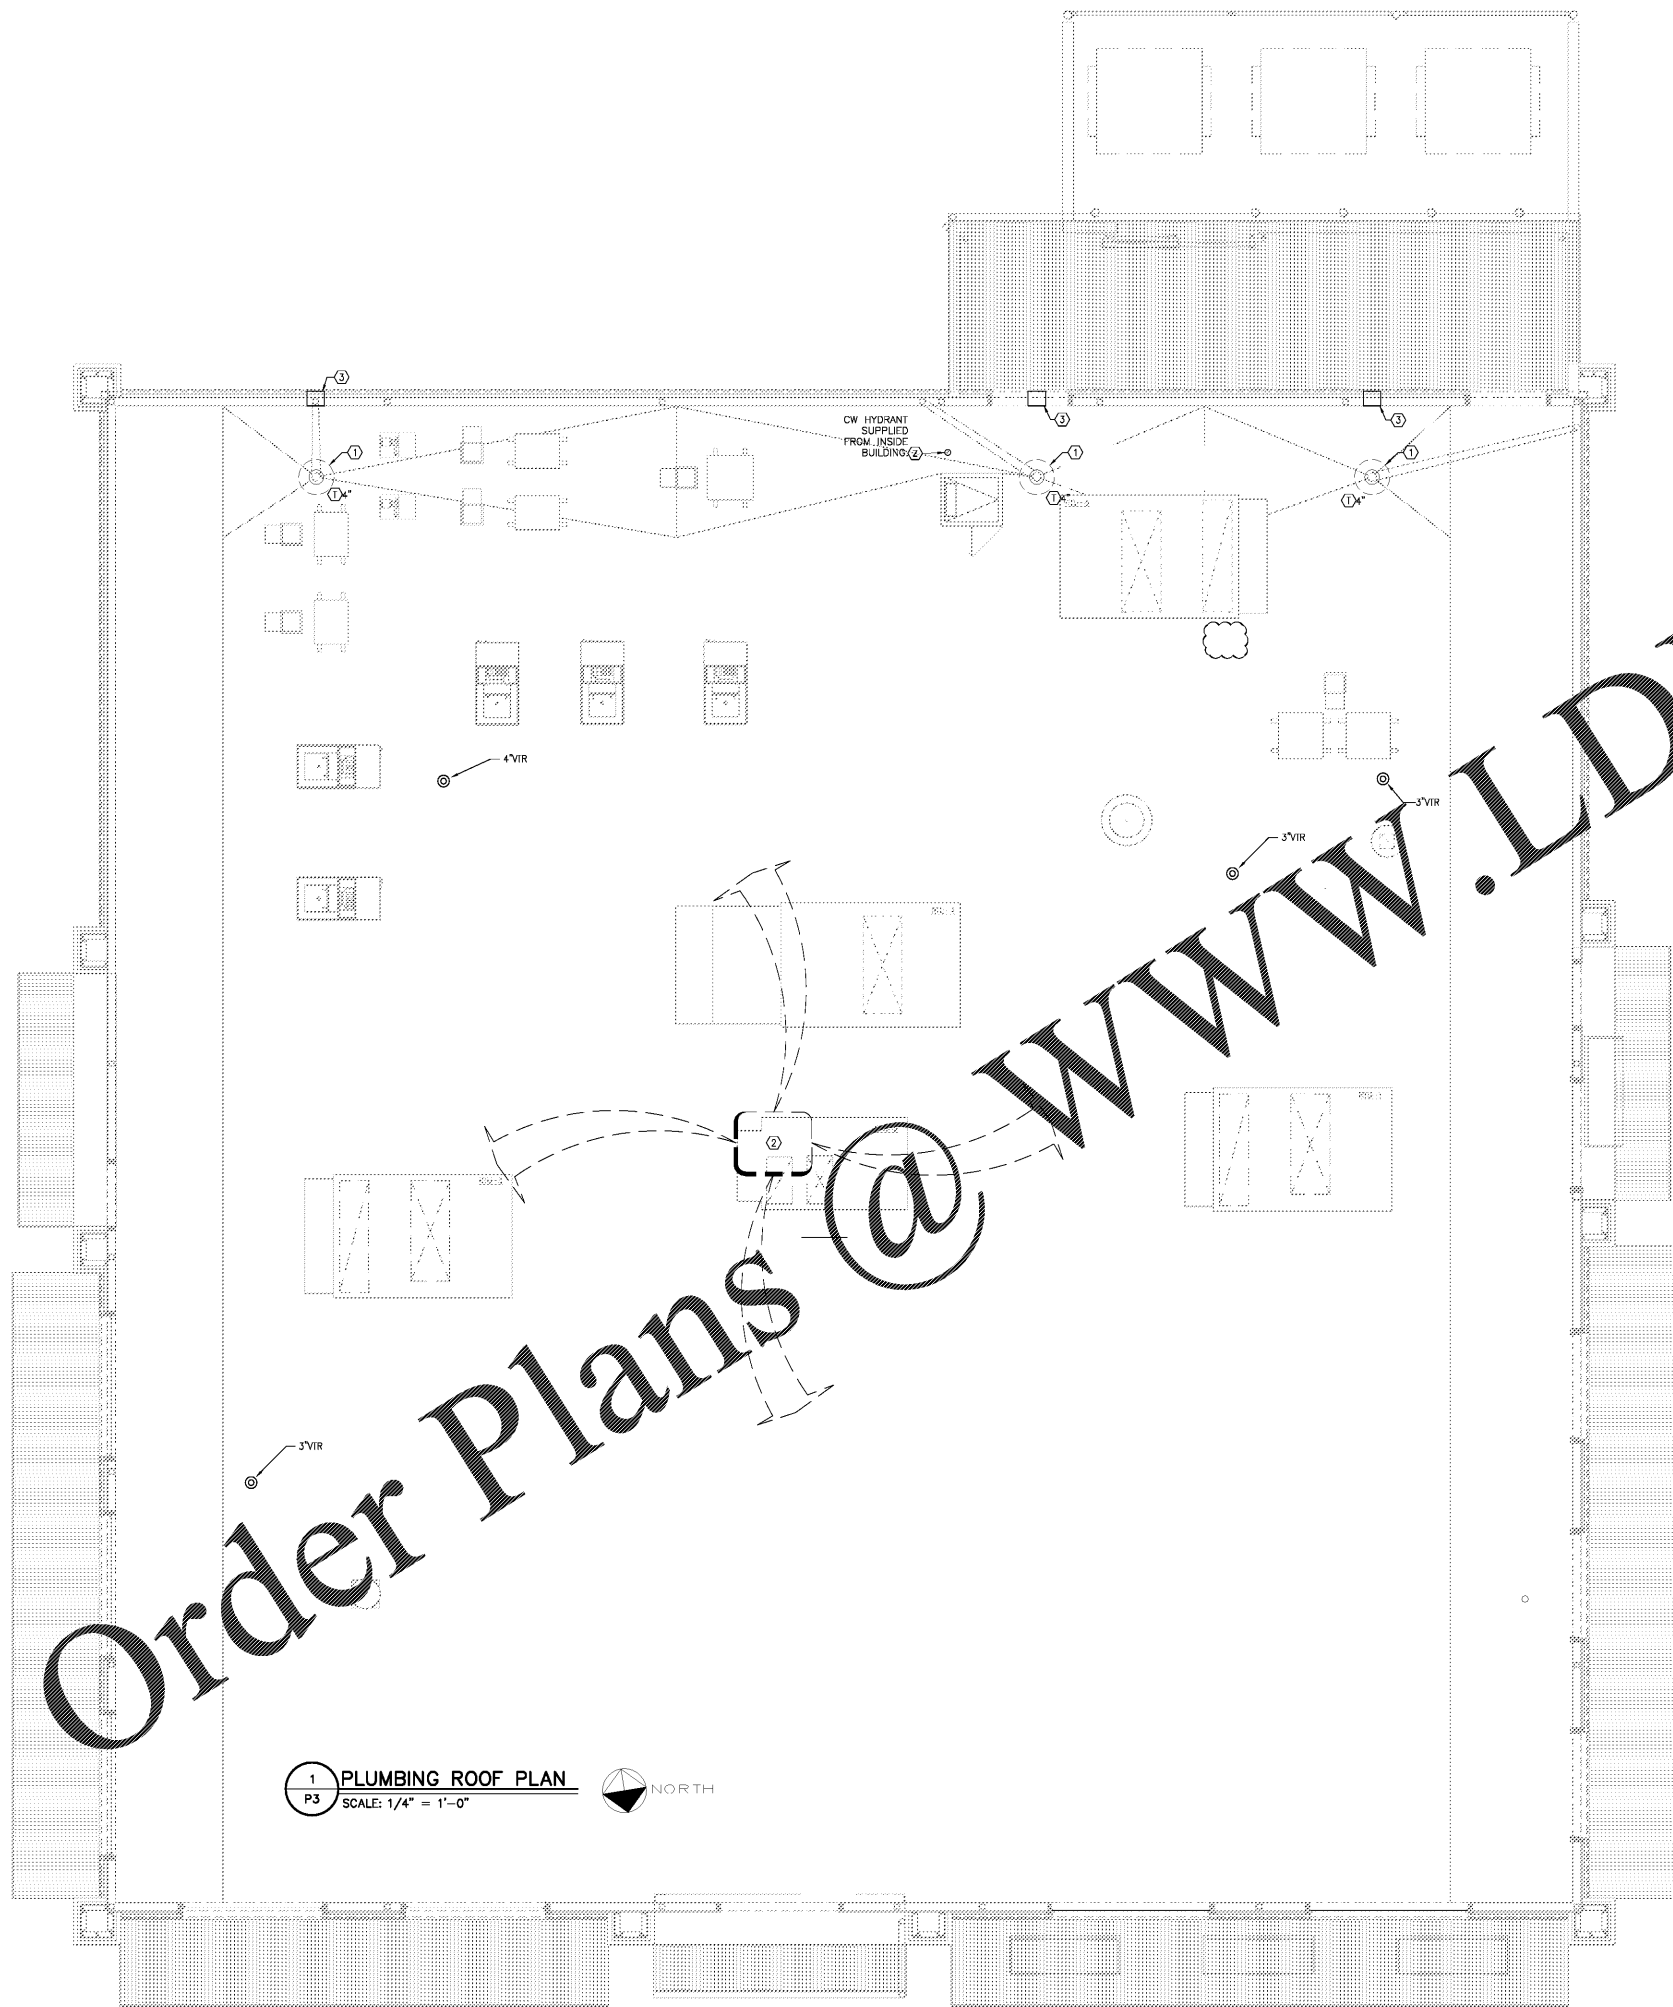

Order Plans @ www.LDILine.com

1 PLUMBING ROOF PLAN
P3 SCALE: 1/4" = 1'-0"



PROFESSIONAL SEAL

PROFESSIONAL IN CHARGE
R. SMITH
PROJECT MANAGER
A. HOLLOW
QUALITY CONTROL
A. HOLLOW
DRAWN BY
Y. YANG

PROJECT NAME
BUBBA'S 33

GASTONIA
NORTH CAROLINA
3287 E. FRANKLIN BLOVD.



PROJECT NUMBER
20181046.0

SHEET TITLE
PLUMBING
ROOF PLAN

SHEET NUMBER
P3