


COPYRIGHT NOTICE:
This drawing is the property of the above
mentioned Professional and is not to be used
for any purpose other than the specific
project and site named herein, and cannot
be reproduced in any manner without the
express written permission from the Professional.

| ISSUE/REVISION RECORD | |
|-----------------------|------------------|
| DATE | DESCRIPTION |
| 05/28/19 | COORDINATION SET |
| 02/20/19 | HEALTH SUBMITTAL |
| 04/24/19 | HEALTH RESPONSE |
| 05/03/19 | PERMIT/BD SET |

| PLUMBING FIXTURE ROUGH-IN SCHEDULE | | | | | |
|------------------------------------|--------------------------------|------|------------------|------------------|---|
| MARK | ITEM | QTY. | CONN. SIZE CN | CONN. SIZE IN | WASTE |
| 1 | WATER CLOSET | 2 | 1" | 4" | DIRECT |
| 2 | WATER CLOSET (HANDICAP) | 3 | 1" | 4" | DIRECT |
| 3 | URINAL | 2 | 3/4" | 4" | DIRECT |
| 4 | LAUNDRY (ROUGH SINK) | 2 | 1/2" | 1-1/2" | DIRECT |
| 5 | MOP BASIN DRAIN | 1 | - | 3" | DIRECT |
| 6 | FLOOR DRAIN (RESTROOM) | 6 | - | 3" | DIRECT |
| 7 | FLOOR DRAIN (KITCHEN) | 10 | - | 4" | DIRECT |
| 8 | FLOOR DRAIN (FUNNEL) | 3 | - | 4" | DIRECT |
| 9 | FLOOR DRAIN (UTILITY) | 1 | - | 4" | DIRECT |
| 10 | FLOOR SINK (GENERAL) | 10 | - | 4" | DIRECT |
| 11 | FLOOR SINK (DISHWASHER/KETTLE) | 4 | - | 4" | DIRECT |
| 12 | SERVICE FAUCET | 1 | 1/2" | 1/2" | - |
| 13 | WALL HYDRANT | 2 | 1/2" | 1/2" | - |
| 14 | ITEM TO BE FURNISHED | 1 | - | - | ITEM TO BE FURNISHED BY OWNER OR SUPPLIER |
| 15 | CLEANOUT | 13 | - | - | - |
| 16 | FLOOR SINK | 8 | - | 4" | DIRECT |
| 17 | FLOOR TROUGH | 4 | - | 4" | DIRECT |
| 18 | THERMOSTATIC MIXING VALVE | 14 | 3/4" | 3/4" | - |
| 19 | LAUNDRY (WALL MOUNTED) | 1 | 1/2" | 1-1/2" | DIRECT |
| 20 | ROOF HYDRANT | 1 | 3/4" | - | - |
| 21 | COOLER/FREEZER | 5 | - | 1-1/2" | INDIRECT TO FLOOR SINK/FLOOR DRAIN |
| 22 | S/S PREP SINK | 1 | 1/2" | 1/2" | INDIRECT TO FLOOR SINK/FLOOR DRAIN |
| 23 | 24" GAS GRIDDLE | 1 | - | - | - |
| 24 | CHARBROILER | 1 | - | - | - |
| 25 | DROP IN ICED COLD WELL | 1 | - | - | INDIRECT TO FLOOR SINK/FLOOR DRAIN |
| 26 | 18" DEEP FRYER | 5 | - | - | - |
| 27 | CHEF'S/STEAM TABLE | 1 | - | 1-1/2" | INDIRECT TO FLOOR SINK |
| 28 | DROP IN HOT WELL | 1 | - | 1/2" | INDIRECT TO FLOOR SINK |
| 29 | CONVECTION OVEN | 1 | - | - | - |
| 30 | 6 BURNER RANGE | 1 | - | - | - |
| 31 | WATER FILTER ASSEMBLY | 1 | 1/2" | - | - |
| 32 | POT FILLER FAUCET | 1 | - | 1/2" (1107) | - |
| 33 | PIZZA OVEN | 2 | - | - | - |
| 34 | ICED TEA BREWER | 1 | 1/2" (9) | - | - |
| 35 | COFFEE BREWER | 1 | 1/2" (9) | - | - |
| 36 | SODA DISPENSER | 1 | - | - | INDIRECT TO FLOOR SINK |
| 37 | BOOSTER HEATER | 1 | - | 3/4" | - |
| 38 | DRY/DISH TABLE | 1 | - | 1/2" (1107) | INDIRECT TO FLOOR SINK |
| 39 | PRE-RINSE SPRAY ASSEMBLY | 1 | 1/2" | 1/2" | INDIRECT TO FLOOR SINK |
| 40 | DISH MACHINE | 1 | - | 3/4" (1107) | INDIRECT TO FLOOR SINK |
| 41 | CLEAN DISH RAMP/S COMP SINK | 1 | 1/2" | 1/2" | INDIRECT TO FLOOR SINK |
| 42 | ICE MACHINE HEAD UNIT | 1 | 1/2" (5) | - | INDIRECT TO FLOOR SINK |
| 43 | ICE BIN | 1 | - | - | INDIRECT TO FLOOR SINK/TROUGH |
| 44 | WATER FILTRATION SYSTEM | 1 | 3/4" | - | - |
| 45 | CARBONATOR/PUMP DECK | 1 | 1/2" (9) | - | - |
| 46 | SUMMINE HANDSINK | 1 | 1/2" | 1/2" | 1-1/2" IPS |
| 47 | HAND SINK | 5 | 1/2" | 1/2" | 1-1/2" IPS |
| 48 | EYE WASH ATTACHMENT | 1 | - | - | - |
| 49 | KNEE PEDAL HAND SINK | 1 | 1/2" | 1/2" | 1-1/2" IPS |
| 50 | 5' FLOOR TROUGH | 1 | - | 4" OD | - |
| 51 | 6' FLOOR TROUGH | 1 | - | 4" OD | - |
| 52 | 6' FLOOR TROUGH | 1 | - | 4" OD | - |
| 53 | HOT PREP EXHAUST HOOD | 1 | - | - | - |
| 54 | COOKLINE EXHAUST HOOD | 1 | - | - | - |
| 55 | DISHWASHING EXHAUST HOOD | 1 | - | - | - |
| 56 | 24" DRAM BOARD | 1 | - | - | INDIRECT TO FLOOR SINK |
| 57 | 36" ICE BIN | 1 | - | - | INDIRECT TO FLOOR SINK |
| 58 | S/S SERVICE BAR | 1 | - | - | INDIRECT TO FLOOR SINK |
| 59 | BAR HAND SINK | 1 | 1/2" | 1/2" | 1-1/2" IPS |
| 60 | 4 COMPARTMENT BAR SINK | 1 | 1/2" | 1/2" | INDIRECT TO FLOOR SINK |

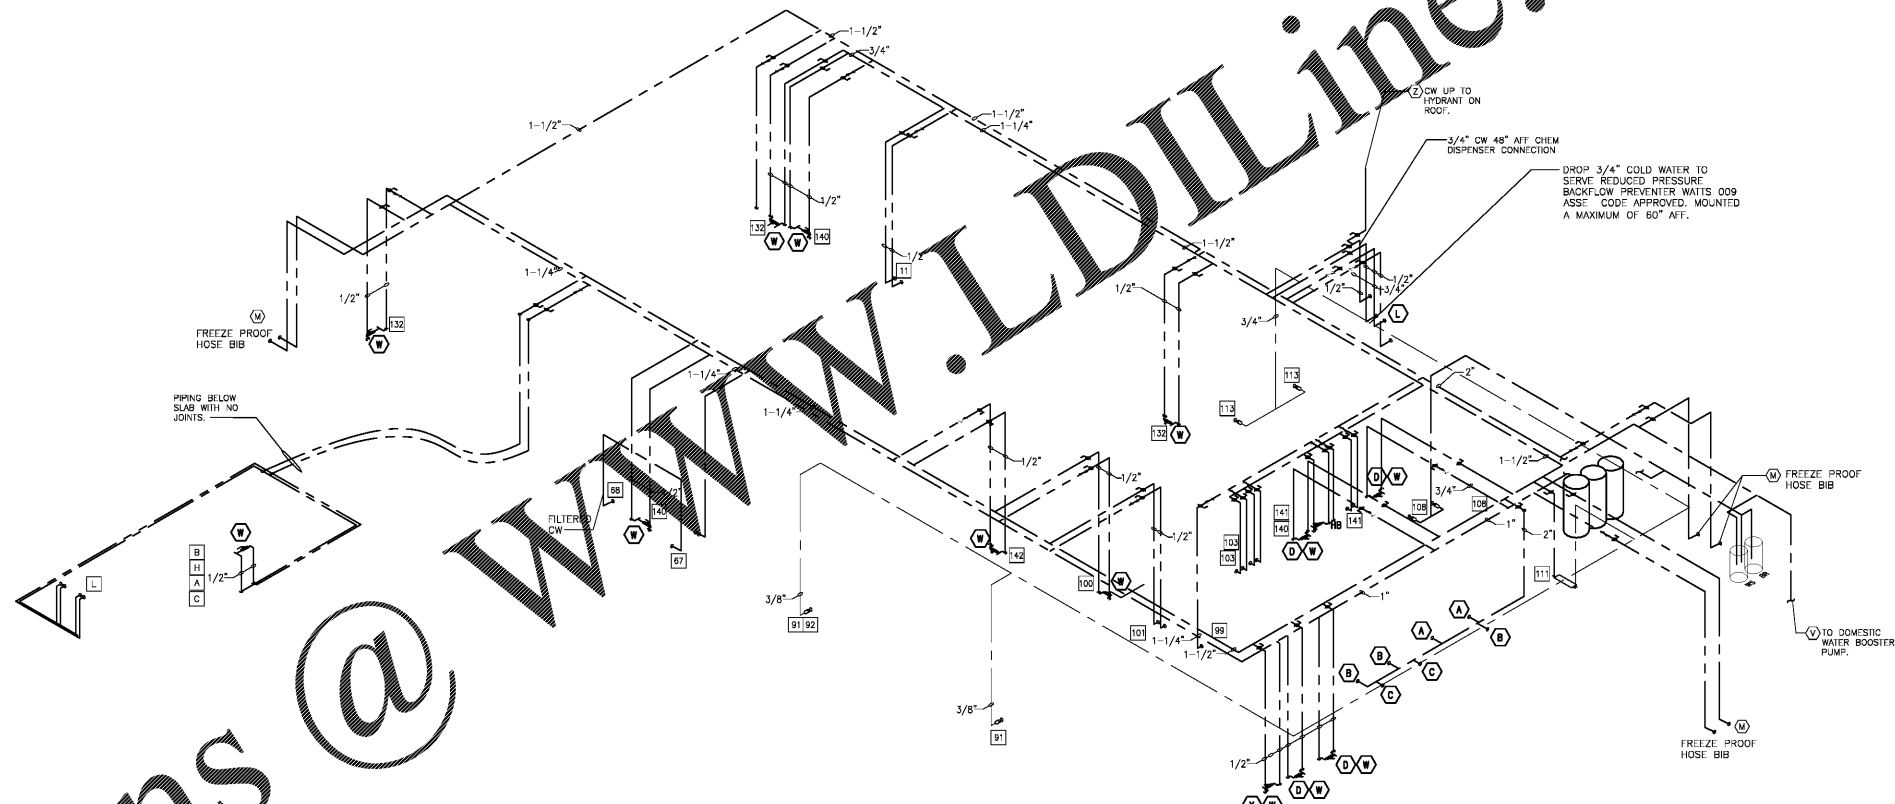

1 DOMESTIC WATER RISER DIAGRAM
P5 SCALE: NONE
 NOTE:
 1. REFER TO SHEET P4 FOR MECHANICAL ROOM PIPING SCHEMATIC.

WWW.LDILine.com

Order Plans @

PROFESSIONAL SEAL

PROFESSIONAL IN CHARGE
 R. SMITH
 PROJECT MANAGER
 A. HADLOW
 QUALITY CONTROL
 A. HADLOW
 DRAWN BY
 Y. YANG

PROJECT NAME
BUBBA'S 33

GASTONIA
NORTH CAROLINA

3287 E. FRANKLIN BLVD.



PROJECT NUMBER
 20181046.0

SHEET TITLE
**DOMESTIC WATER
 RISER DIAGRAM**

SHEET NUMBER
P5