



ISSUE/REVISION RECORD

DATE	DESCRIPTION
01/29/19	COORDINATION SET
02/25/19	HEALTH SUBMITAL
04/24/19	HEALTH RESPONSE
05/03/19	PERMIT/BD SET

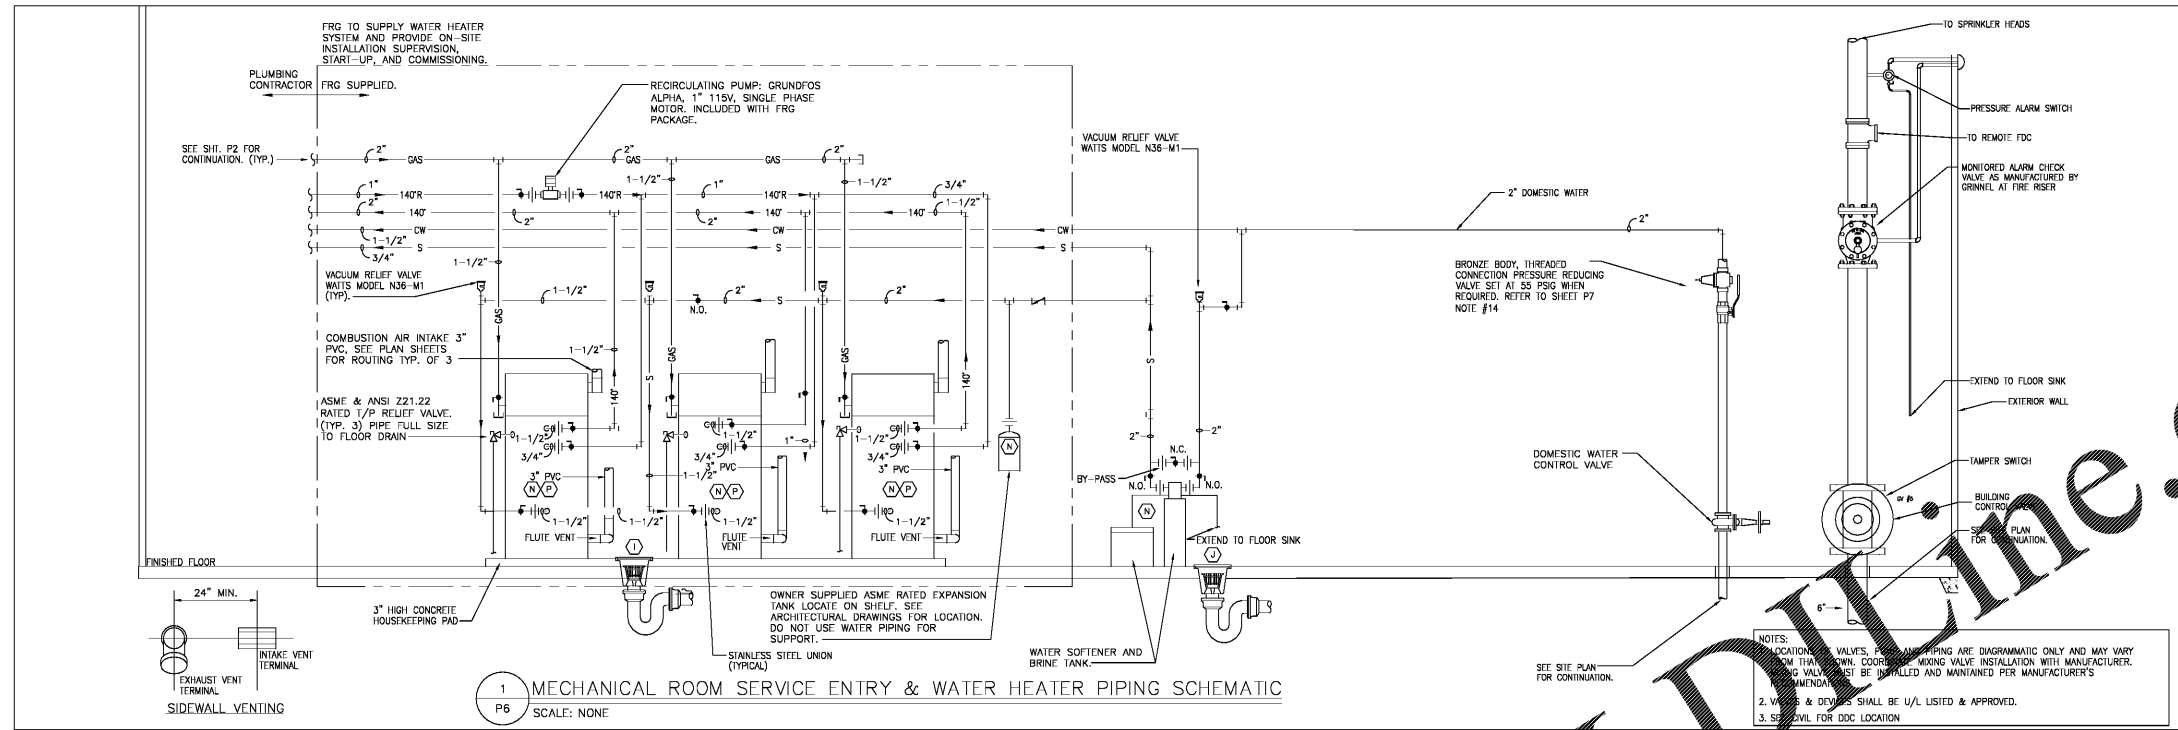

WATER HEATING SOLUTION NATIONAL ACCOUNT


THE TANK SYSTEM SPECIFIED SHALL BE PURCHASED THROUGH FRG/HIP NATIONAL ACCOUNTS BY OWNER. THE SUCCESSFUL CONTRACTOR SHALL CONTACT FRG/HIP NATIONAL ACCOUNTS FOR DELIVERY INFORMATION, CONTACT BEN WIRICK @ (877) 554-0004 OR (616) 406-0004. FAX (616) 406-0050 EMAIL: BWIRICK@WEBFRG.COM

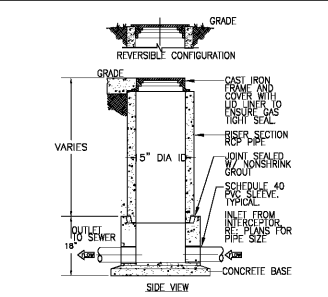

3 SAMPLE WELL ISW-1
SCALE: NONE

NOTES AND SPECIFICATIONS:







- USE 1 1/2" T&G R.C.P. FOR 6'-0" DEEP AND LESS.
- USE 2 1/2" T&G R.C.P. FOR INSTALLATION GREATER THAN 6'-0" DEEP. (STANDARD RING AND M.H. COVER REQUIRED)
- SAMPLING WELL MUST BE SET IN A CIRCULAR OR SQUARE CONCRETE PAD (1'-0" GREATER THAN OUTSIDE DIAMETER OF PIPE.)
- MIN. INSTALLATION MUST BE 4" ABOVE FINISHED GRADE.
- DRIVE & SIDEWALK INSTALLATION MUST BE BROUGHT TO FINISHED GRADE.
- CONCRETE SHALL BE CLASS 30 WITH A DEGREE STRENGTH OF 4000 PSI AT 28 DAYS. UNIT BE OF MONOLITHIC CONSTRUCTION AT FLOOR FIRST SILE OF WALL WITH SCHEDULE 40 RISER REQUIRED DEPTH.
- CAST IRON FRAMES AND FITTINGS SHALL BE MANUFACTURED OF GREY CAST IRON CONFORMING TO ASTM A156-76 CLASS 30, MINIMUM MASH/HD H-20.

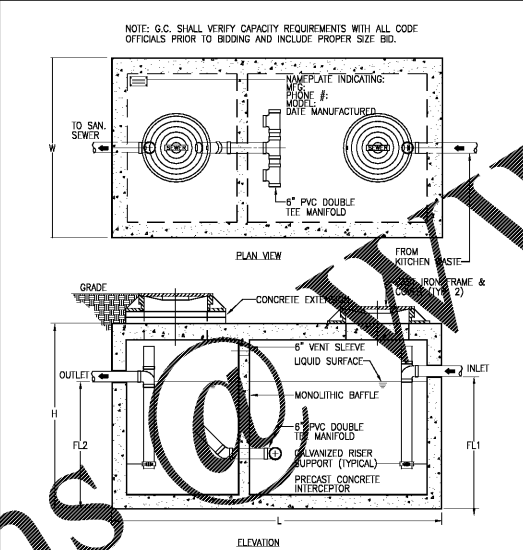

3000 GALLON CAPACITY GREASE TRAP DETAIL
SCALE: NONE

ITEM NO.	MODEL NO.	CAPACITY (GAL)	GREASE CAP. (LBS)	EMPTY CAP. (LBS)	LENGTH (L)	WIDTH (W)	HEIGHT (H)	INLET FL2	OUTLET FL1
GI-1	3000 GL	3,276	10,050	-	18'-2"	7'-2"	7'-2"	5'-6"	5'-6"

NOTE:
1. PRECAST CONCRETE GREASE TRAP SIZE, SHAPE AND DIMENSION MAY VARY FROM DETAIL, BUT SHALL BE IN ALL CASES PER LOCAL CODE REQUIREMENTS.
2. GREASE TRAP TO BE TRAFFIC RATED D.
3. G.C. TO CONTACT JERRY GATES FROM WASTE WATER QUALITY DIVISION (405)279-3769 FOR GREASE INTERCEPTOR.

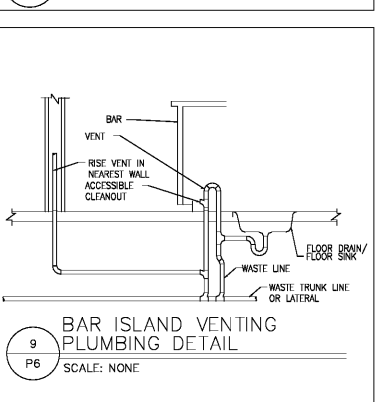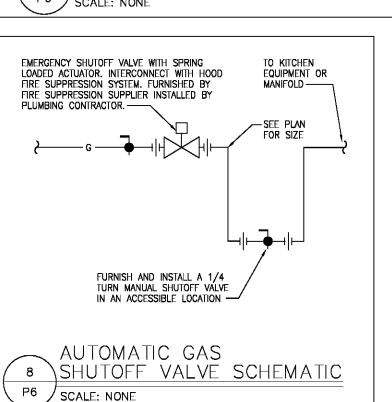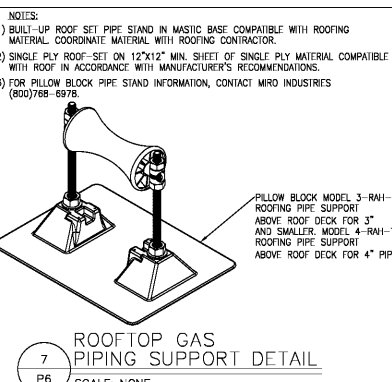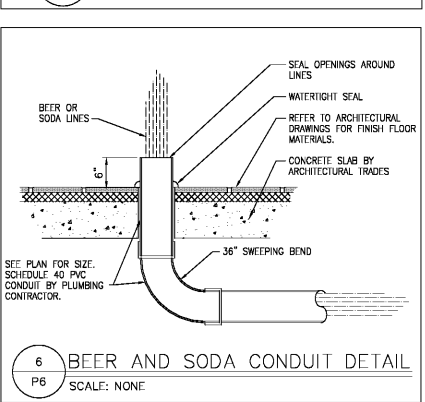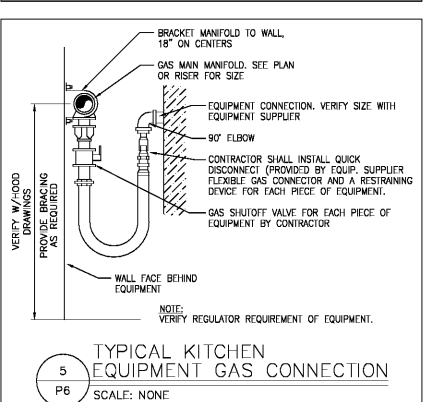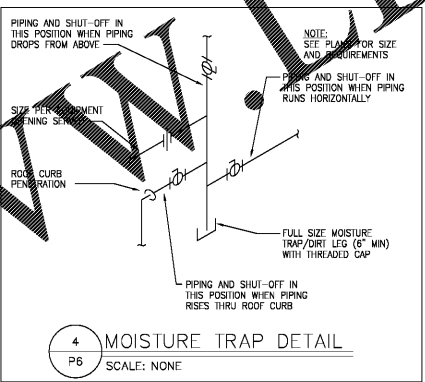

Order Plans @ WWW.AIAA.com

PROFESSIONAL SEAL

PROFESSIONAL IN CHARGE
R. SMITH
PROJECT MANAGER
A. HADLOW
QUALITY CONTROL
A. HADLOW
DRAWN BY
Y. YANG

PROJECT NAME
BUBBA'S 33

GASTONIA NORTH CAROLINA
3287 E. FRANKLIN BLVD.



PROJECT NUMBER
20181046.0

SHEET TITLE
PLUMBING DETAILS

SHEET NUMBER
P6