


TENNESSEE 06/02/19 5:49:45 AM H:\2019\19109-00_DOLLAR TREE\04\Architectural\Shaw\04A_1-2.dwg

Order Plans @ WWW.LDLINE.COM

- NOTE: 1. THE ELECTRICIAN SHALL INSTALL ADDITIONAL #12 WIRE TIE SUPPORTS FROM THE CEILING GRID TO THE STRUCTURE ABOVE FOR SUPPORT OF THE LIGHT FIXTURES CLIPPED ON THE GRID.
- NOTE: 2. LIGHT FIXTURES, SECURITY CAMERA DOMES, AND MIRROR PANELS (UON) ARE DOLLAR TREE SUPPLIED.
- NOTE: 3. MOUNT LIGHTS 10'-0" AFF IN STOCKROOM.

REFLECTED CEILING LEGEND	
	2'-0"x4'-0" ACOUSTICAL CEILING TILE AND GRID - SEE FINISH NOTE 11.
	GWB - PAINT WHITE UNLESS OTHERWISE NOTED.
	8'-0" STRIP LED LIGHT FIXTURE WITH LAMPS ON NIGHT LIGHT CIRCUIT. SURFACE MOUNT TO GWB AND ACT CEILING.
	8'-0" STRIP LED LIGHT FIXTURE. SURFACE MOUNT TO GWB AND ACT CEILING.
	8'-0" STRIP LED LIGHT FIXTURE WITH LAMPS ON EMERGENCY LIGHT CIRCUIT WITH BATTERY PACK. SURFACE MOUNT TO GWB AND ACT CEILING. FOR FIXTURES WITH 4 LAMPS, THE EMERGENCY BATTERY PACK WILL ONLY OPERATE 2 OF THE LAMPS.
	4'-0" STRIP LED LIGHT FIXTURE WITH LAMPS ON NIGHT LIGHT CIRCUIT. SURFACE MOUNT TO TO GWB AND ACT CEILING.
	4'-0" STRIP LED LIGHT FIXTURE. SURFACE MOUNT TO ACT AND GWB CEILING.
	4'-0" STRIP LED LIGHT FIXTURE WITH LAMPS ON NIGHT LIGHT CIRCUIT WITH BATTERY PACK. SURFACE MOUNT TO GWB AND ACT CEILING.
	EXIT LIGHT
	VENTILATOR FAN
	CEILING HEIGHT ABOVE FINISH FLOOR
	DIFFUSER
	RETURN AIR GRILLE
	POWER POLE

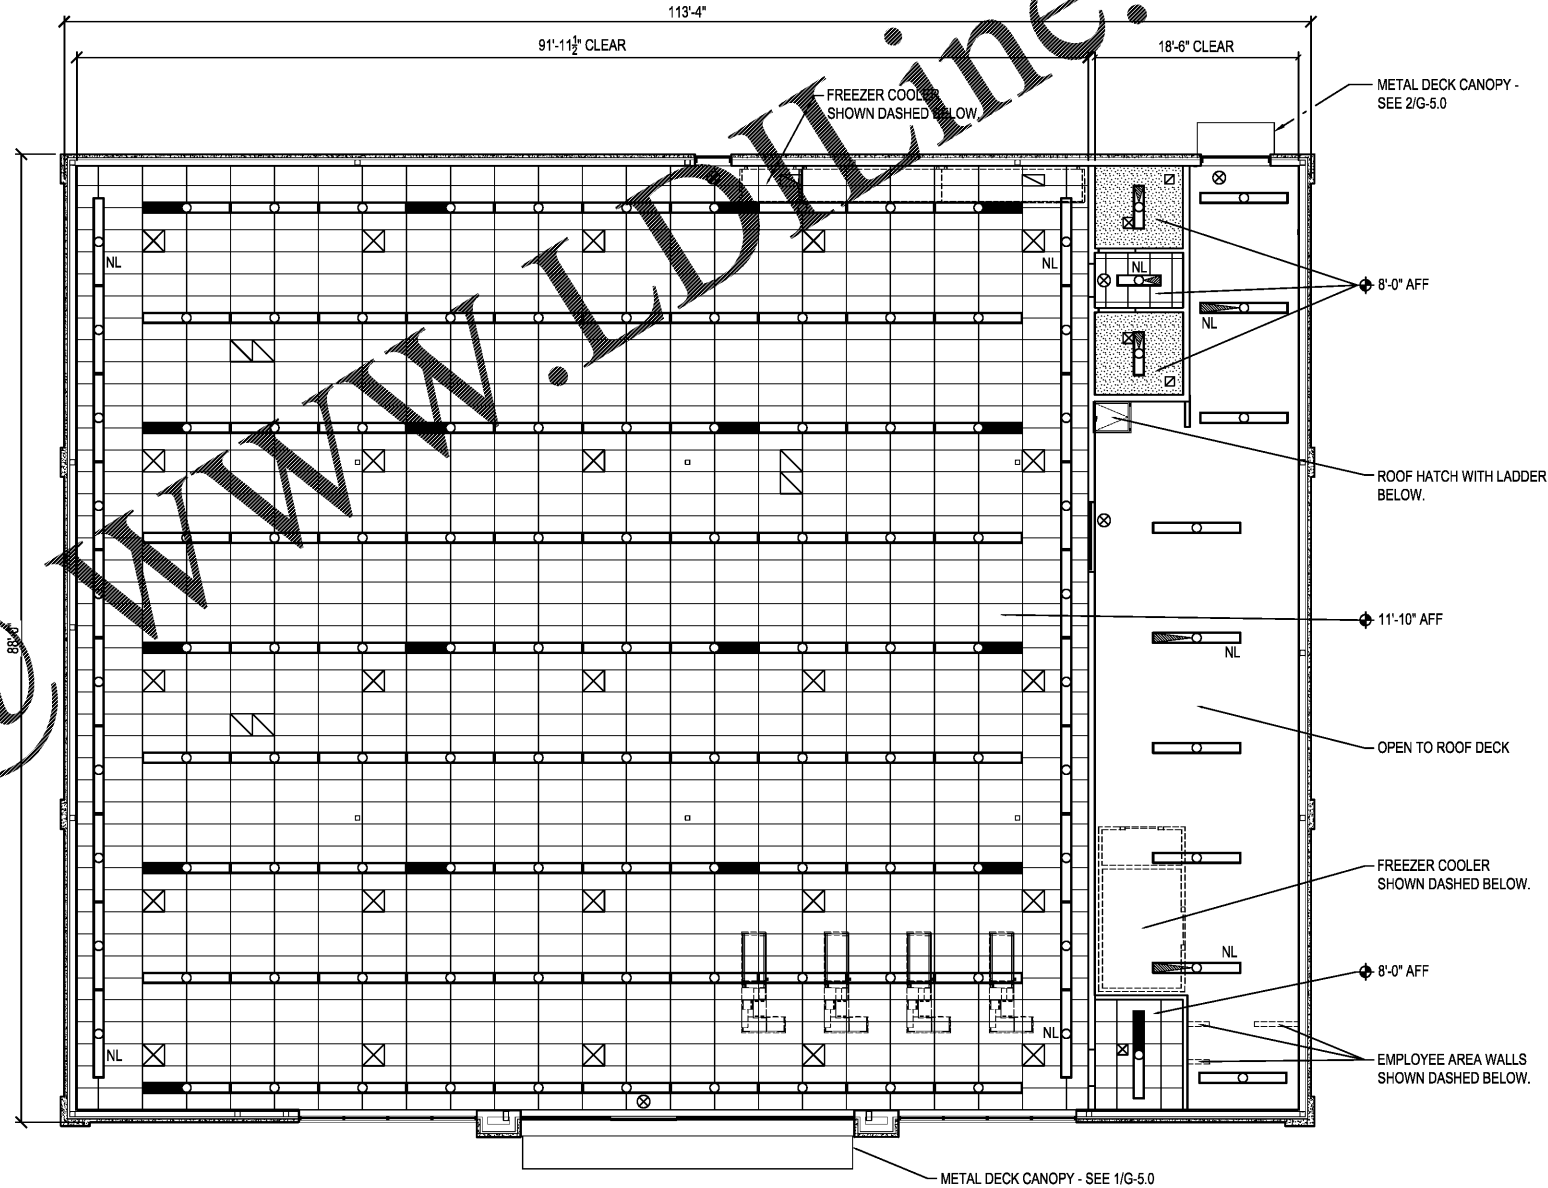

REFLECTED CEILING PLAN
SCALE: 1/8"=1'-0"

REV. DATE	BY	DESCRIPTION

PROJECT NUMBER: 19109-00
DRAWN BY: RWH/TEH
CHECKED BY: LGS
ISSUE DATE: 06/06/2019
ISSUED FOR BIDS AND PERMITS

